



2/22/06	PROG. REVIEW #1
3/1/06	PROG. REVIEW #2
3/27/06	PROG. REVIEW #3
4/10/06	PROG. REVIEW #4
5/3/06	PRELIM. DESIGN

MARK	DATE	DESCRIPTION

DRAWING ISSUED: 05/03/2006


NOB PROJECT NO.: 220027

PRELIMINARY DESIGN



DRAWING TITLE:
MECHANICAL POWER PLAN - SECOND FLOOR

DRAWING NUMBER:

E132
SHEET 89 OF 106

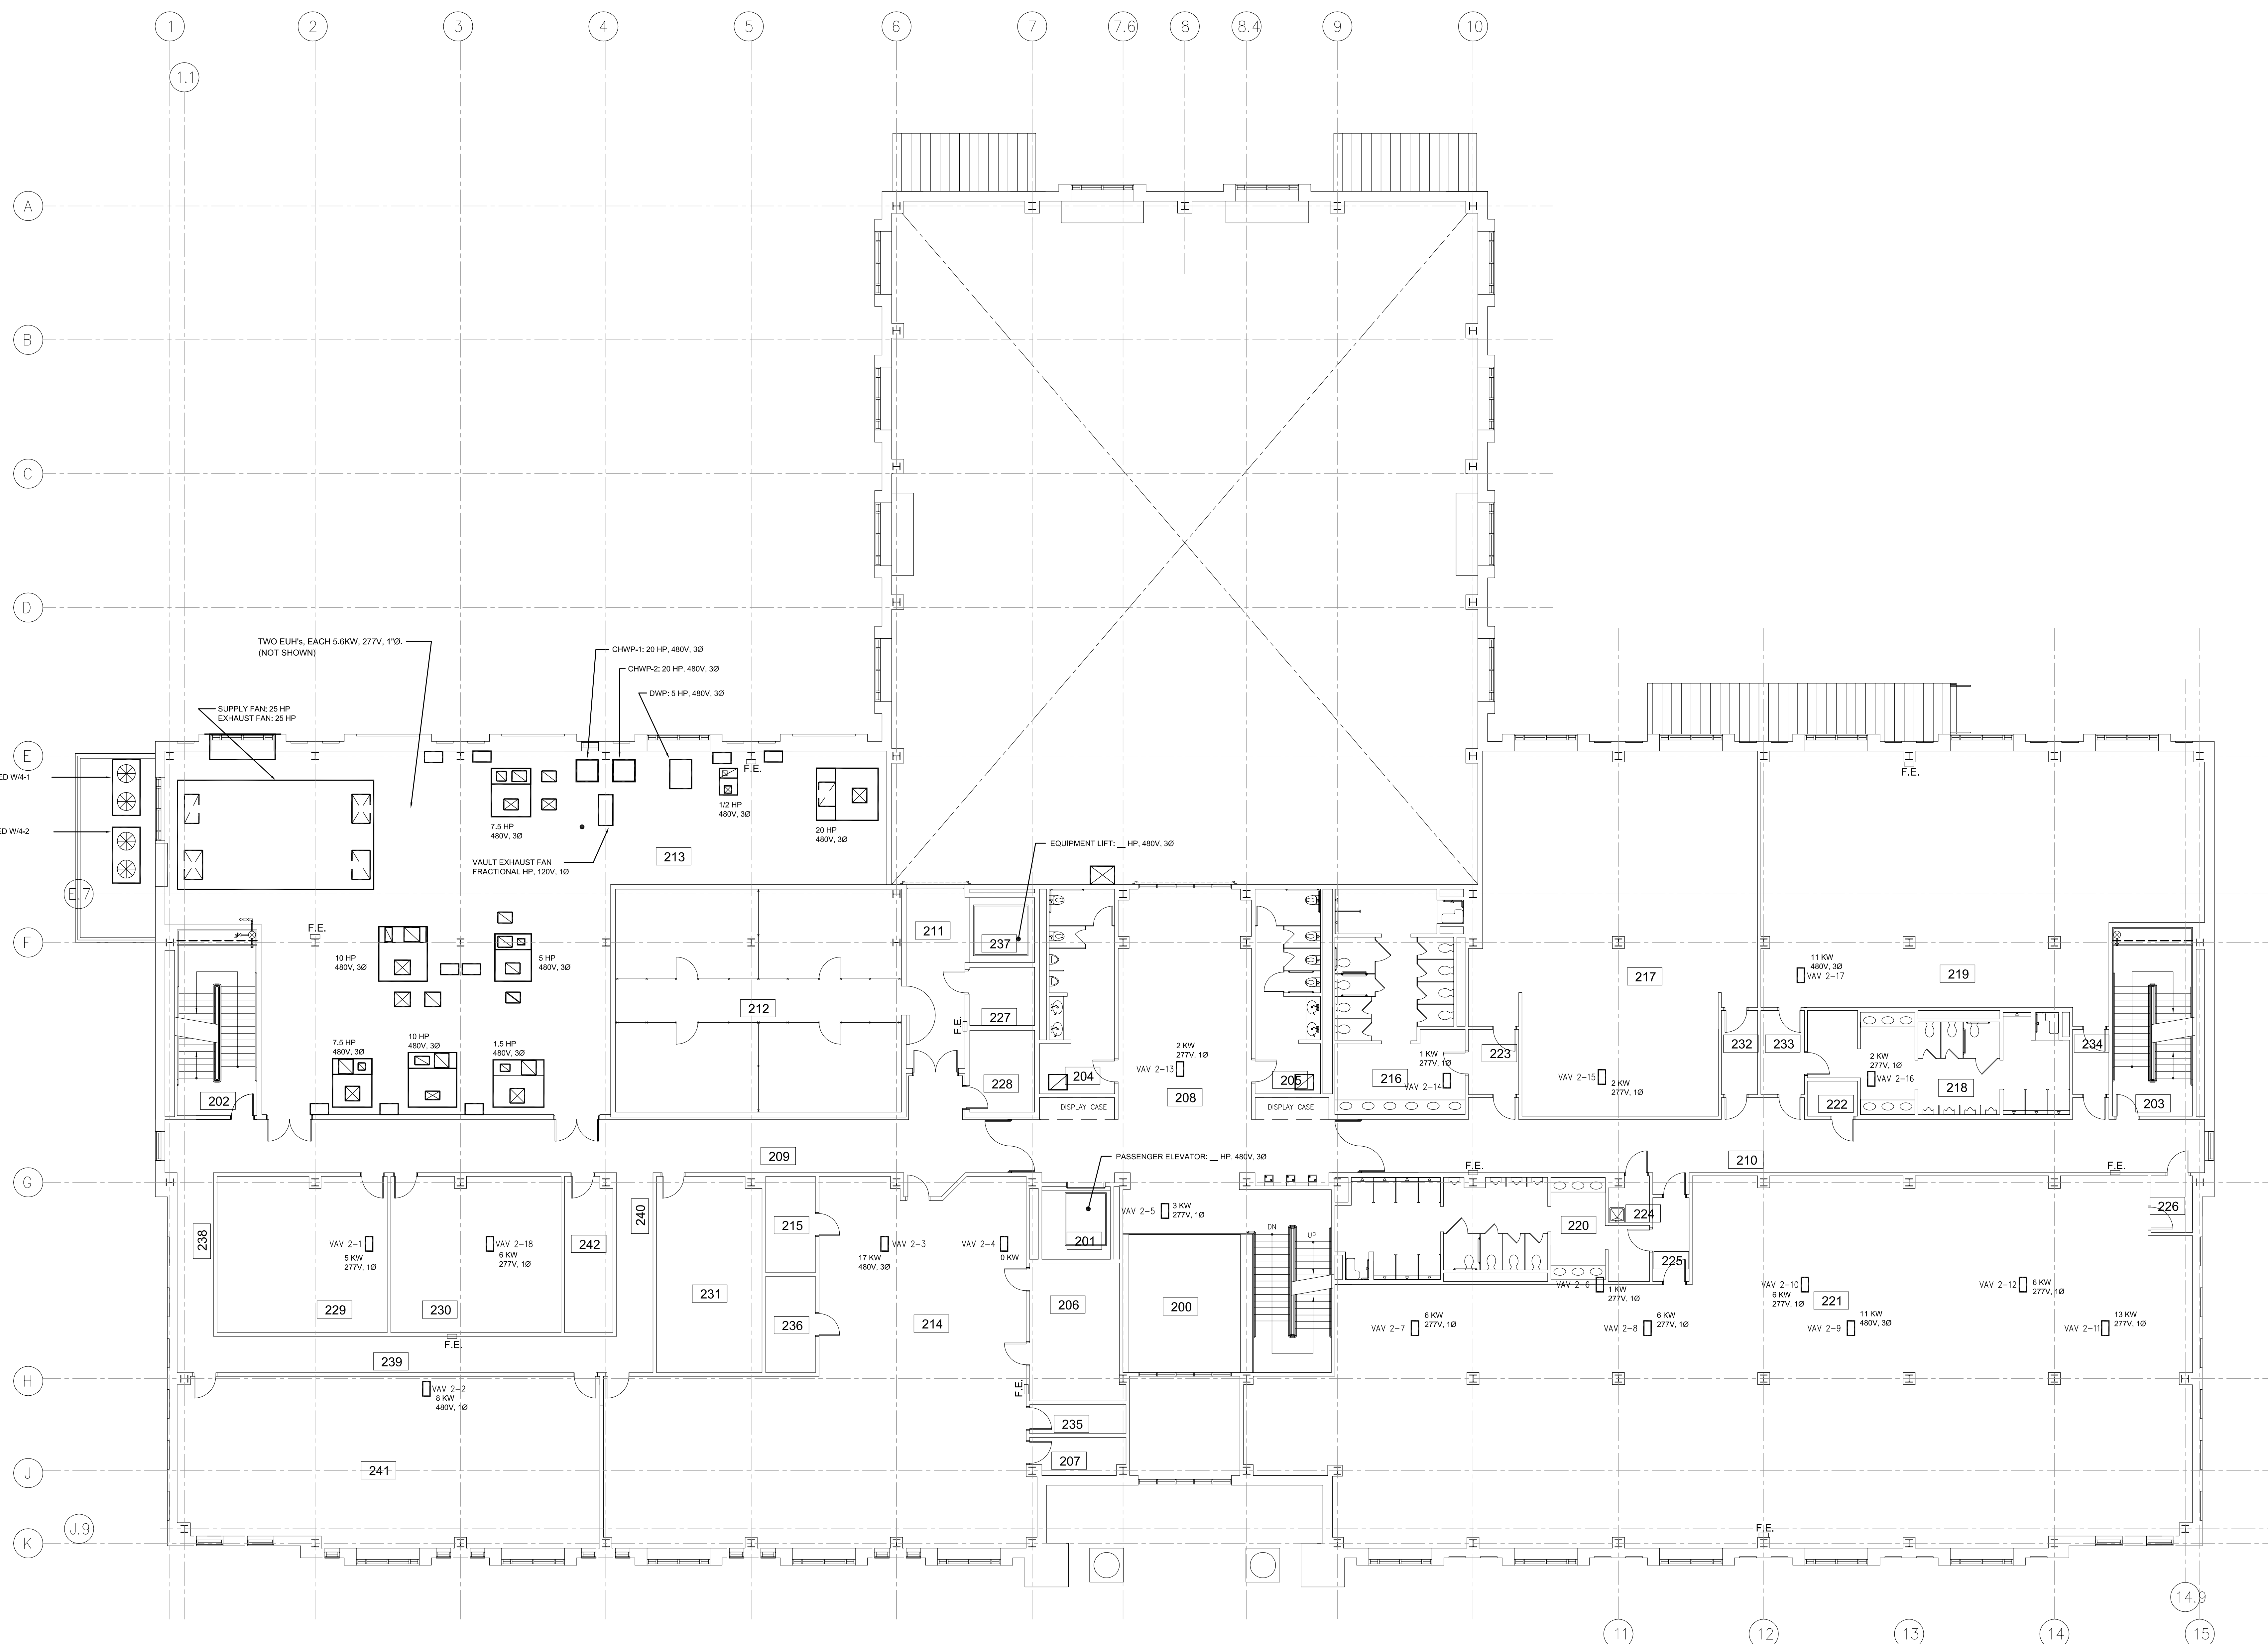

1 MECHANICAL POWER PLAN - SECOND FLOOR

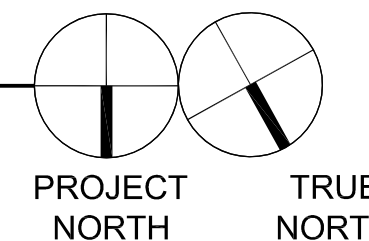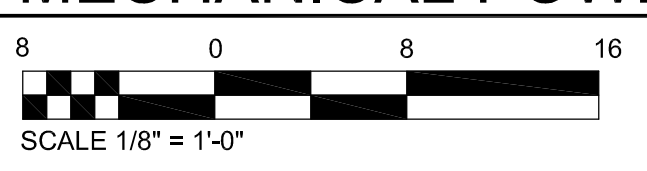

IMC
CONSULTING ENGINEERS
3120 20th STREET
METAIRIE, LOUISIANA 70002

These drawings are conceptual in nature and are not suitable for construction. It is the intent of these documents to clearly delineate the baseline minimum scale, scope and quality of the project. It is the responsibility of the design-builder that his proposal provides for a complete and functional facility responding to relative Army National Guard criteria, recognized industry standards and applicable building codes regardless of the content of these conceptual drawings. Further, it will be the responsibility of the successful design-builder and his architect of record to prepare complete construction documents responding to the fullest intent of the conceptual drawings and specifications.