


**THE SIXTH BAPTIST CHURCH
 RENOVATION AND ADDITION**
 928 FELICITY STREET
 NEW ORLEANS, LOUISIANA 70130

ALL PLUMBING LINES ARE DRAWN DIAGRAMMATICALLY FOR CLARITY.

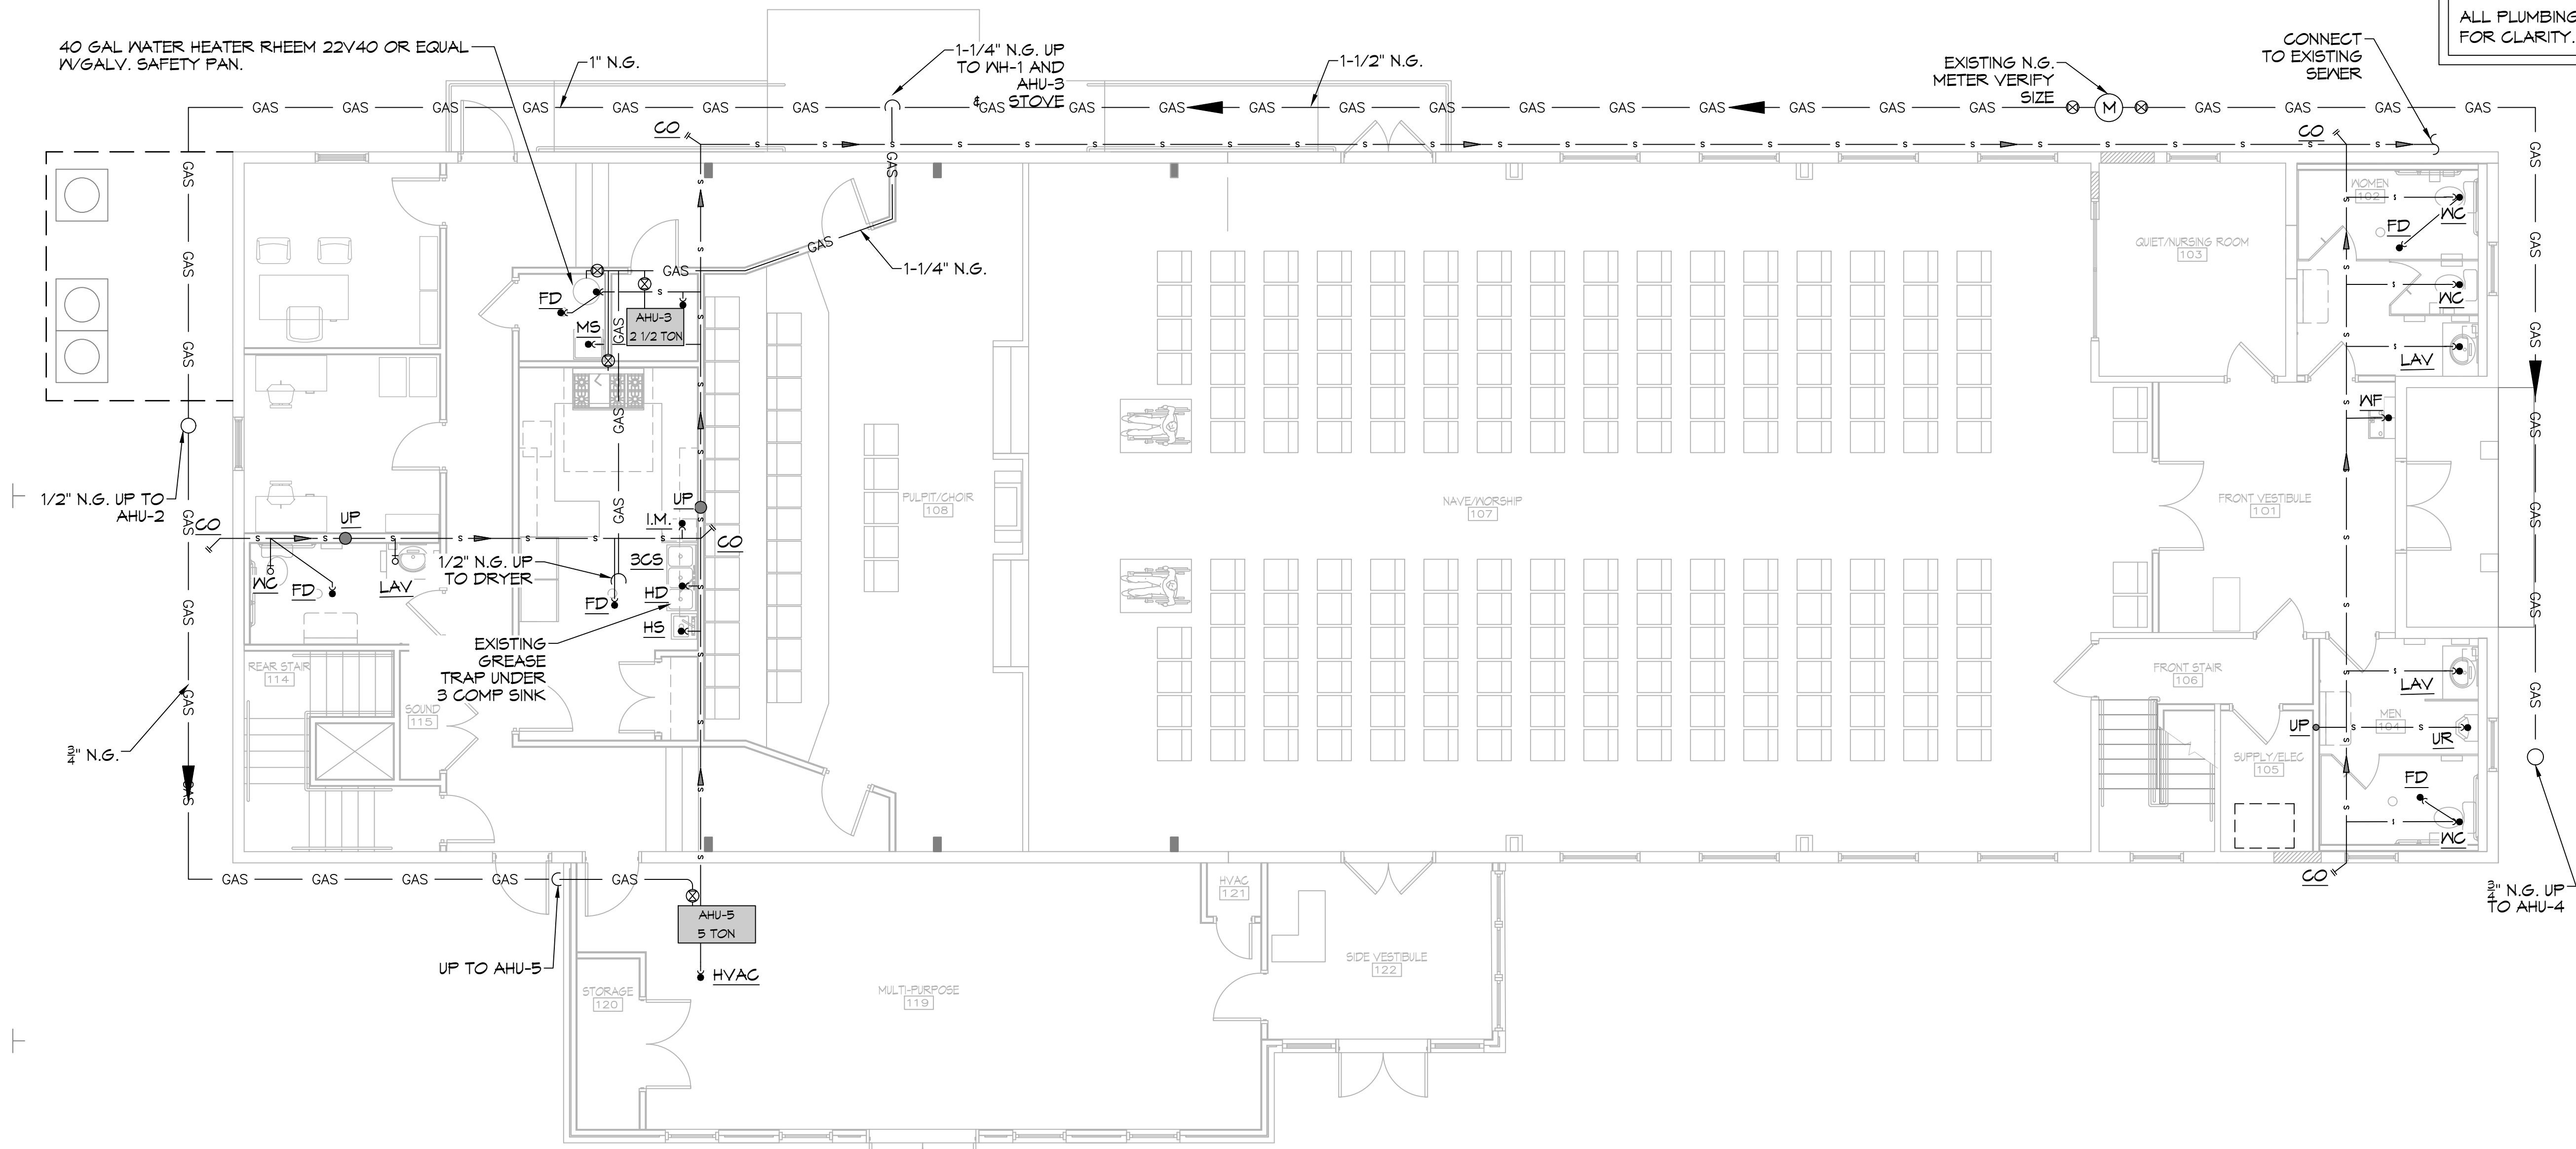

12 SEWER & GAS PLUMBING PLAN
 SCALE: 3/16"=1'-0"

FIRST FLOOR



13 SEWER & GAS PLUMBING PLAN
 SCALE: 3/16"=1'-0"

SECOND FLOOR


| ISSUE | |
|-----------|-----------------------|
| DATE | FOR |
| --/--2023 | CONSTRUCTION DOC-100% |
| | |
| | |
| | |

PROJECT NO: 22201
 DATE: _____
 BY: _____
 CHECKED: _____

PROGRESS PRINT
 NOT FOR CONSTRUCTION

FULL RELEASE
 THIS DRAWING IS FULLY RELEASED BY THE ARCHITECT FOR CONSTRUCTION OF THIS PROJECT ONLY

NOT TO BE COPIED OR REPRODUCED WITHOUT EXPRESSED WRITTEN CONSENT OF HEWITT-WASHINGTON & ASSOCIATES

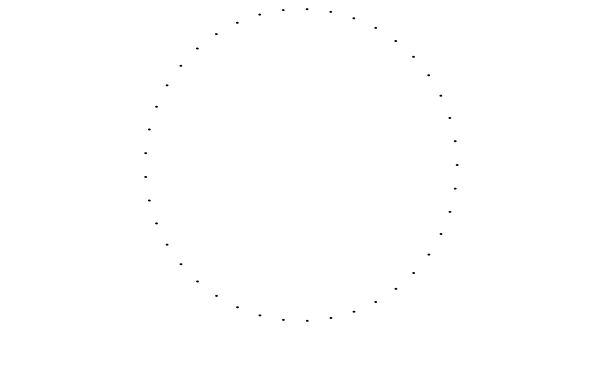

SHEET TITLE
 SEWER AND GAS PLUMBING PLAN - FIRST FLOOR, SECOND FLOOR AND ATTIC
 SHEET NO.

P101
 SHEET OF