



ALL PLUMBING LINES ARE DRAWN DIAGRAMMATICALLY FOR CLARITY.


**THE SIXTH BAPTIST CHURCH
 RENOVATION AND ADDITION**
 928 FELICITY STREET
 NEW ORLEANS, LOUISIANA 70130

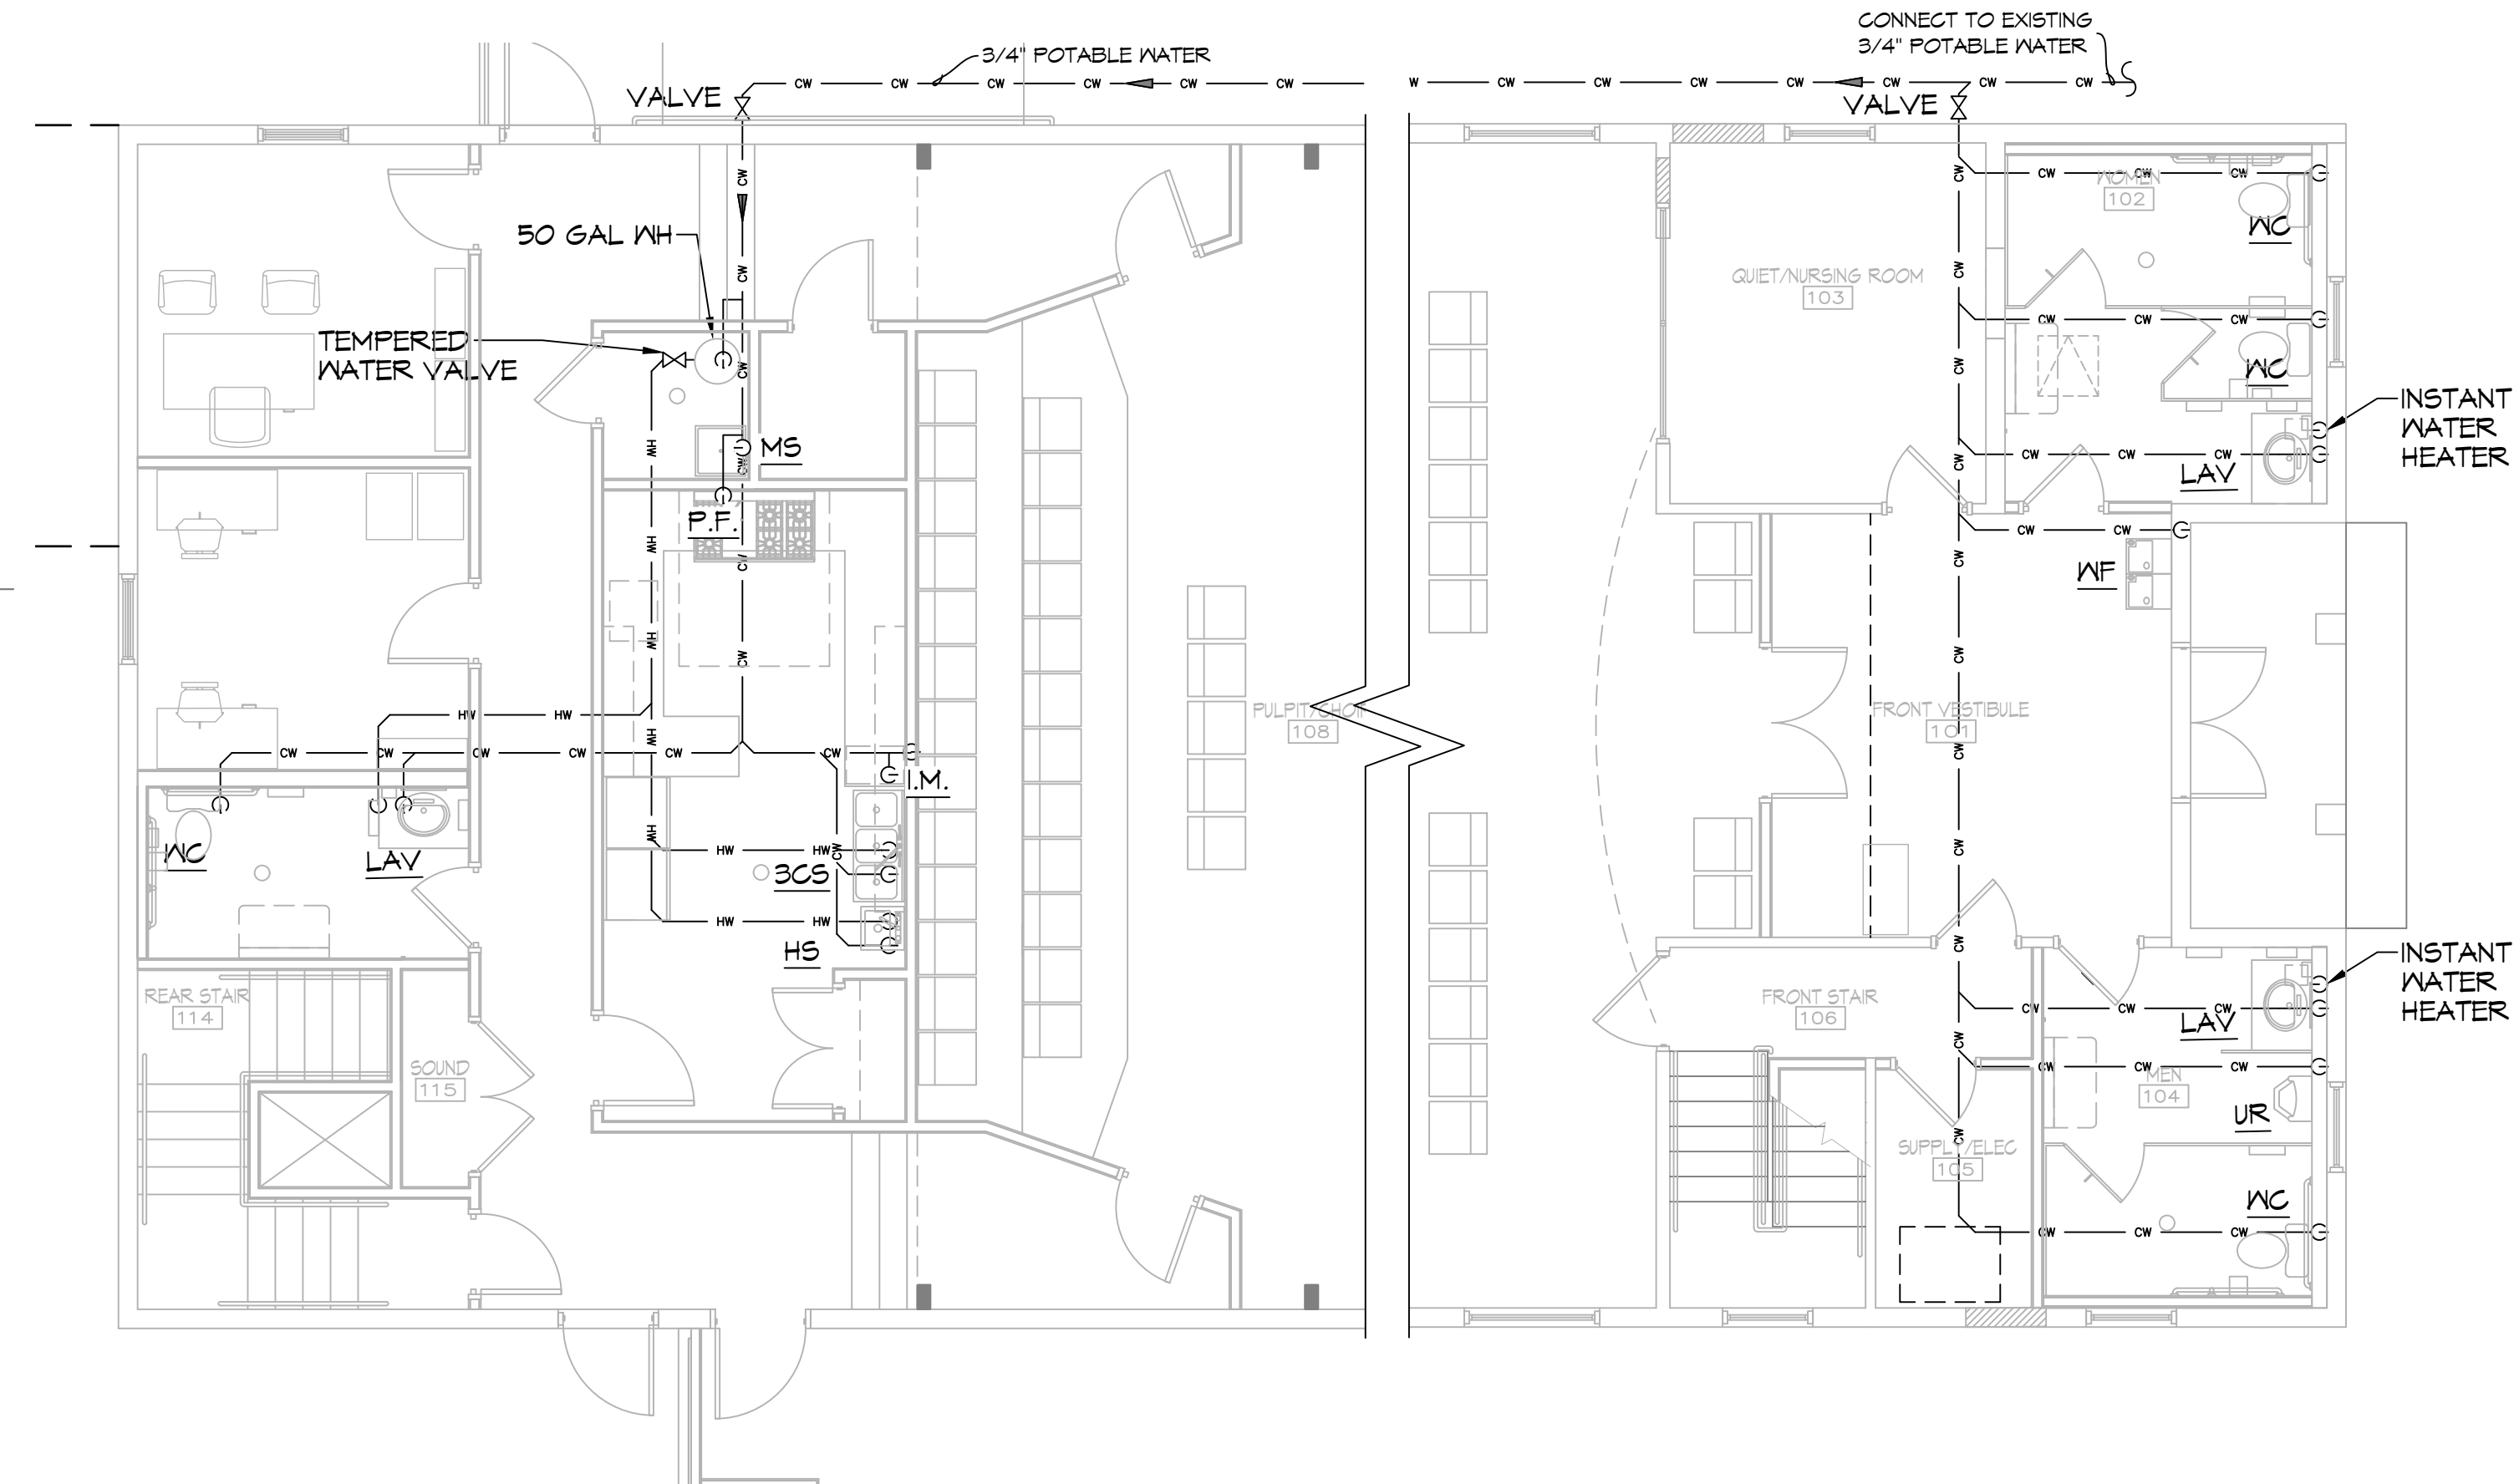

14 POTABLE WATER PLUMBING PLAN
 SCALE: 3/16"=1'-0"
 FIRST FLOOR

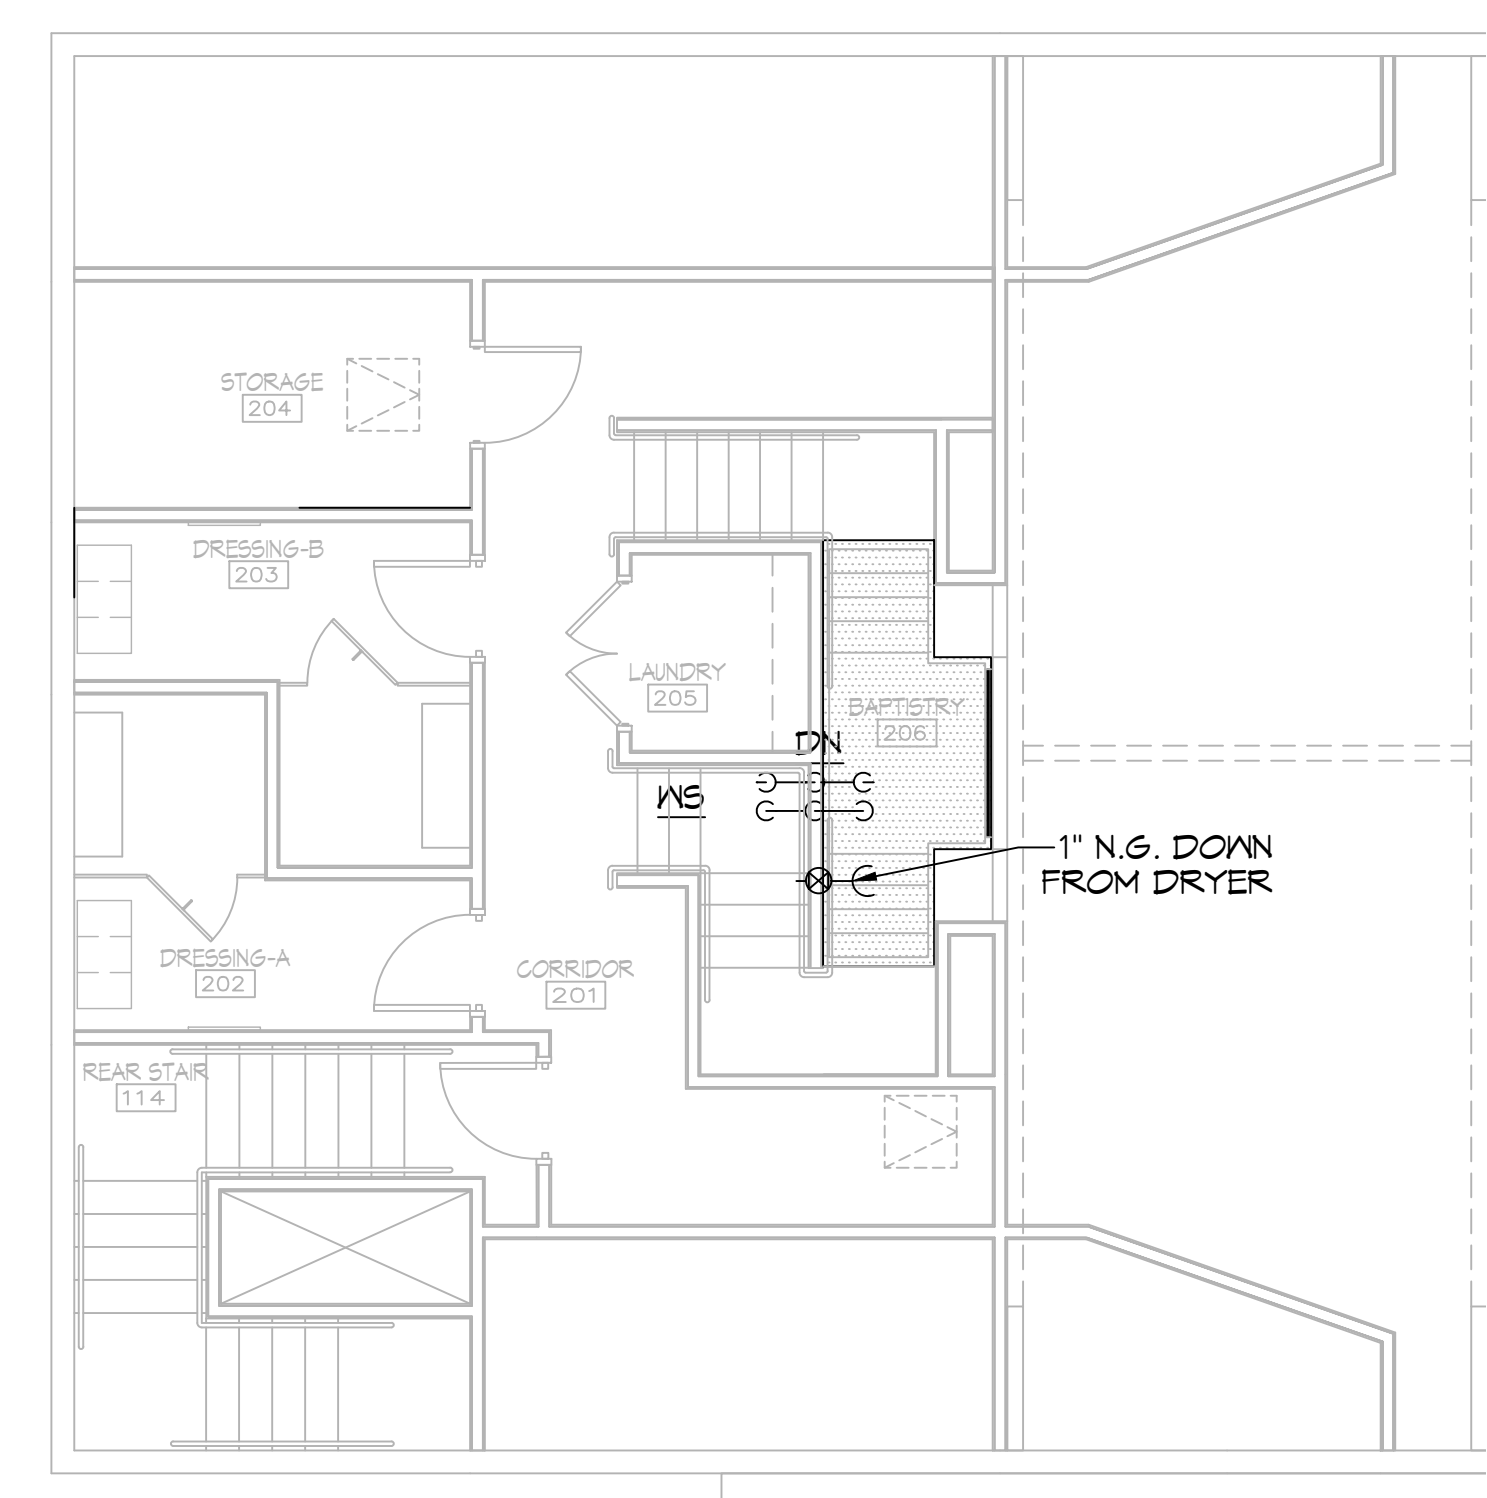

15 POTABLE WATER PLUMBING PLAN
 SCALE: 3/16"=1'-0"
 SECOND FLOOR

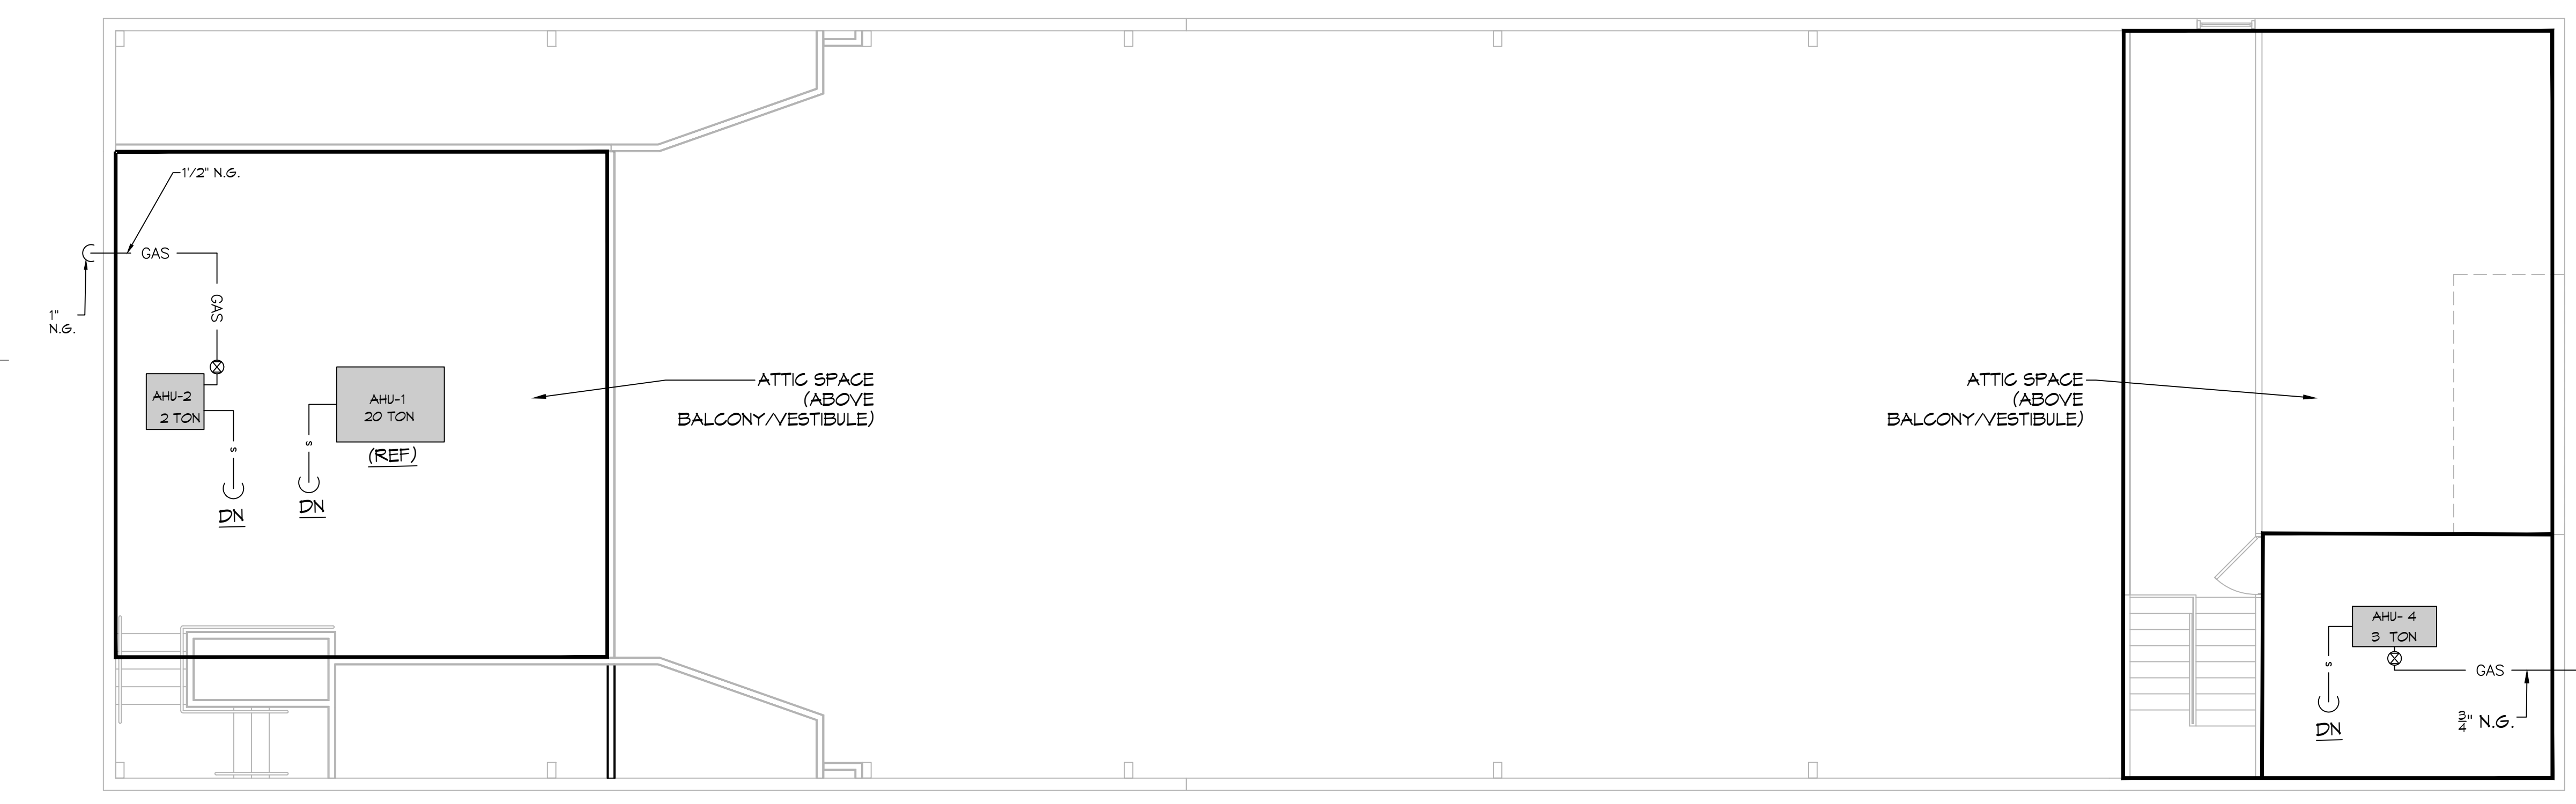

16 SEWER & GAS PLUMBING PLAN
 SCALE: 3/16"=1'-0"
 ATTIC

ISSUE	
DATE	FOR
--/--2023	CONSTRUCTION DOC-100%

PROJECT NO: 22201
 DATE:
 BY:
 CHECKED:

PROGRESS PRINT
 NOT FOR CONSTRUCTION

FULL RELEASE
 THIS DRAWING IS FULLY RELEASED BY THE ARCHITECT FOR CONSTRUCTION OF THIS PROJECT ONLY

NOT TO BE COPIED OR REPRODUCED WITHOUT EXPRESSED WRITTEN CONSENT OF HEWITT-WASHINGTON & ASSOCIATES

SHEET TITLE
 SEWER, GAS & POTABLE
 WATER PLUMBING PLAN
 AND NOTES

SHEET NO.