




ALL PLUMBING LINES ARE DRAWN DIAGRAMMATICALLY FOR CLARITY.

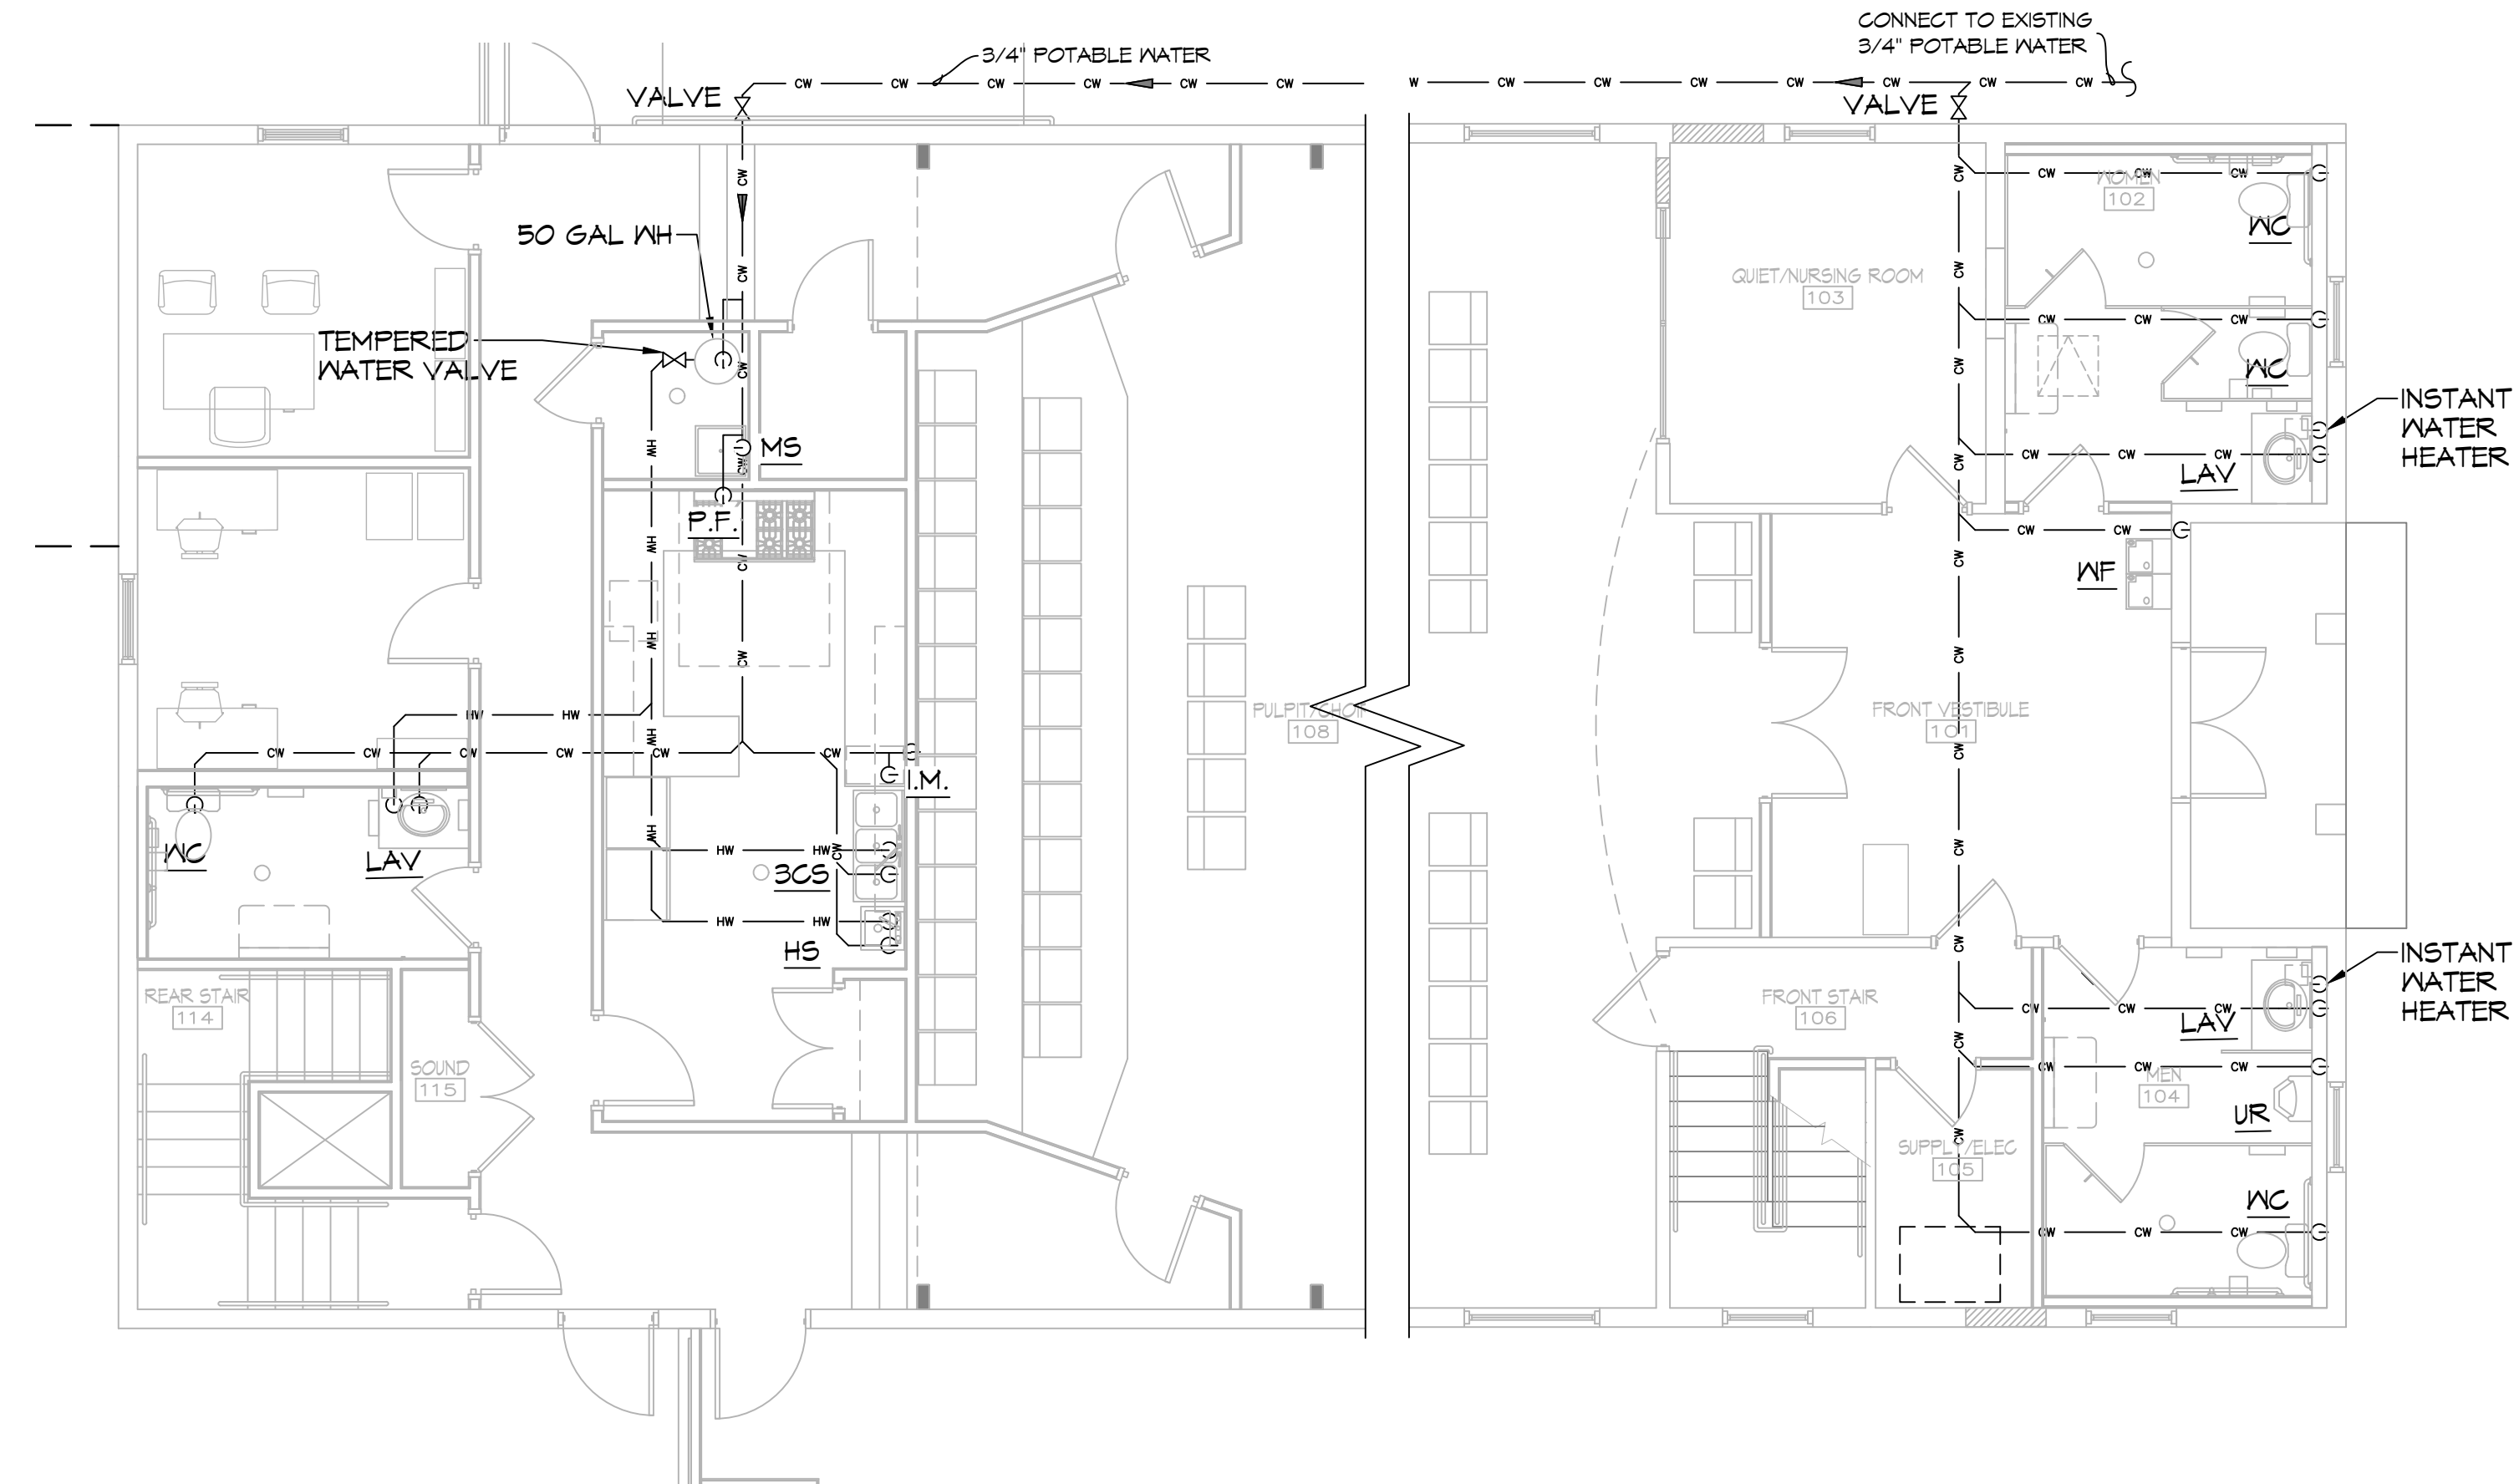

14 POTABLE WATER PLUMBING PLAN
SCALE: 3/16"=1'-0"
FIRST FLOOR

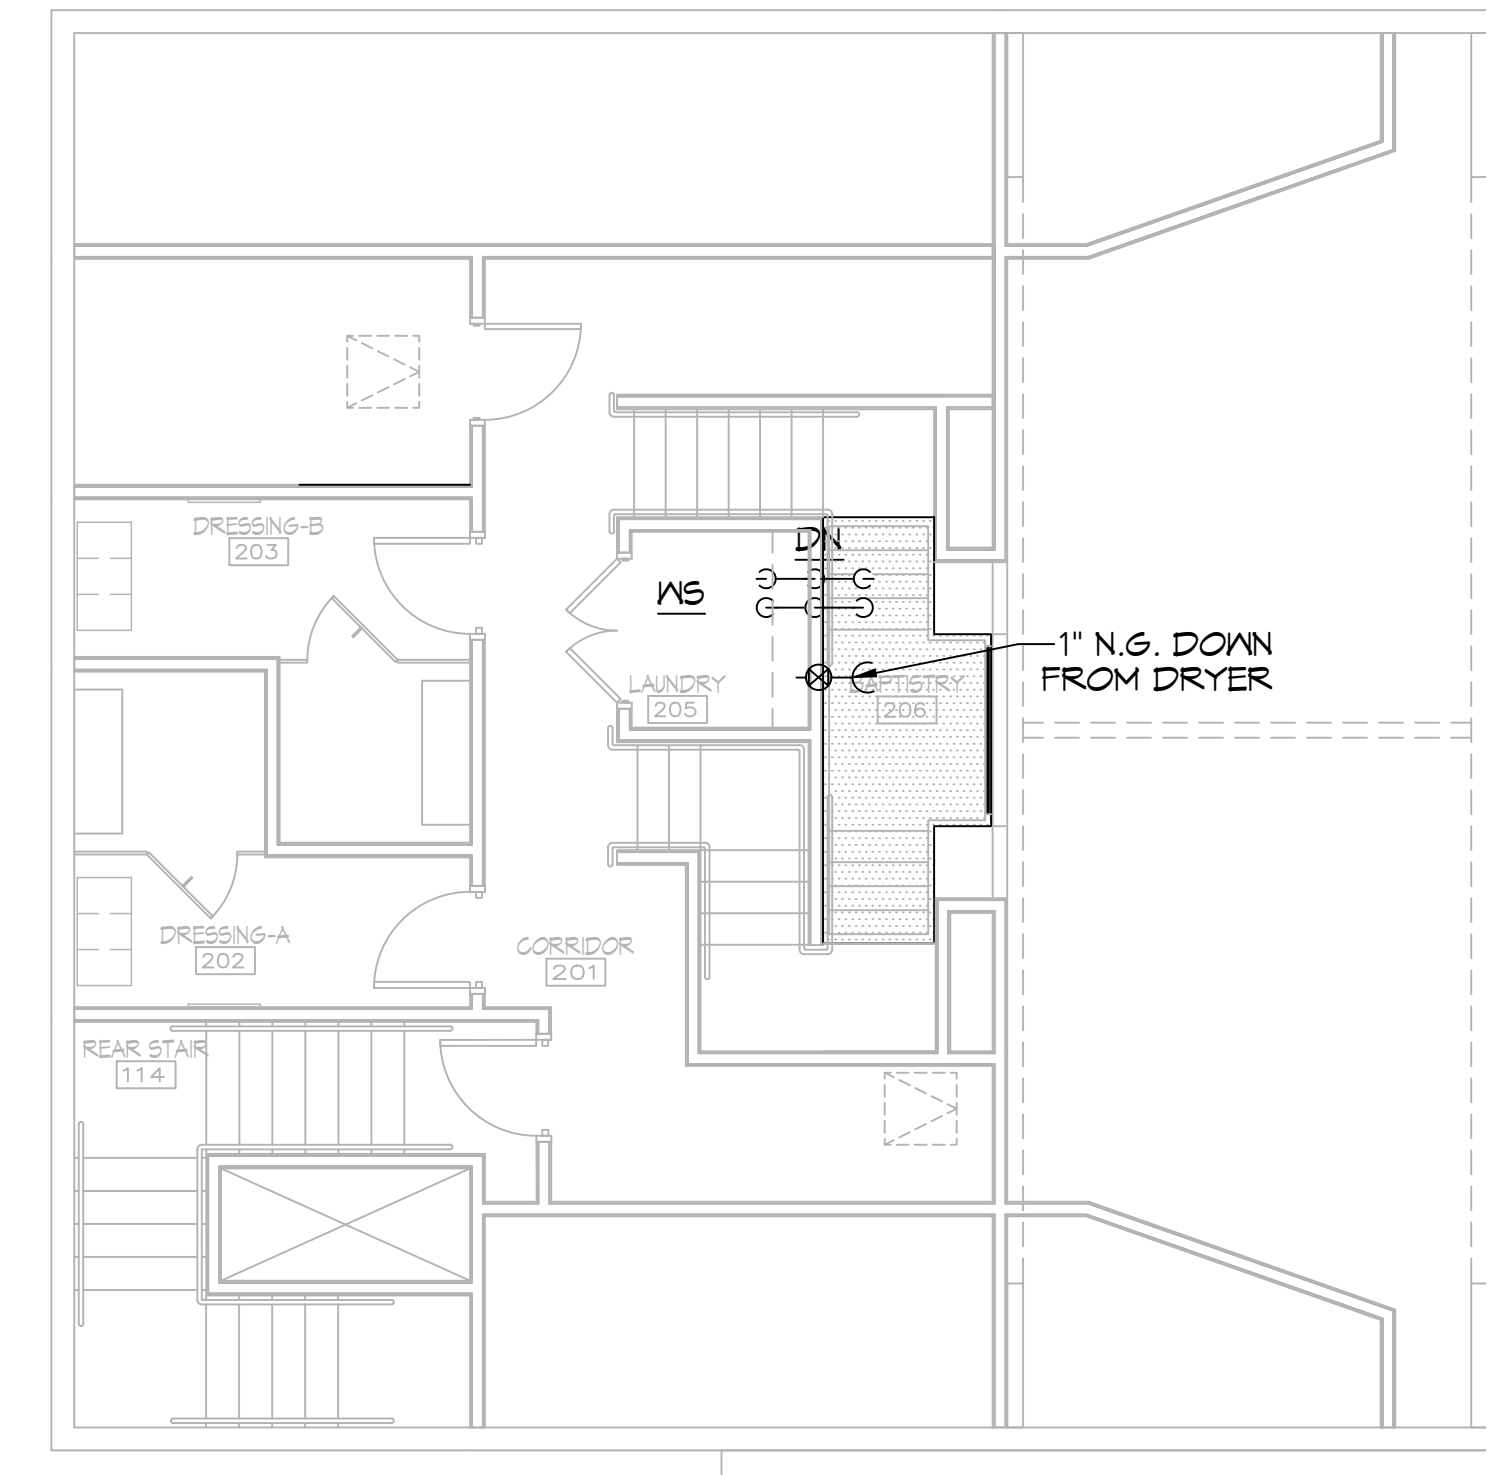

15 POTABLE WATER PLUMBING PLAN
SCALE: 3/16"=1'-0"
SECOND FLOOR

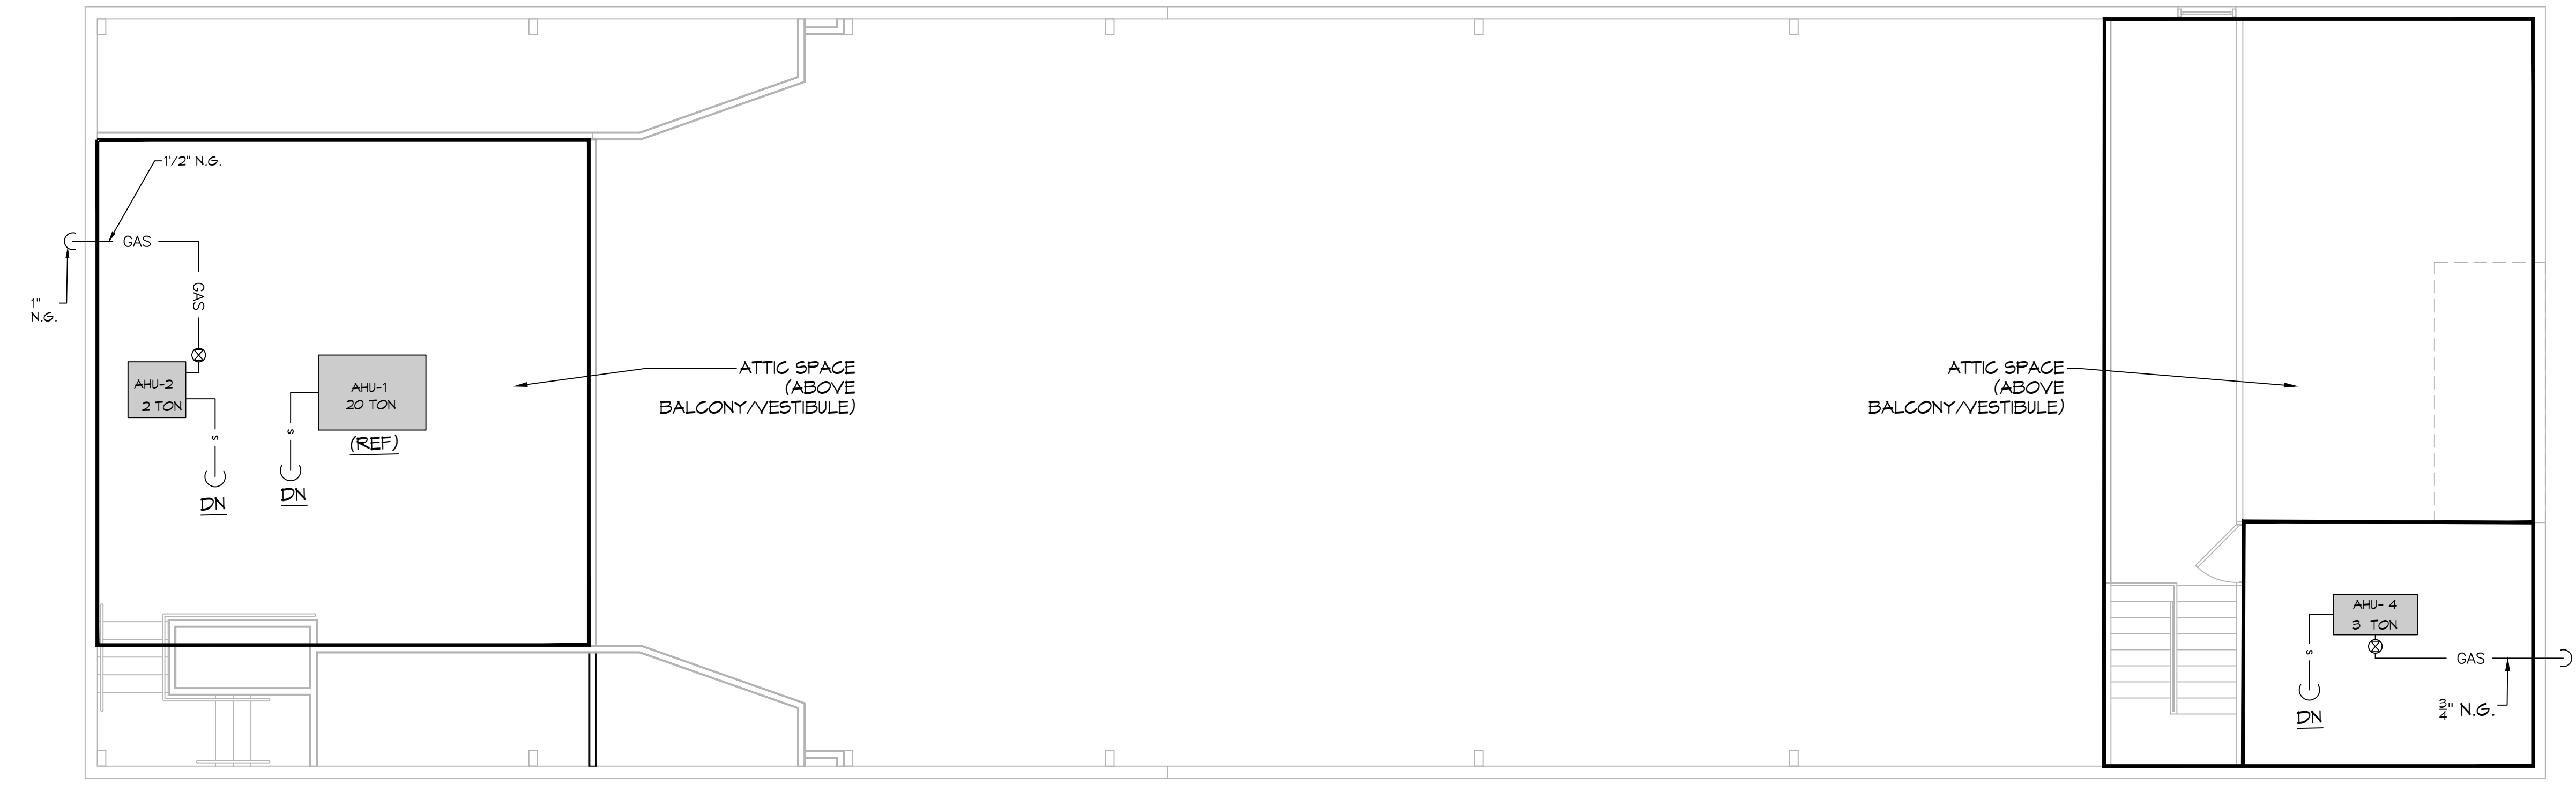


16 SEWER & GAS PLUMBING PLAN
SCALE: 3/16"=1'-0"
ATTIC

DAMMON
ENGINEERING, INC.
LOUISIANA & MISSISSIPPI

Chief Engineer: Brian Mistich, PE
554 Old Spanish Trail
Slidell, LA 70458
www.dammonengineering.com
info@dammonengineering.com
PH: 985.641.5950

#	DESCRIPTION	DATE

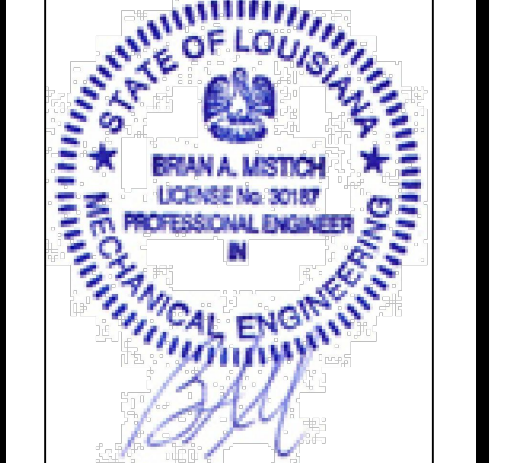

SIXTH FLOOR
 EXPENDITURE
 ESTIMATION
 CONSULTING
 ENGINEERING

JOB No: 2410 DATE: 08-20-2025
 929 FELICITY STREET
 NEW ORLEANS, LA 70130
 DRAWN BY: CHECKED BY:

SHEET TITLE:
SEWER, GAS & POTABLE
WATER PLUMBING PLAN
AND NOTES

DRAWING NUMBER:

P102