


ALL WORK SHALL BE ACCORDING TO THE LATEST EDITIONS OF THE NATIONAL ELECTRICAL CODE (NEC) AND THE NATIONAL FIRE ALARM AND SIGNAL CODE (NFPA 72).

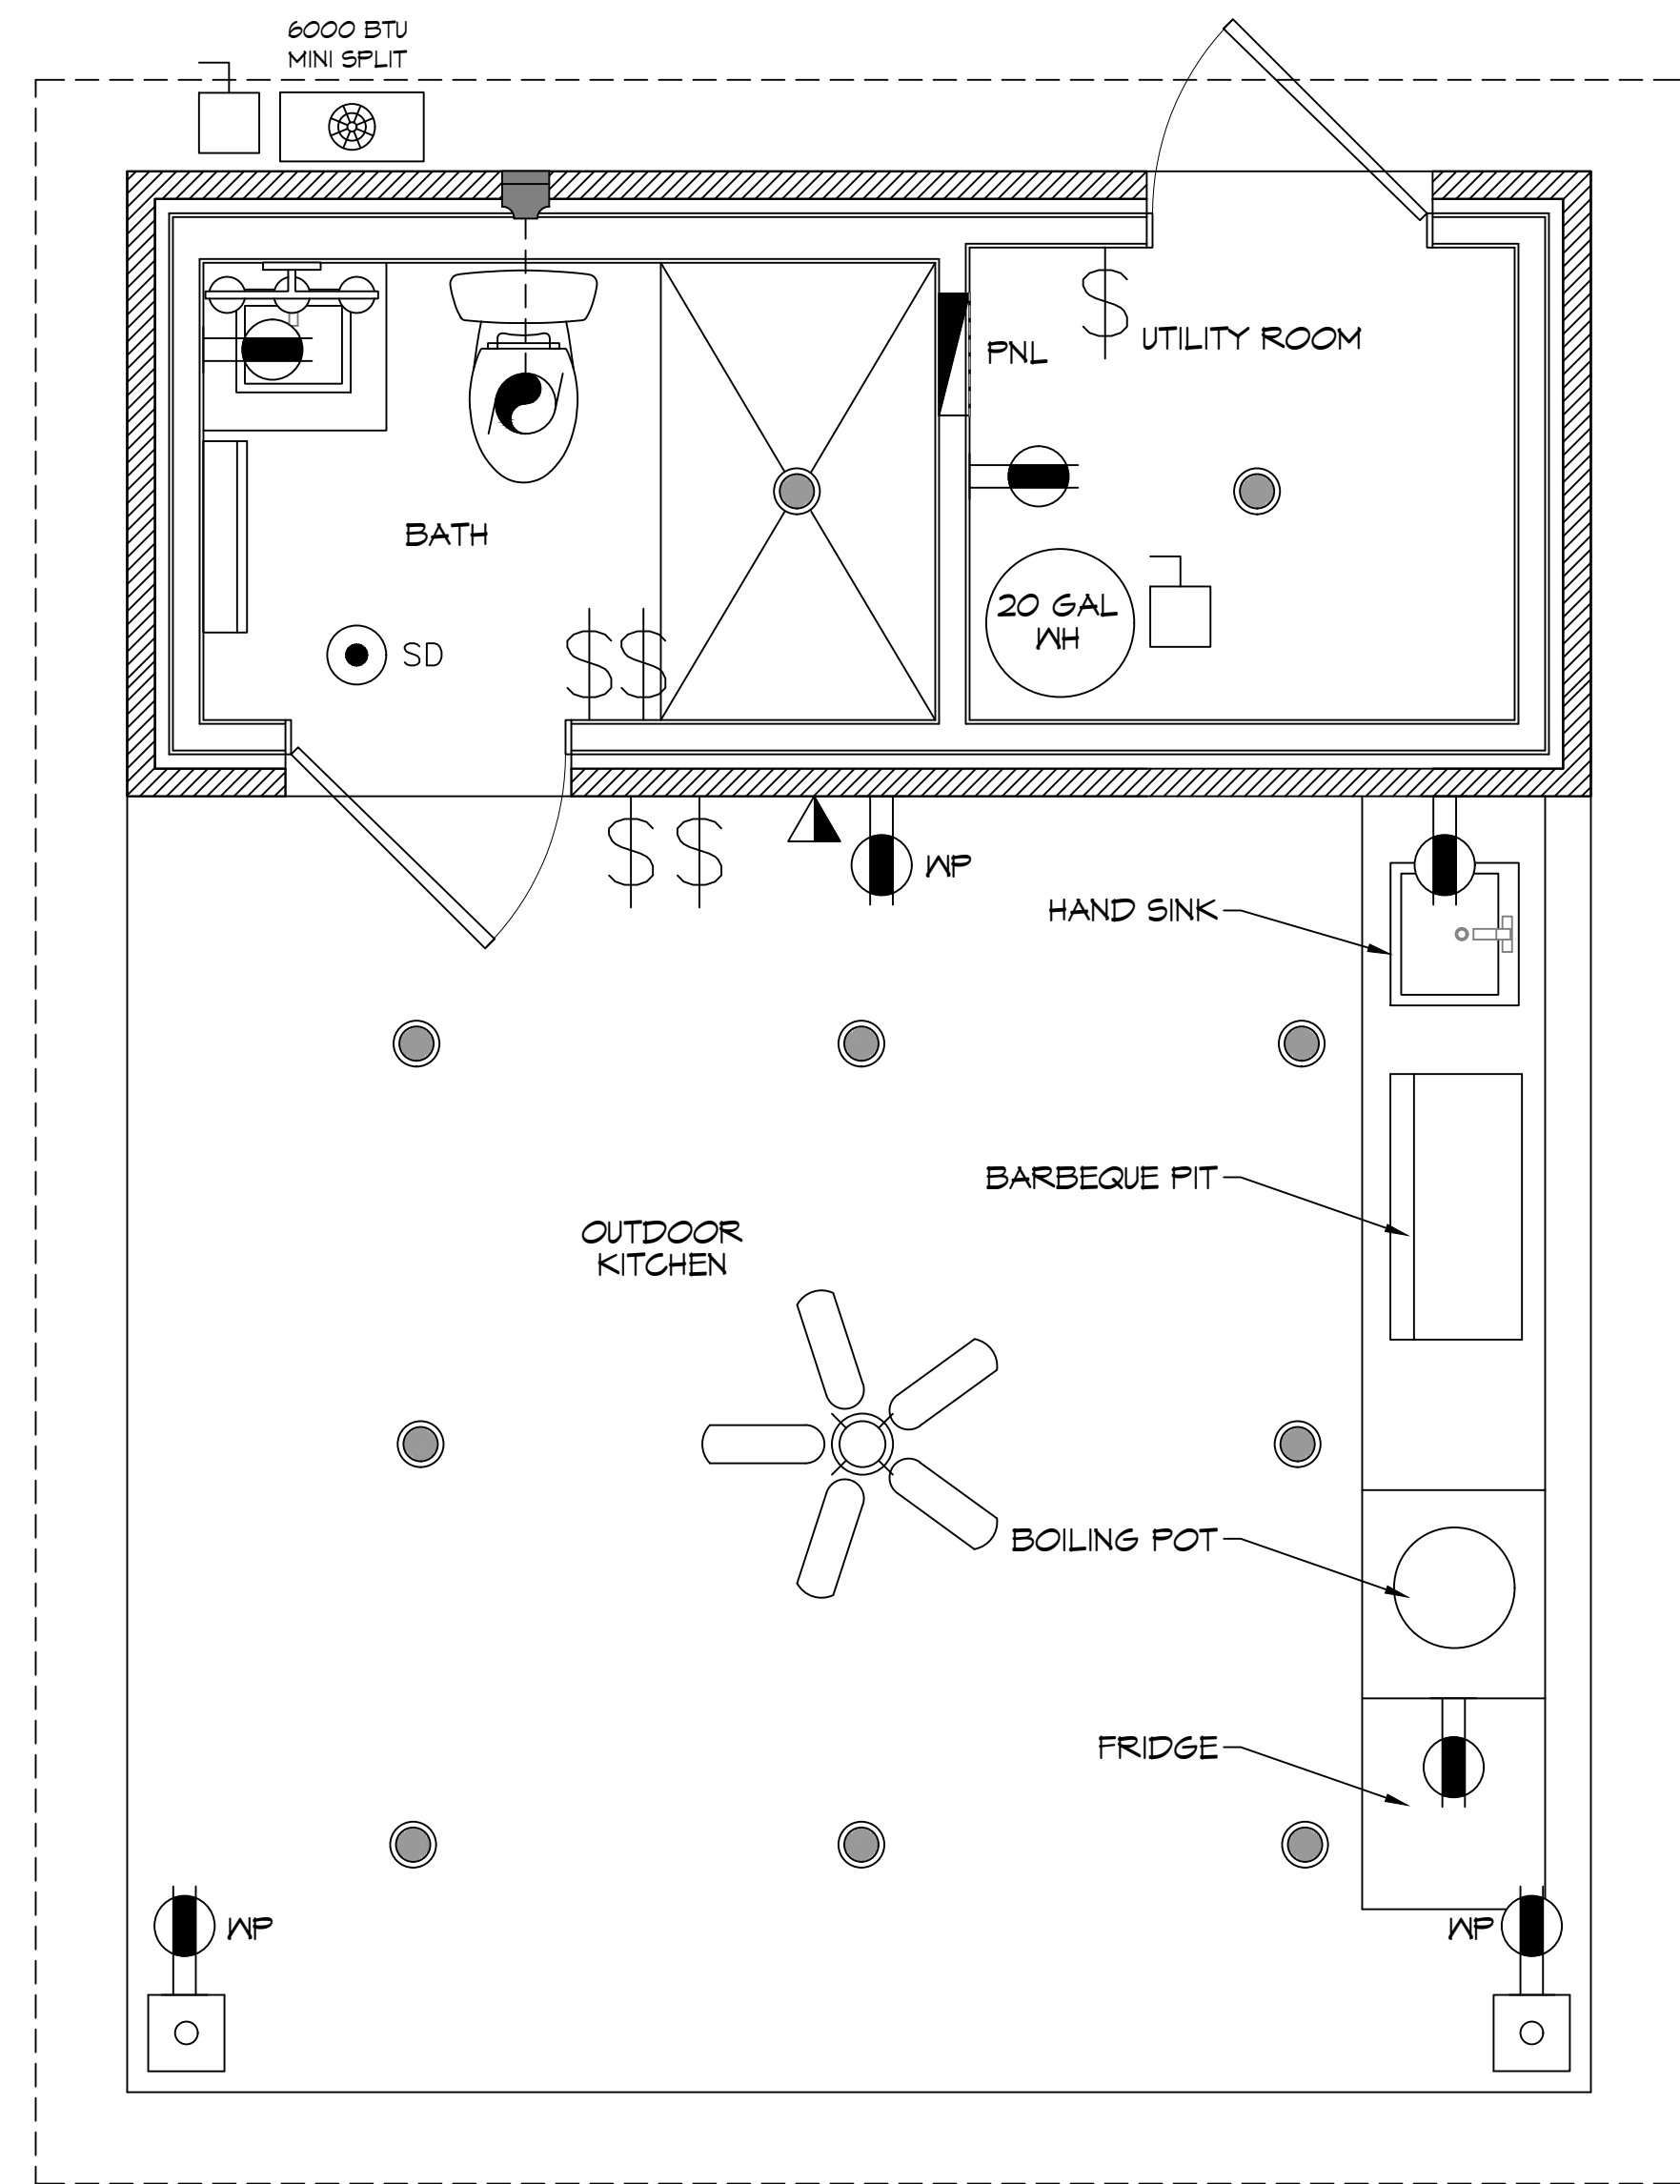

**19 ELECTRICAL PLAN**  
 SCALE: 1/2" = 1'-0"

**GENERAL POWER NOTES**

1. ALL SMOKE DETECTORS TO BE ELECTRIC POWERED WITH BATTERY BACKUP AND WIRED TO SET ALL ALARMS OFF IF ONE IS TRIPPED.
2. ALL EXTERIOR, KITCHEN, AND BATH OUTLETS TO BE GROUND FAULT CIRCUIT INTERRUPT EQUIPPED AND ON A SEPARATE CIRCUIT.
3. ELECTRICAL DISCONNECTS ARE TO BE AT A/C UNIT, CONDENSING UNIT, AND WATER HEATER.
4. HEAT VENT LIGHTS ARE TO BE ON A SEPARATE CIRCUIT.
5. OUTLETS, INCLUDING PHONE AND CABLE, MAY BE ADDED OR CHANGED UPON OWNERS REQUEST.
6. ELECTRICAL CONTRACTOR TO VERIFY EQUIPMENT TYPE AND SIZE.
7. ELECTRICAL SERVICE TO BE A 24 CIRCUIT 125 AMP MAIN LOCATED IN THE STORAGE.
8. ALL KITCHEN OUTLETS ARE TO BE GFI EXCEPT APPLIANCE OUTLETS NOT EASILY ACCESSIBLE.

**LIGHTING LEGEND**

- RECESSED FIXTURE
- BATHROOM FIXTURE
- EXHAUST FAN
- CEILING FAN w/ LIGHT FIXTURE
- SD SMOKE DETECTOR
- ONE WAY SWITCH

**POWER LEGEND**

- DUPLEX RECEPTACLE
- GFI DUPLEX RECEPTACLE
- WEATHER-PROOF GFI DUPLEX RECEPTACLE
- DISCONNECT

**DAMMON ENGINEERING, INC.**  
 LOUISIANA & MISSISSIPPI  
 www.dammonengineering.com  
 info@dammon.com  
 PH: 985.649.5832  
 Chief Engineer: Brian Mitchell, PE  
 554 Old Spanish Trail  
 Slidell, LA 70458

| # | DESCRIPTION | REVISIONS | DATE |
|---|-------------|-----------|------|
|   |             |           |      |
|   |             |           |      |
|   |             |           |      |
|   |             |           |      |

**NEW POOL HOUSE**  
**ELI S T . J U L I E N**  
 57686 MINEGRA ROAD  
 SLIDELL, LA 70460  
 JOB No: 09-05-2025  
 DATE: 09-05-2025  
 DRAWN BY: SCM  
 CHECKED BY: CKD

SHEET TITLE:  
**ELECTRICAL PLAN**  
 DRAWING NUMBER:  
**E101**  
 SHEET No: 5 of 5