



- ABBREVIATIONS**
- CB = CATCH BASIN
 - CMP = CORRUGATED METAL PIPE
 - COR = CENTER OF ROAD
 - EOR = EDGE OF ROAD
 - FM = FORCE MAIN
 - INV = INVERT
 - MH = NEW SANITARY SEWER MANHOLE
 - RCP = ROUND CORRUGATED PIPE
 - RCPA = ROUND CORRUGATED PIPE-ARCH
 - ROW = RIGHT OF WAY
 - SN = SWALE

- LEGEND**
- FM 6" FORCE MAIN
 - SS GRAVITY FED SEWER
 - POWER POLE
 - SANITARY SEWER MANHOLE
 - X EXISTING ELEVATION
 - STATION #
 - ELEVATION
- STA=0+00
EL=101.1'

DAMMON ENGINEERING, INC.
 LOUISIANA & MISSISSIPPI
 Chief Engineer: Brian Mistich, PE
 554 Old Spanish Trail
 Slidell, LA 70458
 www.dammonengineering.com
 info@dammonengineering.com
 PH: 985.649.5832

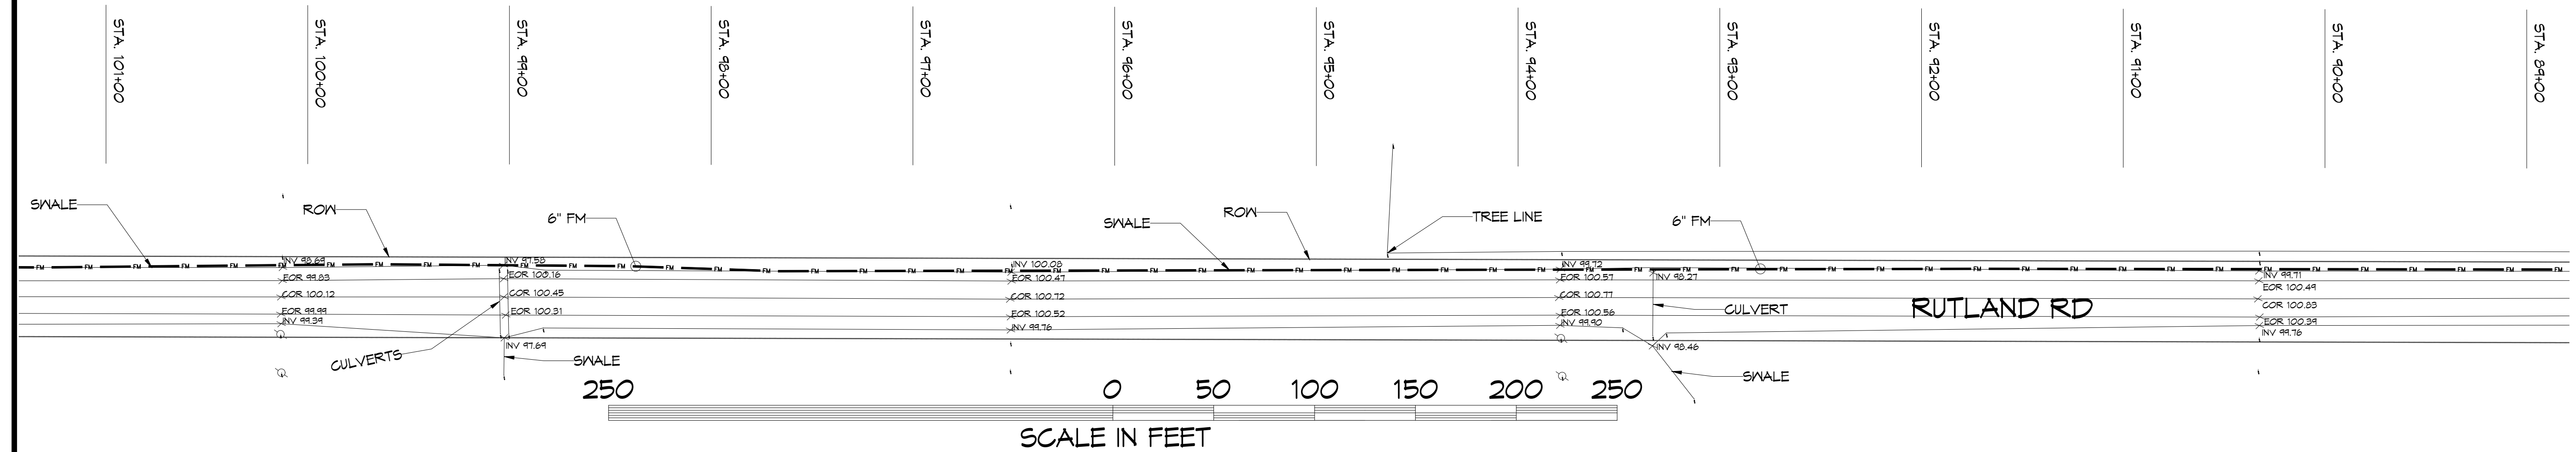


10 FORCE MAIN PARTIAL SITE PLAN
 1" = 40'

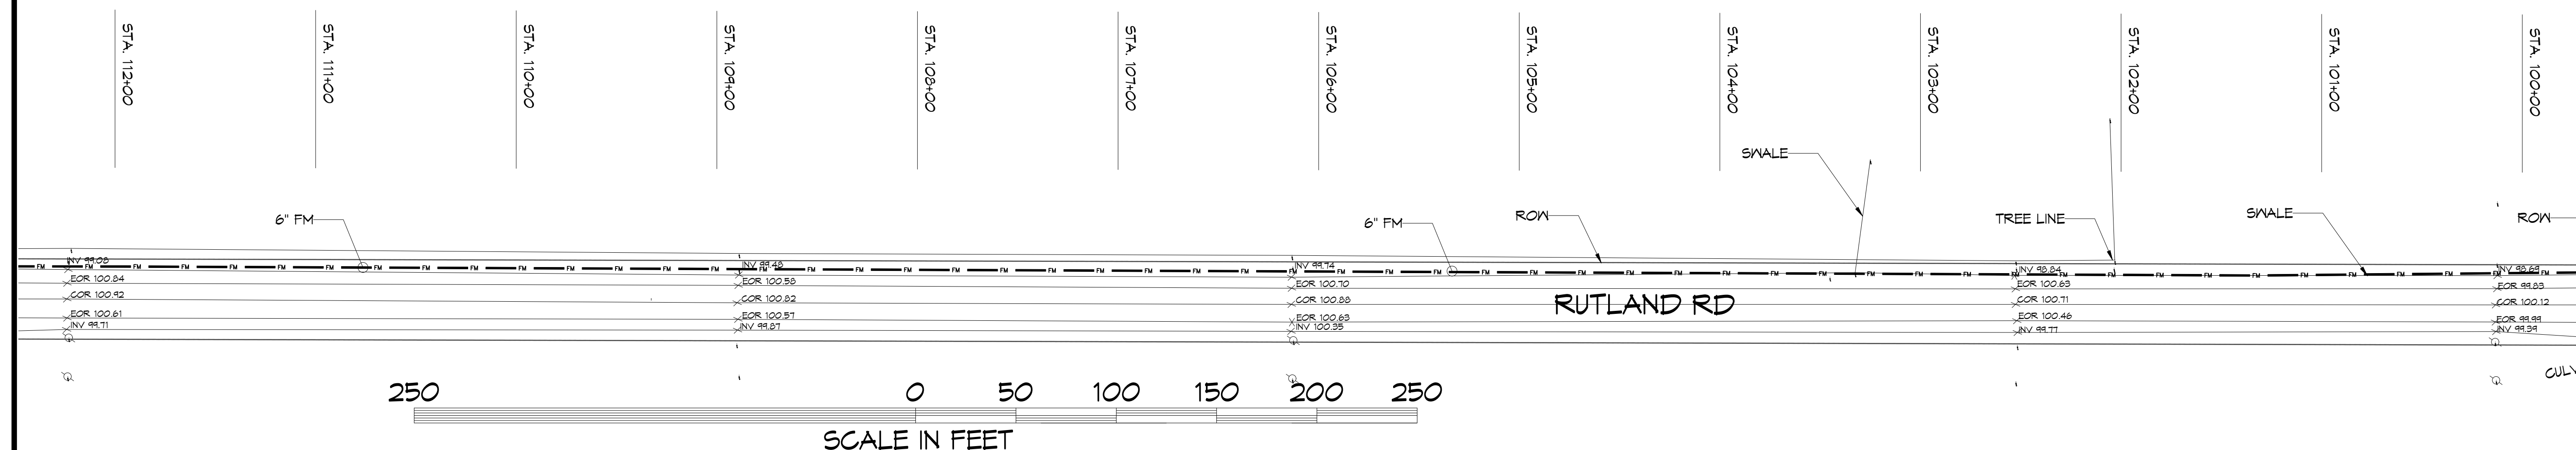

11 FORCE MAIN PARTIAL SITE PLAN
 1" = 40'

REVISIONS	DATE

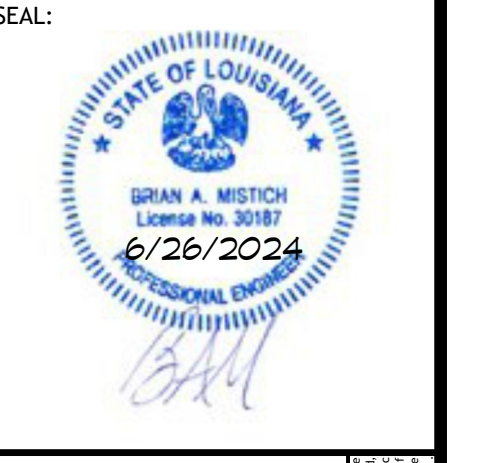

NEW FORCE MAIN
 TANGIPAHOA PARISH LANDFILL
 AMITE CITY, LA
 JOB No: 2400 DATE: 5-5-2024
 DRAWN BY: DDP CHECKED BY: BMY

SHEET TITLE:
 FORCE MAIN HWY 16

DRAWING NUMBER:
M101F
 SHEET No: 3 of 7