




FILE NAME: A:\Projects\2024\24-000001\24-000001.dwg - Date: 06/26/2024 - User: M102 - Plot Date: 06/26/2024 - Plot Time: 10:00:00 AM - Plot Scale: 1:1 - Plot Sheet: 1 of 1

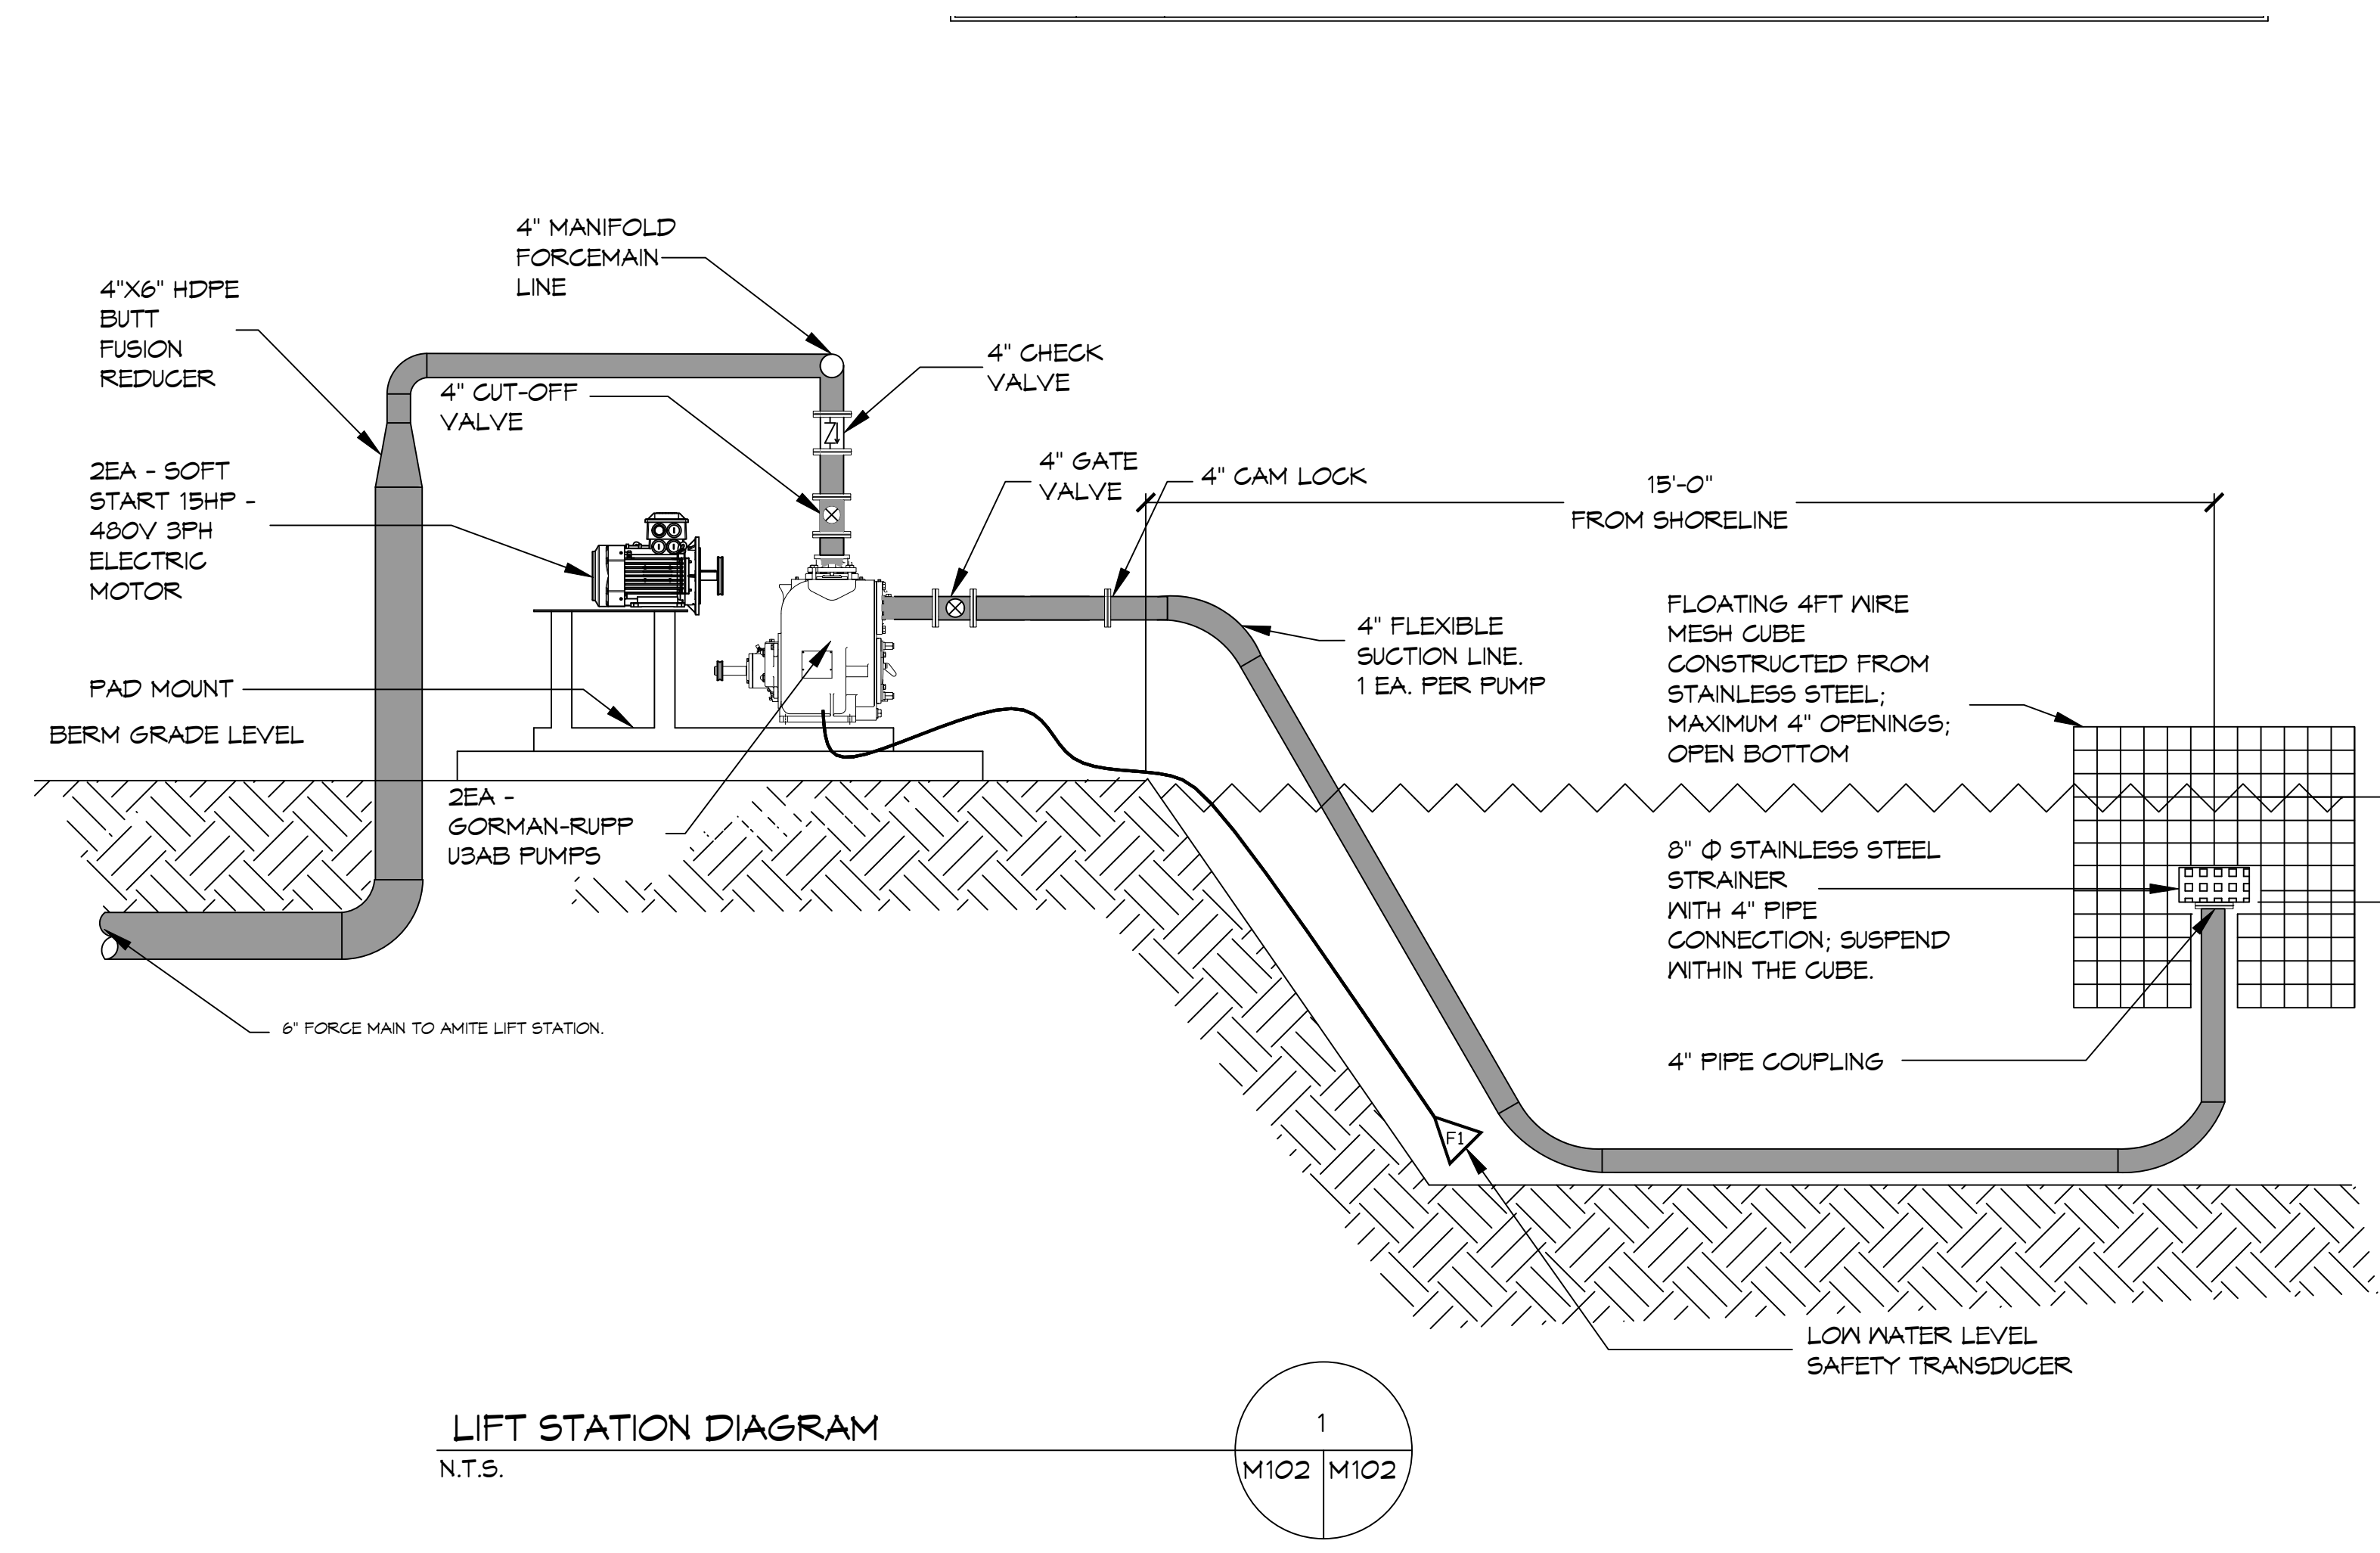



LIFT STATION DIAGRAM  
N.T.S.

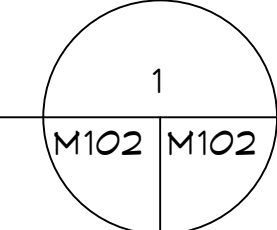

NOTE: NAMING A CERTAIN BRAND, MAKE OR MANUFACTURER IS TO DESIGNATE THE GENERAL STYLE, TYPE, CHARACTER AND QUALITY STANDARD OF THE PRODUCT DESIRED. SUBSTITUTION REQUESTS MUST BE SUBMITTED PRIOR TO BIDDING.

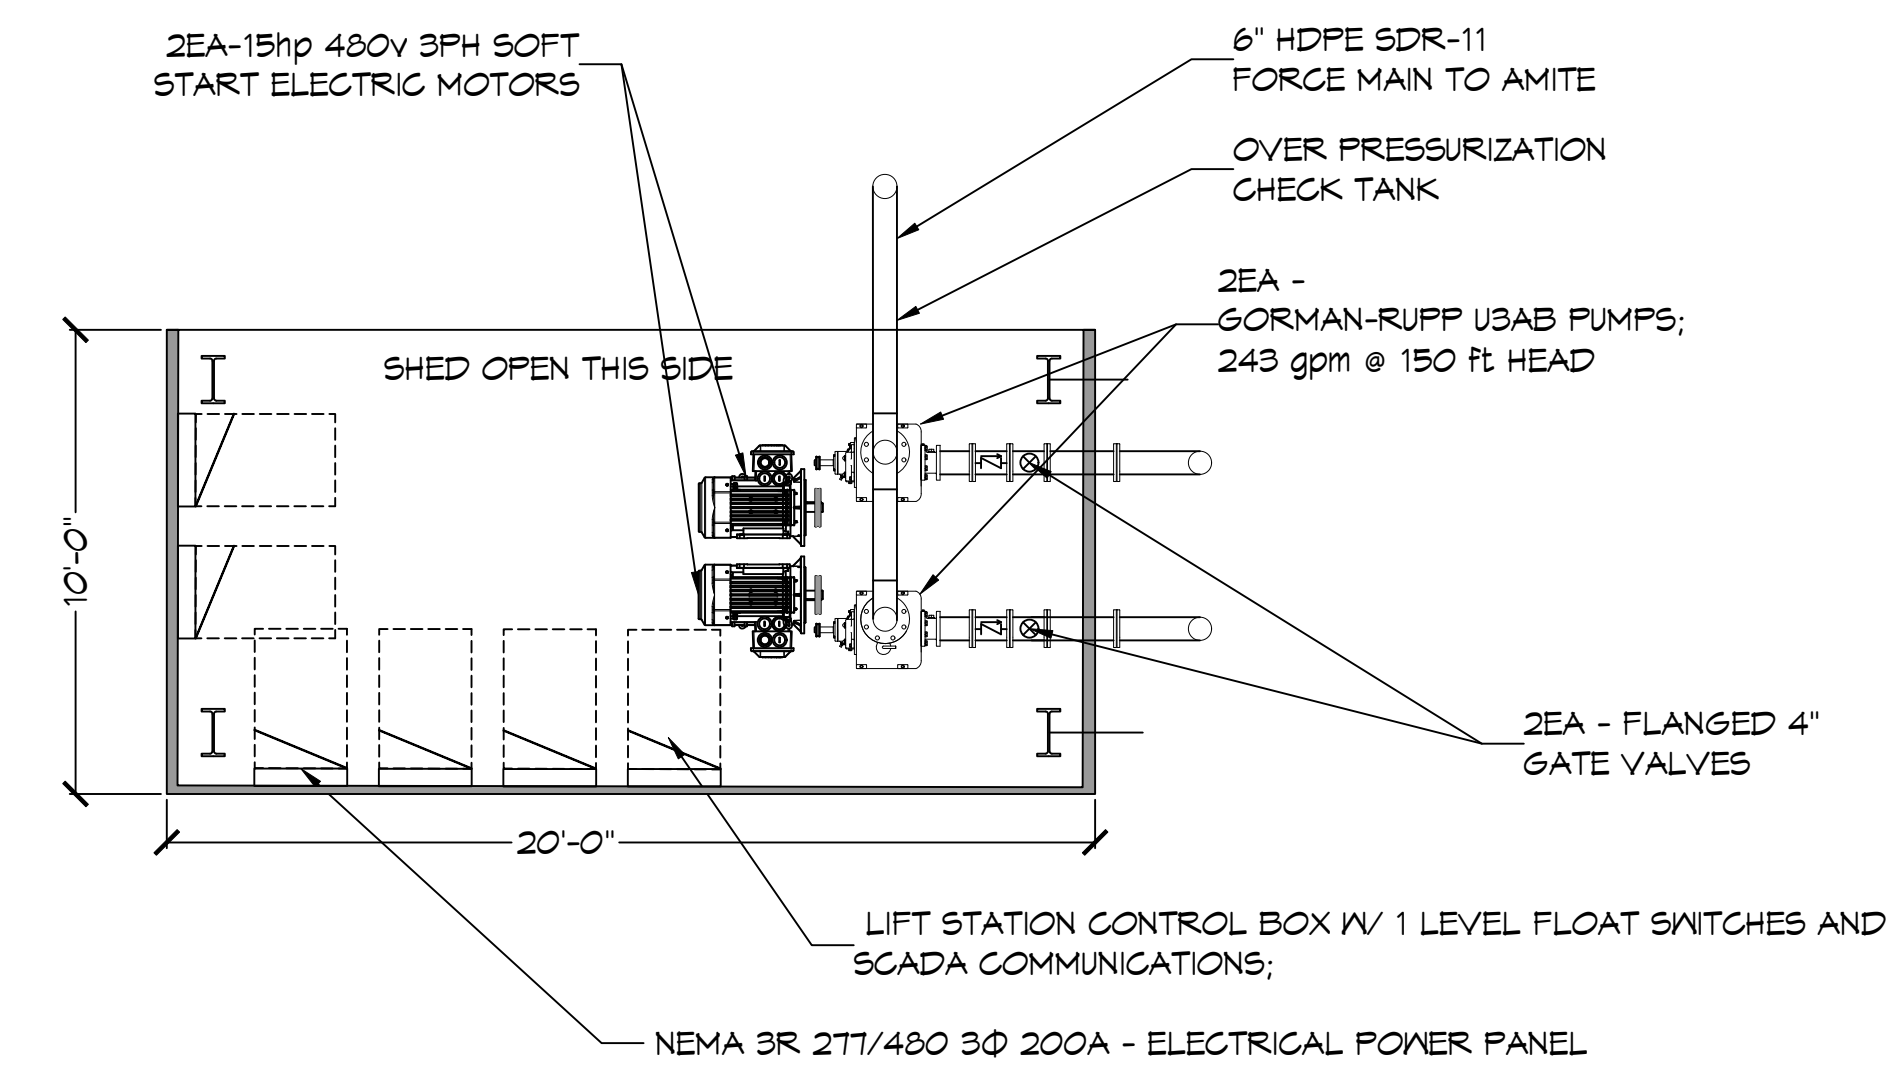


SHED LAYOUT  
N.T.S.

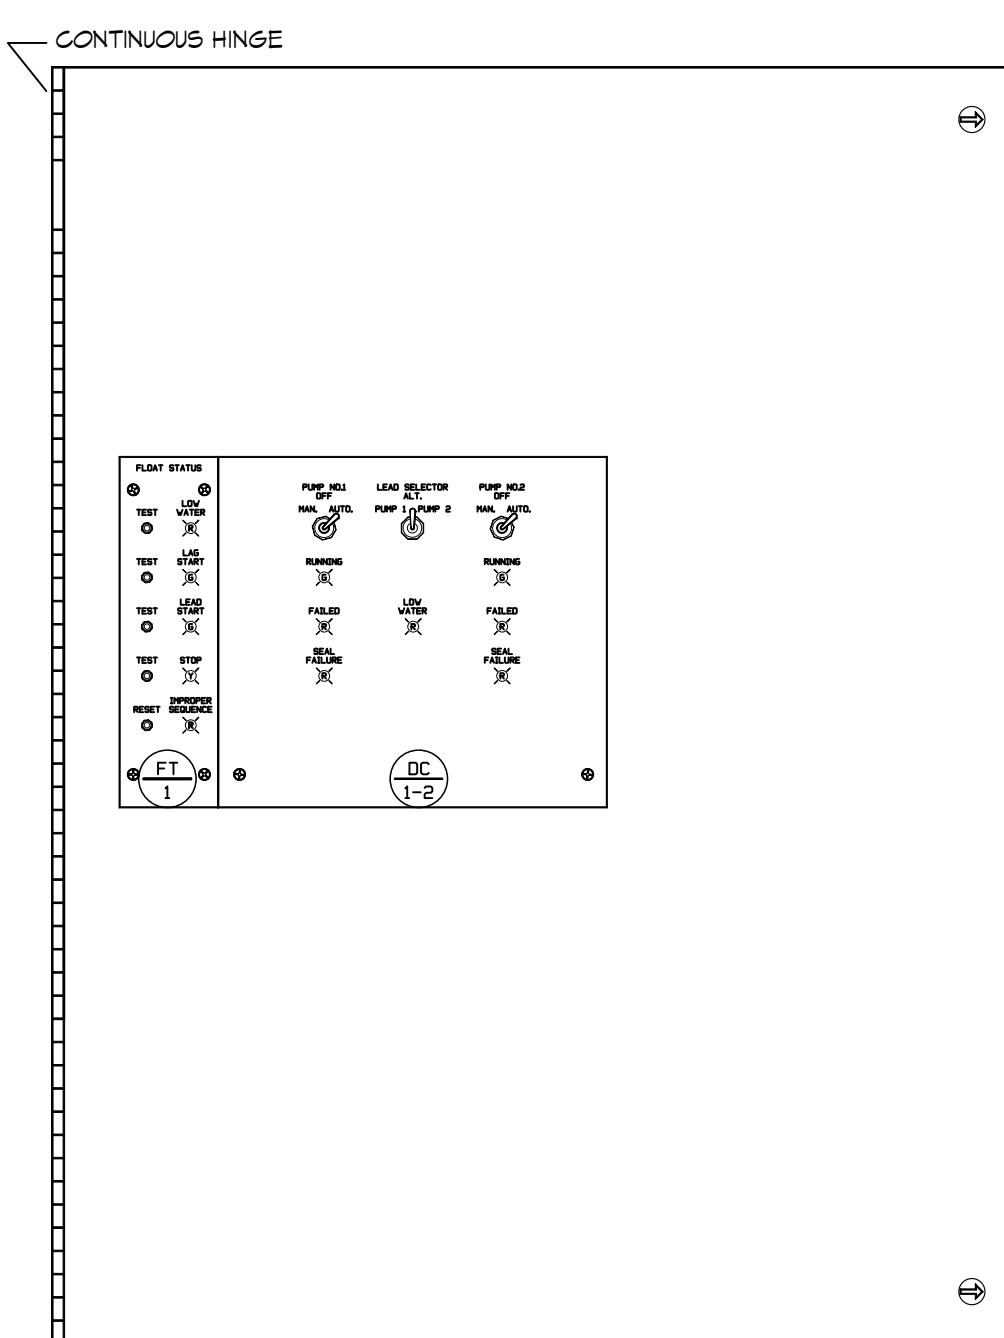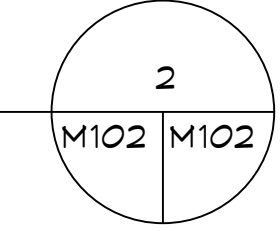


CONTROL PANEL  
DEADFRONT DETAIL

- LEGEND
- LIGHTNING ARRESTOR - SEE COMPONENT SPECIFICATIONS
  - PHASE MONITOR - SEE COMPONENT SPECIFICATIONS
  - DUPLEX CONTROLLER - SEE COMPONENT SPECIFICATIONS
  - FLOAT TEST - SEE COMPONENT SPECIFICATIONS
  - ALARM LIGHT - SEE COMPONENT SPECIFICATIONS
  - POWER LIGHT - SEE COMPONENT SPECIFICATIONS

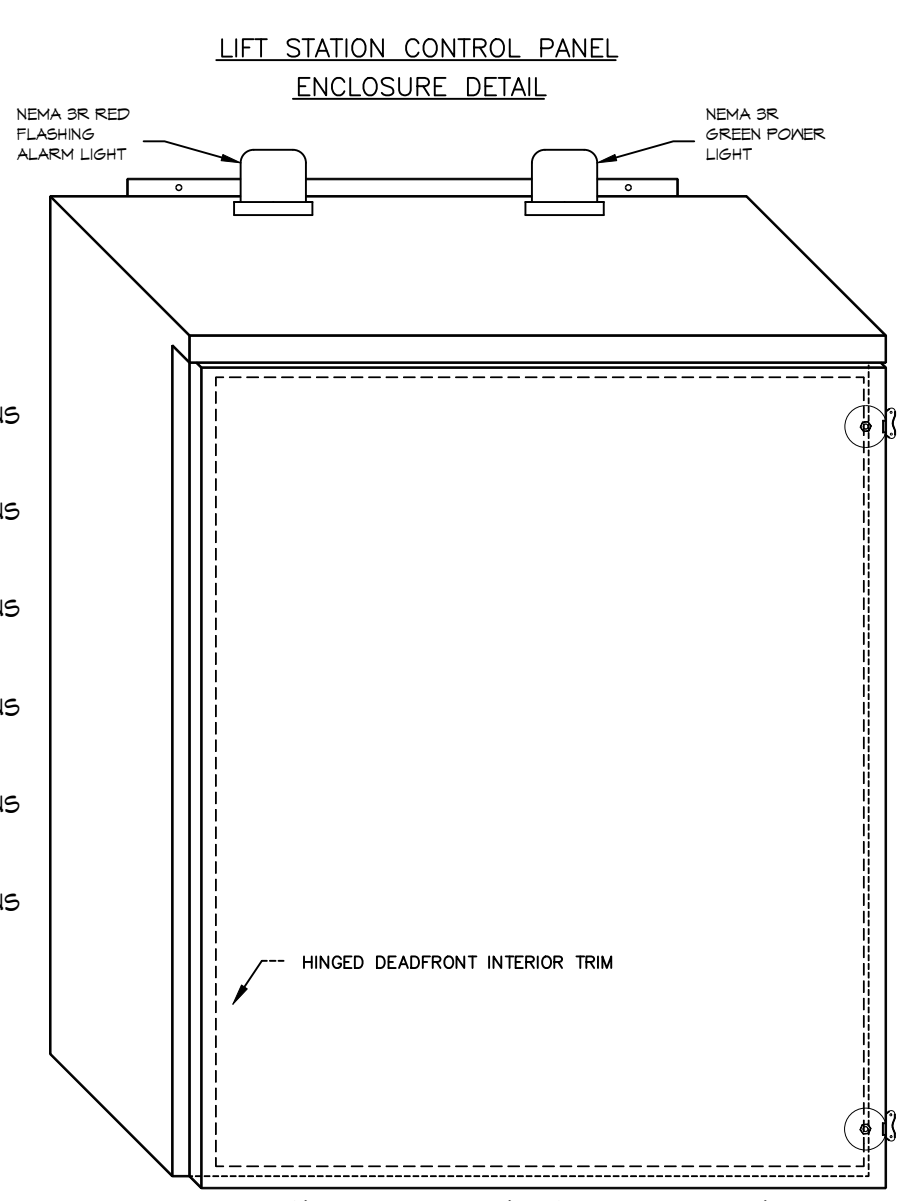

NEMA 3R ENCLOSURE  
(24"H x 24"W x 8"D)  
OR OTHER APPROVED PRE-DESIGNED  
MANUFACTURE ENCLOSURE

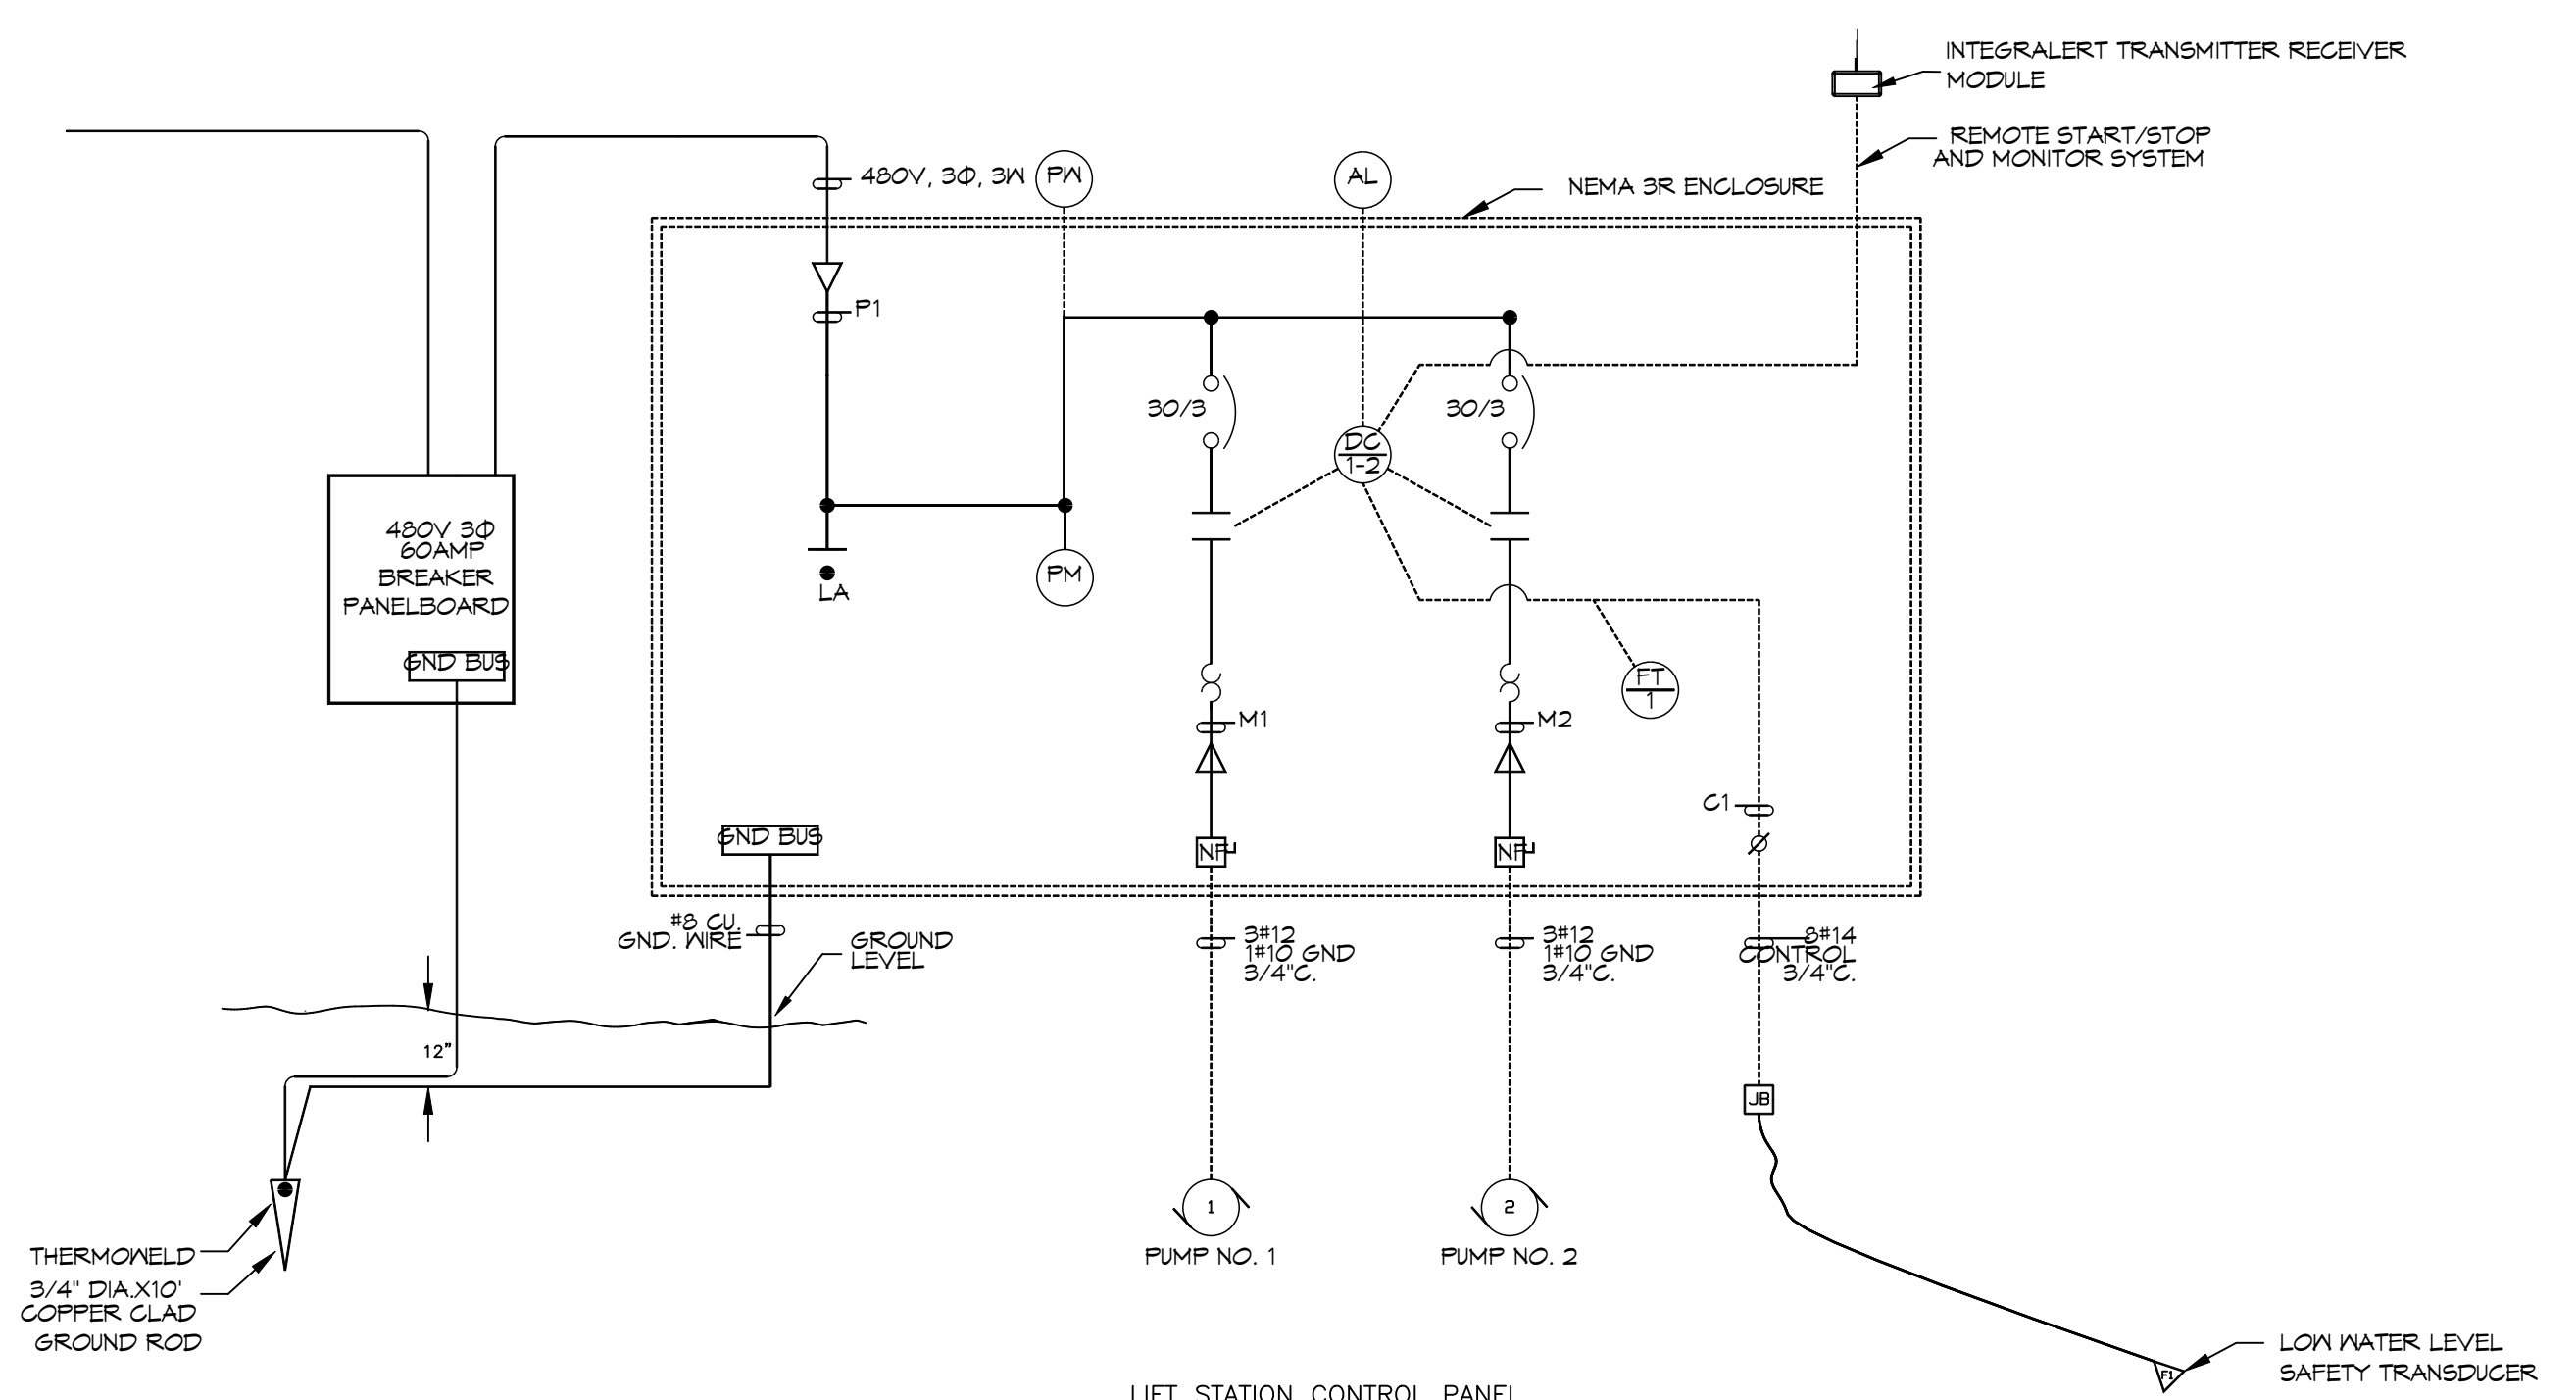

LIFT STATION CONTROL PANEL  
ONE LINE POWER DIAGRAM AND  
PROCESS AND INSTRUMENTATION DIAGRAM (P&ID)

**DAMMON ENGINEERING, INC.**  
 LOUISIANA & MISSISSIPPI  
 Chief Engineer: Brian W. Mitchell, PE  
 554 Old Spanish Trail  
 Slidell, LA 70458  
 www.dammonengineering.com  
 info@dammonengineering.com  
 PH: 985.649.5832

#	DESCRIPTION	DATE



NEW FORCEMAIN  
**TANGIFALHOA PARISH LANDFILL**  
 AMITE CITY, LA  
 JOB No: 24-000001  
 DATE: 6/26/2024  
 DRAWN BY: PPD  
 CHECKED BY: BV

SHEET TITLE:  
LIFT STATION DETAILS @  
OXIDATION POND

DRAWING NUMBER:  
**M102**  
SHEET No: 4 of 7