


FILE NAME: C:\Users\dammon\OneDrive\Documents\Projects\C101 - Fire Station #10.dwg, PLOT DATE: 06/11/2025, 12:53:09 PM

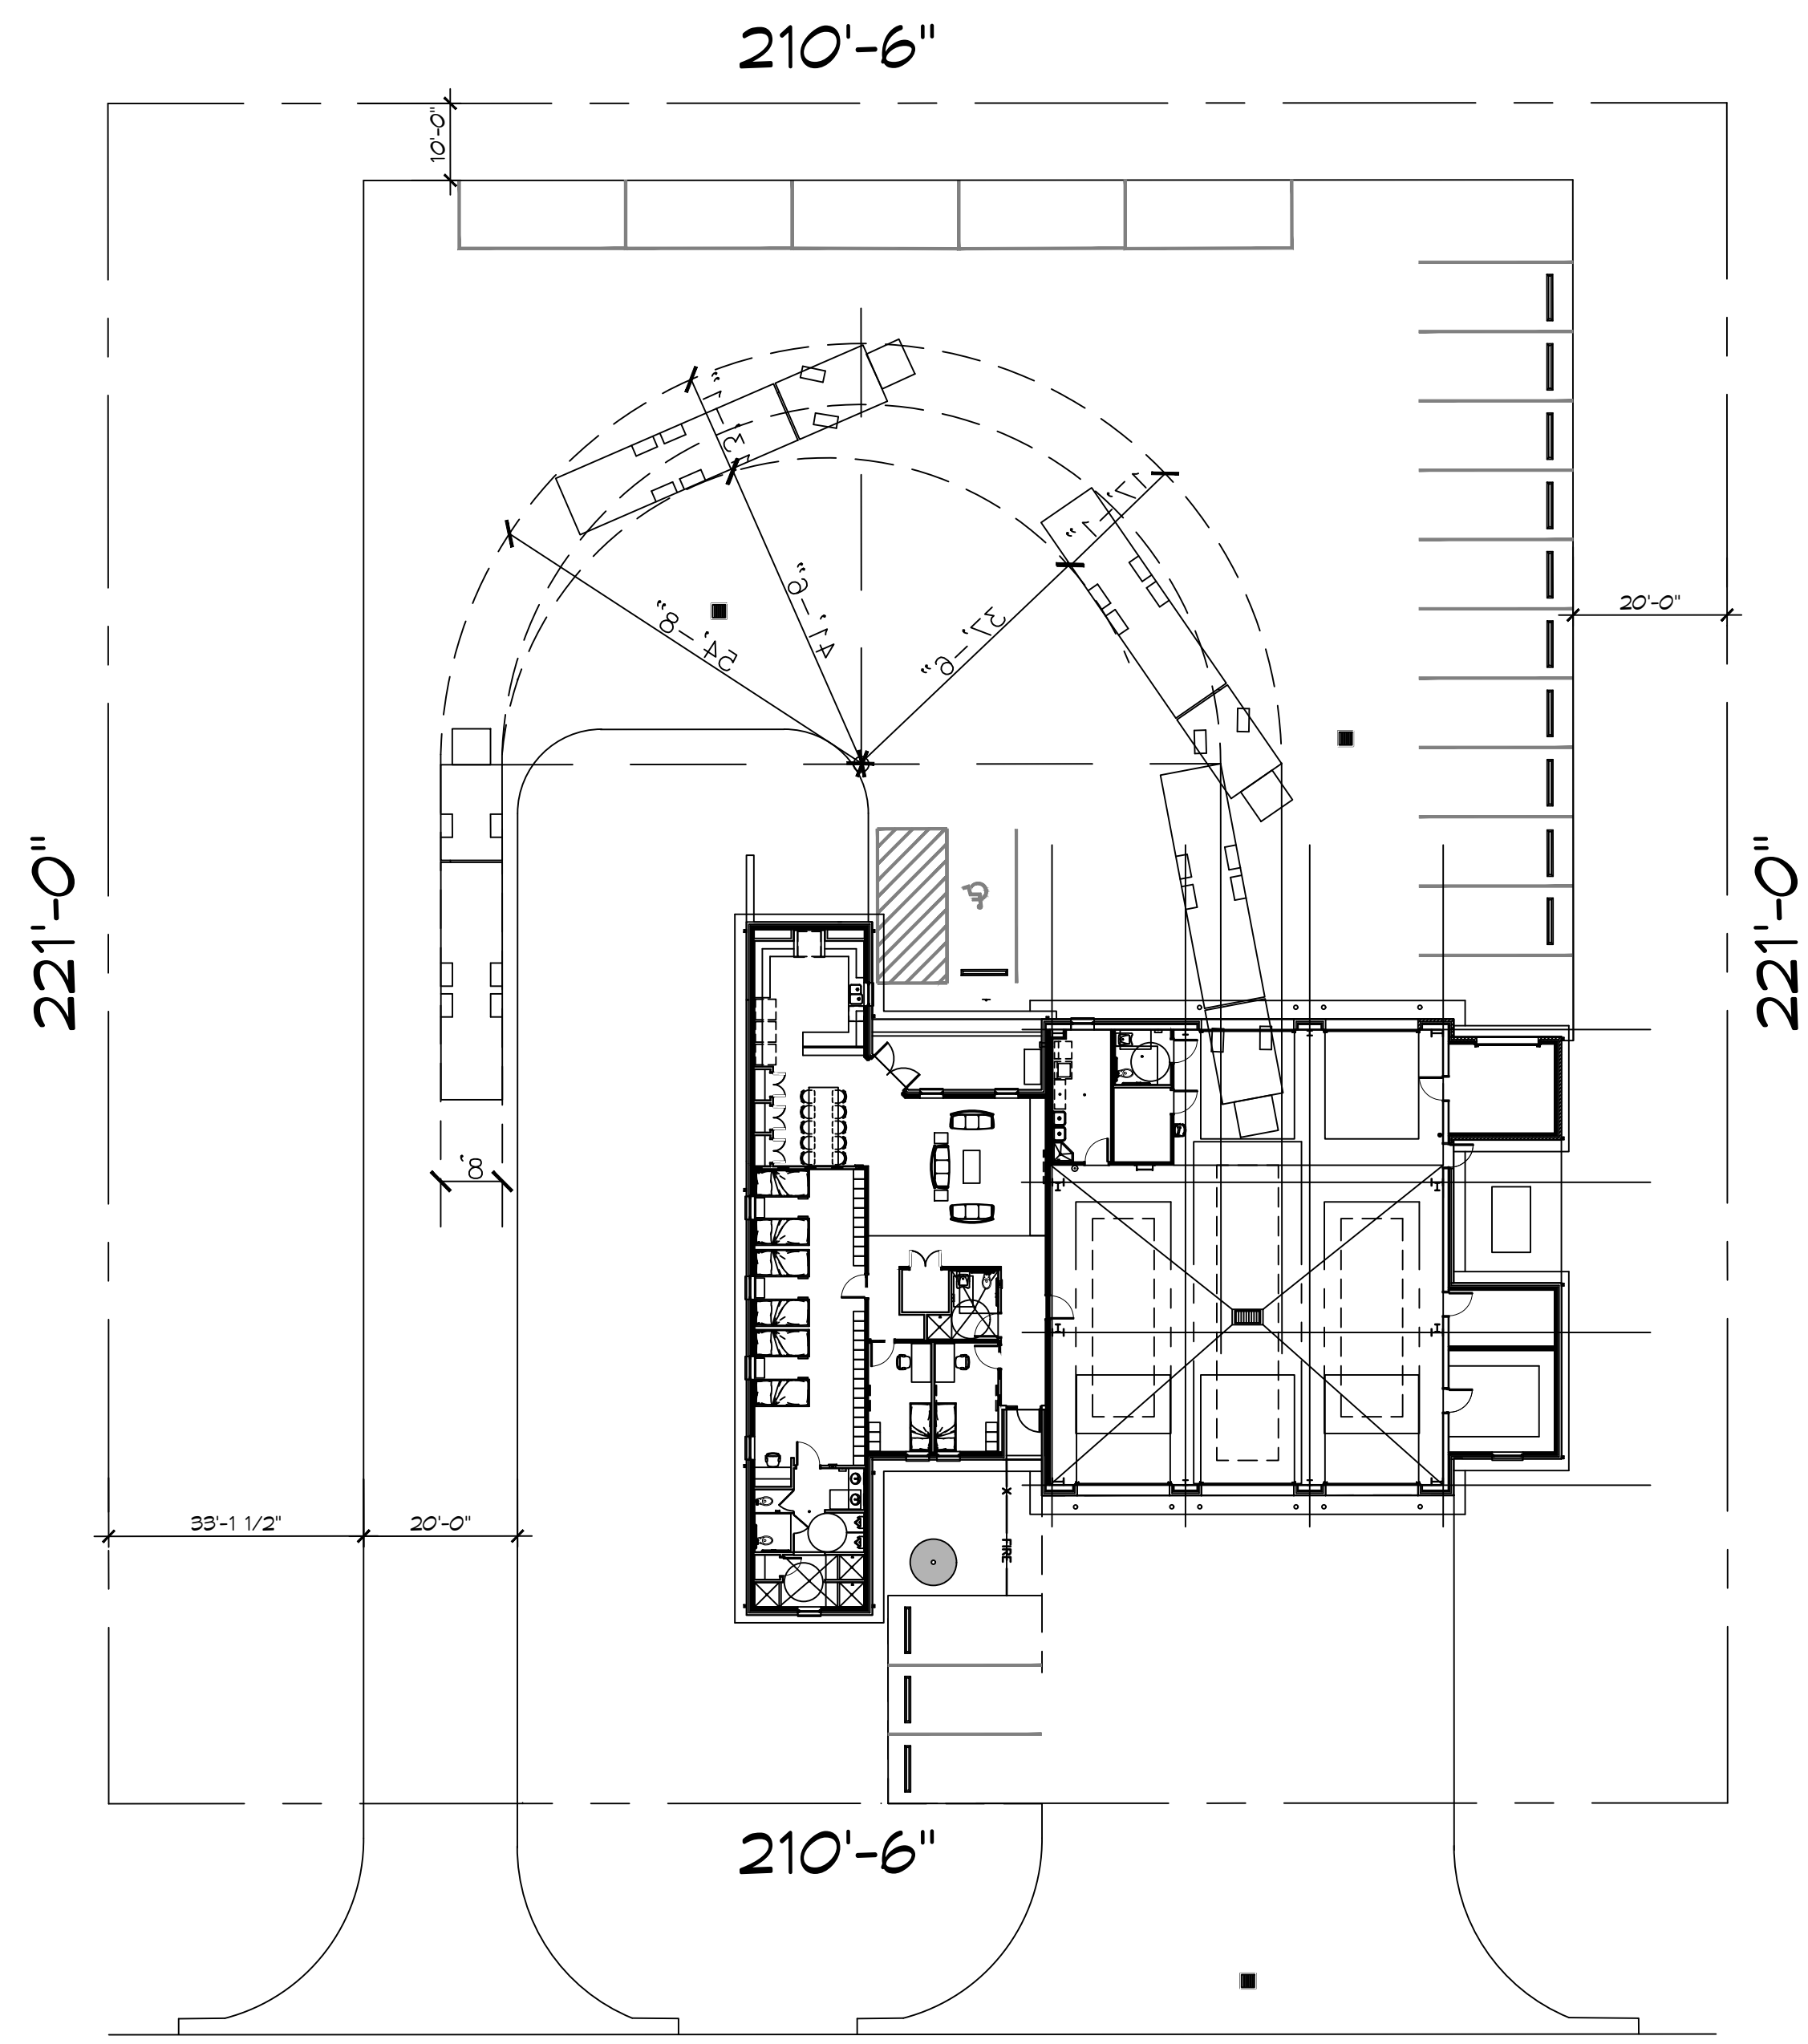

LAKESHORE VISTA BLVD

1 PROPOSED SITE PLAN

SCALE: 1"=20'

DAMMON
ENGINEERING, INC.
LOUISIANA & MISSISSIPPI

Chief Engineer: Brian Mistich, PE
554 Old Spanish Trail
Sibley, LA 70488
www.dammonengineering.com
info@dammonengineering.com
PH: 985.649.5832

#	DESCRIPTION	REVISIONS	DATE

SEAL:

NEW FIRE STATION #10
ST. TAMMANY FIRE PROTECTION
DISTRICT NO. 1

LAKESHORE VISTA BLVD
SIBLEY, LA 70488

JOB No: ???? DATE: 06-11-2025
DRAWN BY: CKD CHECKED BY: CKD

SHEET TITLE:
PROPOSED SITE PLAN

DRAWING NUMBER:
C101