


FILE NAME: A:\1 - School Plans\New Job Plan - Stiles Auditorium\Current Drawings\A101 - 1st Floor.dwg, PLOT DATE: 8/26/2024, PLOT TIME: 10:22:04 AM

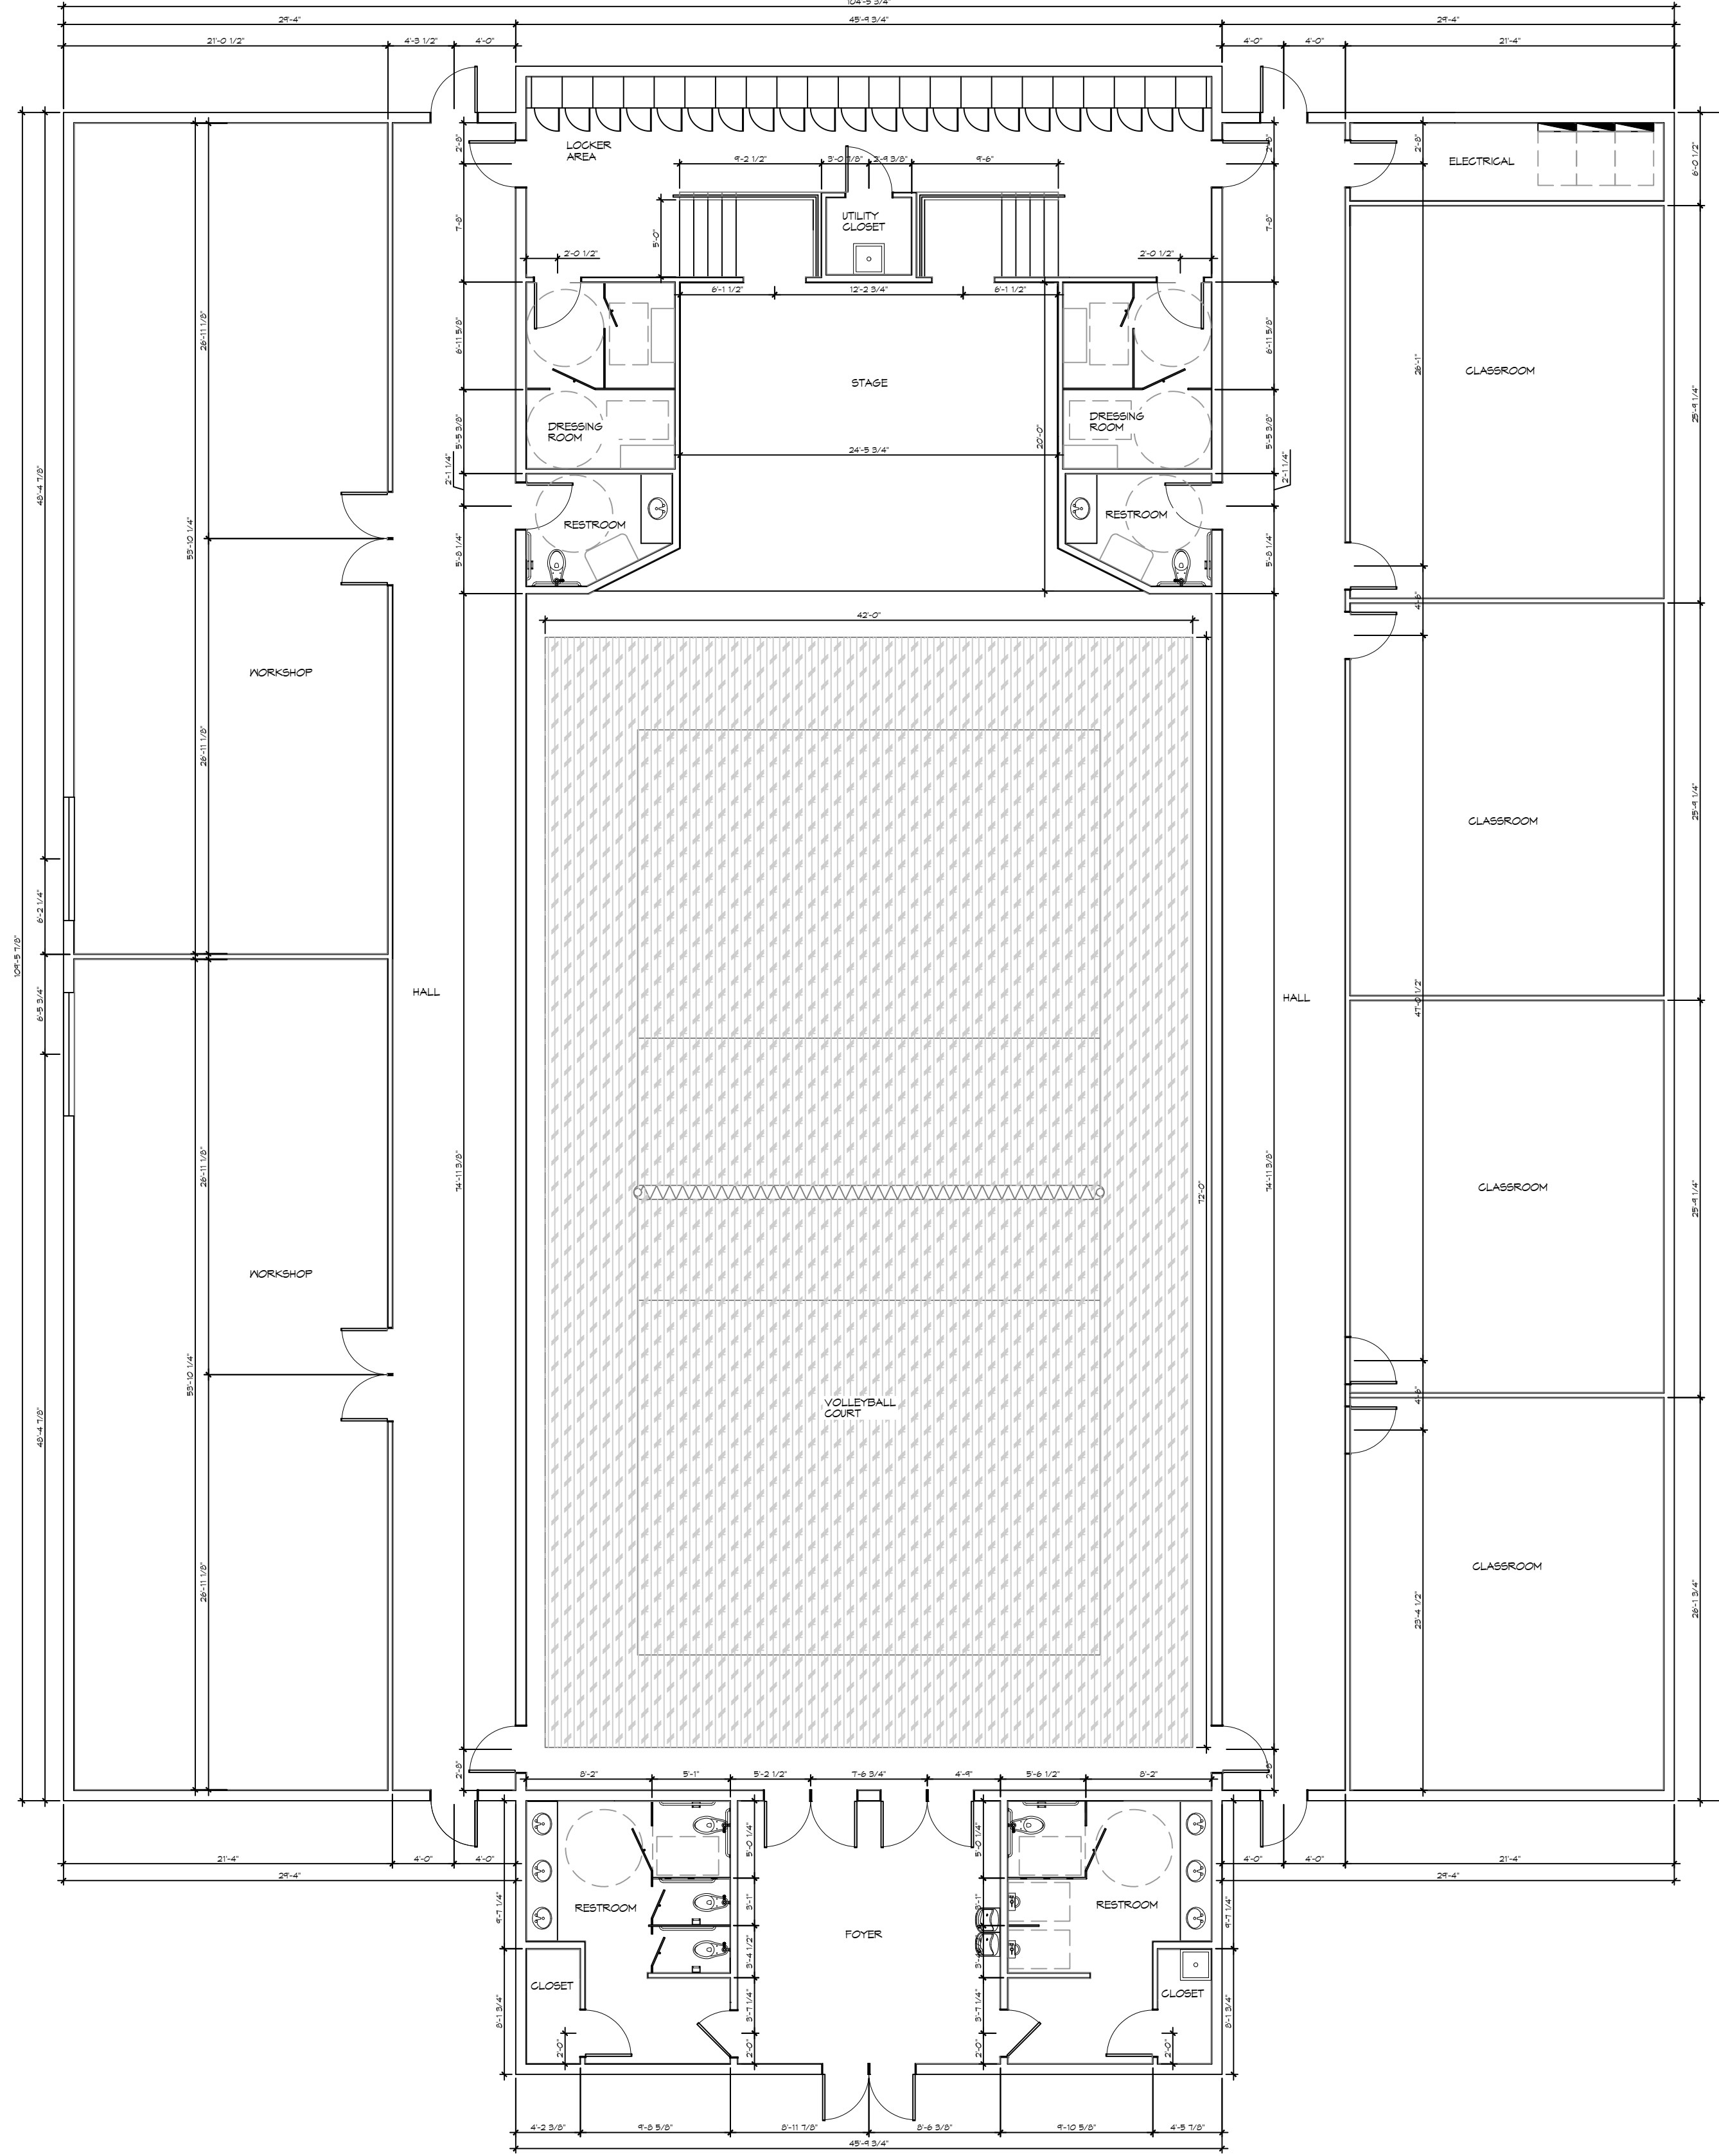

1 FLOOR PLAN
 SCALE: 1/8"=1'-0"

DAMMON
ENGINEERING, INC.
 LOUISIANA & MISSISSIPPI

Chief Engineer: Brian Mistich, PE
 554 Old Spanish Trail
 Slidell, LA 70458
 www.dammonengineering.com
 info@dammonengineering.com
 PH: 985.649.5832 F: 985.641.5950

#	DESCRIPTION	REVISIONS	DATE

PAUL
 JOHN
 JORJUM
 POPP

5770 LEGGETT ROAD
 SLIDELL, LA 70460
 JOB No: 2245 DATE: 10-22-2024
 DRAWN BY: CKD CHECKED BY: JMS

SHEET TITLE:
FLOOR PLAN

DRAWING NUMBER:
A101

SHEET No: 1 of 1