

DAMMON ENGINEERING, INC.

EMMETT DAMMON

ARCHITECT ROBERT WILTSE

1095 FLORIDA AVENUE
SLIDELL, LA. 70458
985-649-5832

WEBSITE:
WWW.DAMMONENGINEERING.COM

EMAIL:
DAMMONENG@BELLSOUTH.NET

ARCHITECTURE

ENGINEERING

STUDIES

PLANNING

INVESTIGATION

EXPERT WITNESS

GENERATOR INSTALLATION

N.O. PRIVATE PATROL SERVICES INC.

1620 MLK Blvd.
New Orleans
Louisiana
70121

PLUMBING PLAN

REV:

SCALE: AS NOTED


JOB: 2060

DATE: 4-1-10

SHEET 3


P-1

OF 3

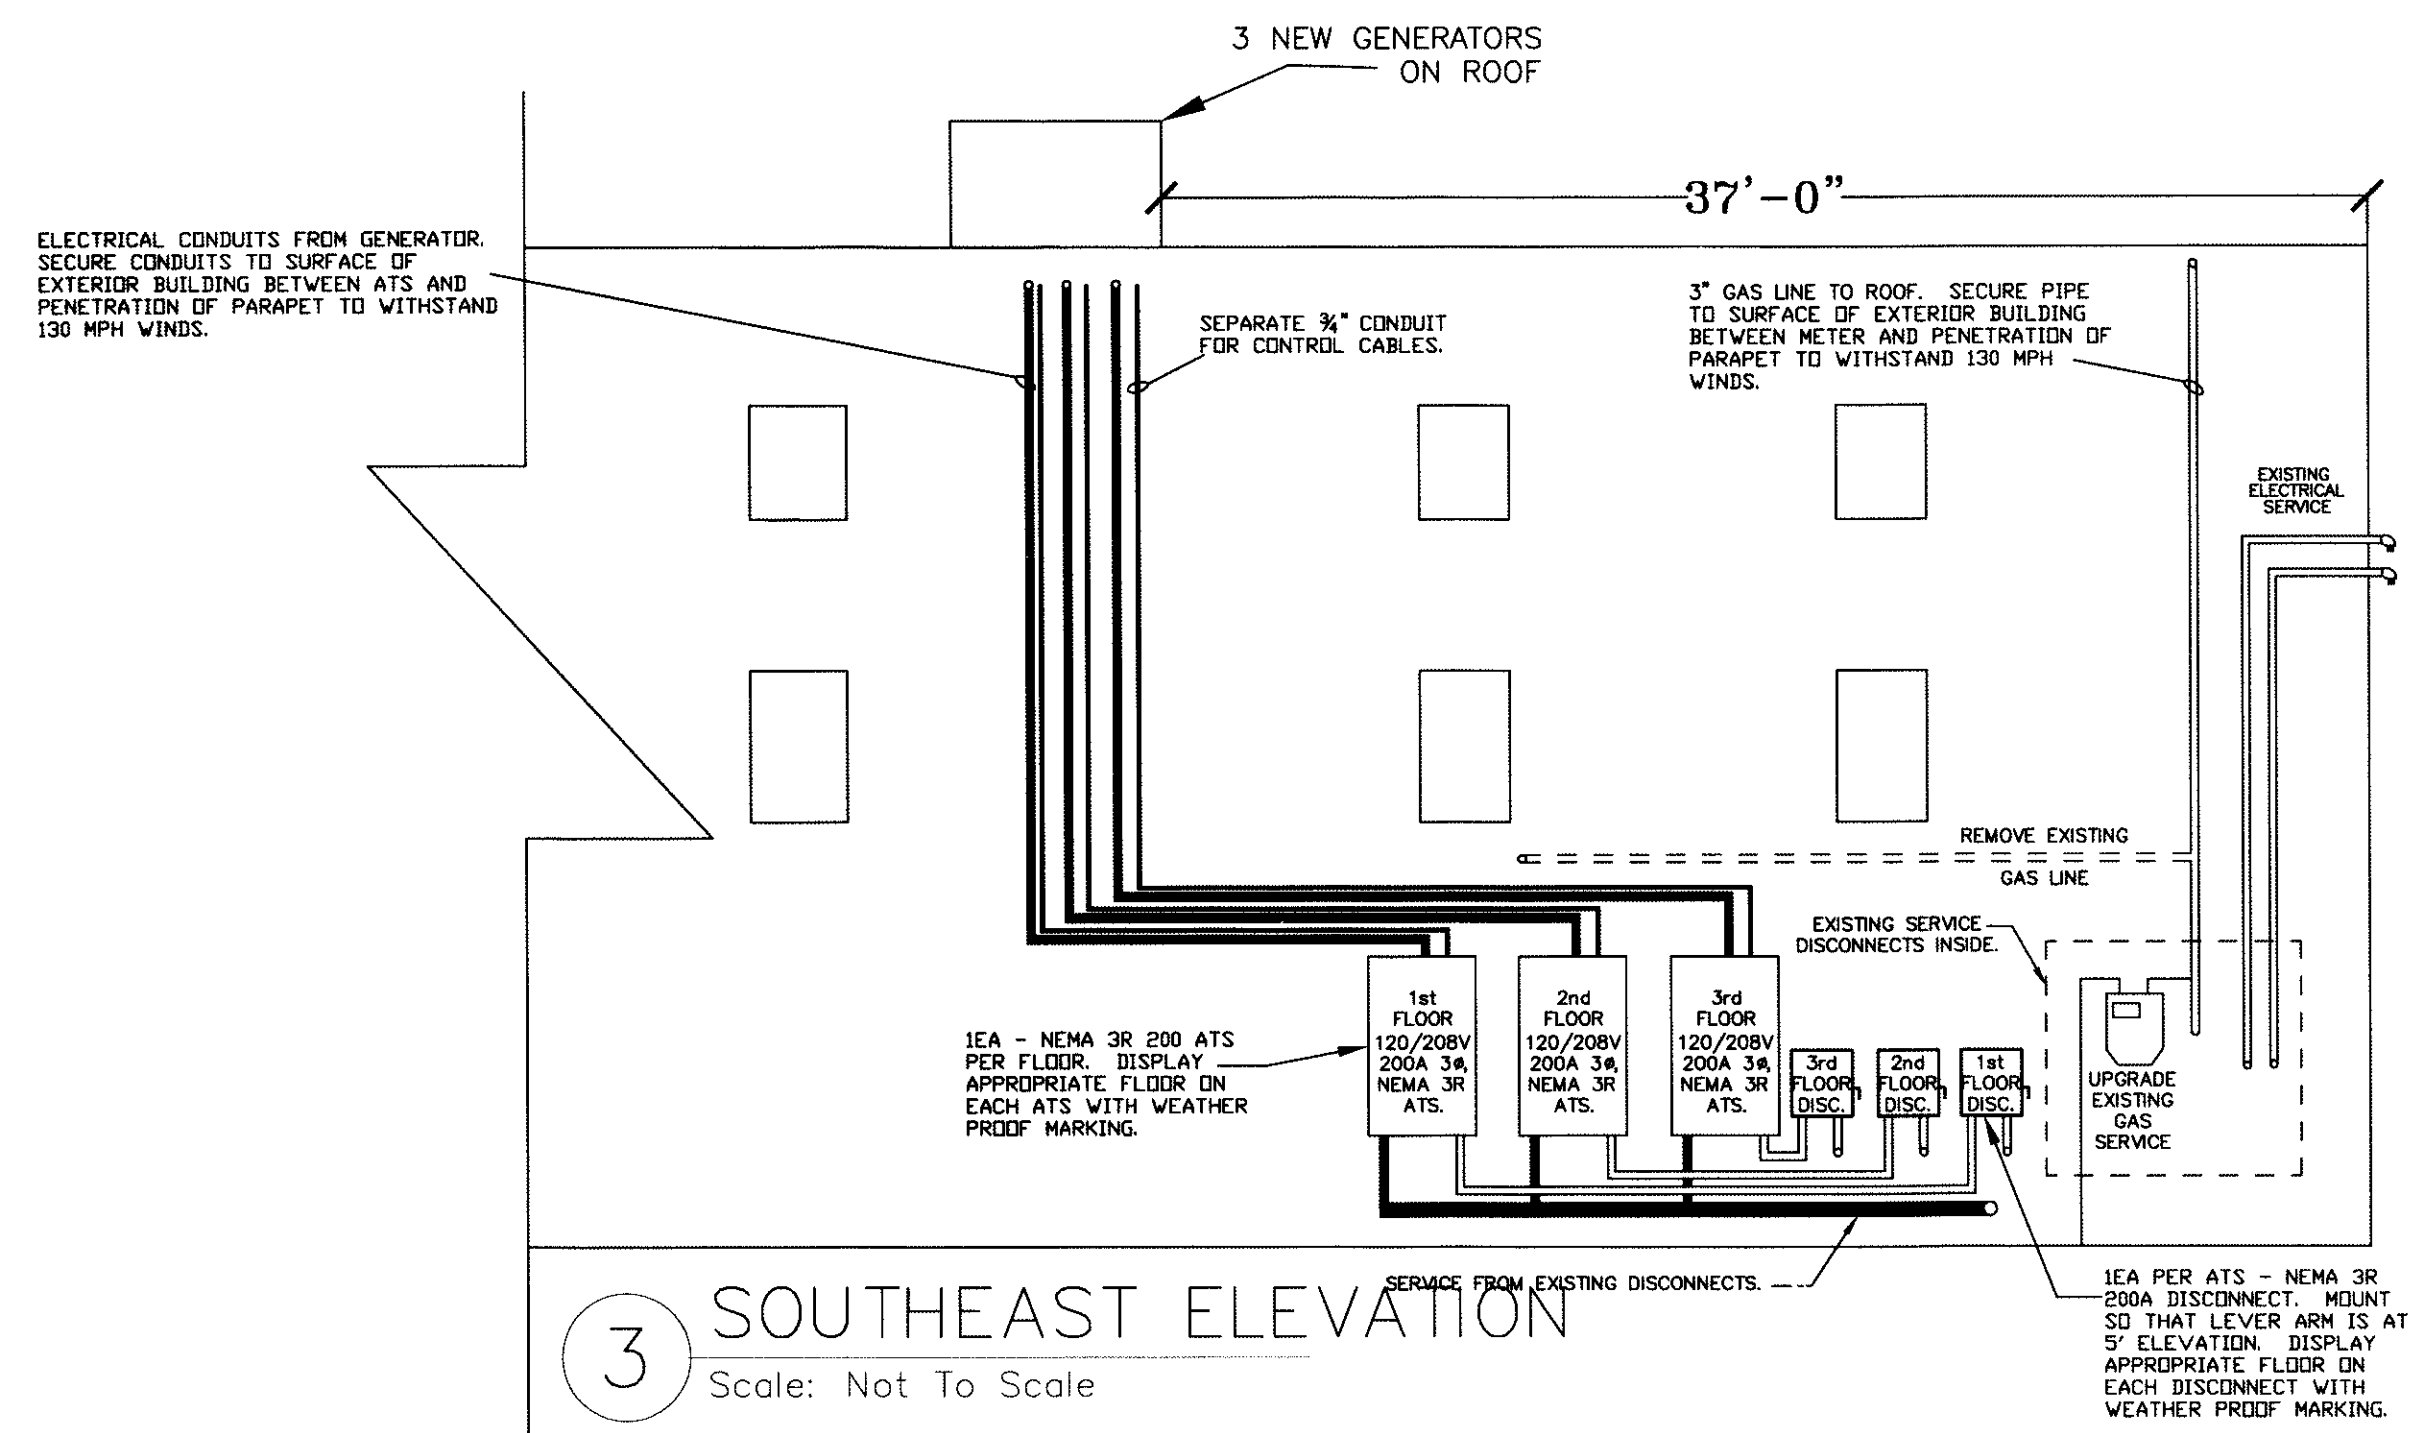


3 SEVENTH ELEVATION
Scale: Not To Scale


- PLUMBING NOTES:**
1. CONTRACTOR IS TO REMOVE THE EXISTING GAS PIPING GOING TO THE FIRST FLOOR.
 2. ATTACH ALL PIPES TO STRUCTURAL BUILDING TO WITHSTAND 130 MPH.
 3. PROVIDE ALL LABOR, MATERIAL AND EQUIPMENT FOR A COMPLETE OPERATING SYSTEM. THE SYSTEM SHALL INCLUDE HANGERS, VALVES AND SUPPORTS WITHOUT ANY RESTRICTIONS TO VOLUME. CUT AND PATCH AS REQUIRED TO INSTALL PIPES.
 4. ALL WORK AND MATERIAL SHALL CONFORM STRICTLY TO THE LATEST LOCAL CITY, PARISH, STATE AND NATIONAL GOVERNING CODES.
 5. CONTRACTOR IS TO FIELD VERIFY ALL EXISTING UTILITY LOCATIONS, ELEVATIONS AND SIZES PRIOR TO COMMENCING ANY WORK.
 6. TEST ALL PIPING AT REQUIRED PRESSURE.
 7. CONTRACTOR IS TO UPGRADE THE NATURAL GAS SERVICE TO MEET THE SERVICE DEMANDS OF THE NEW GENERATORS.
 8. CONTRACTOR SHALL COORDINATE HIS WORK WITH OTHER TRADES AND WITH OTHER CONTRACTORS WHOSE WORK MAY AFFECT THIS INSTALLATION.

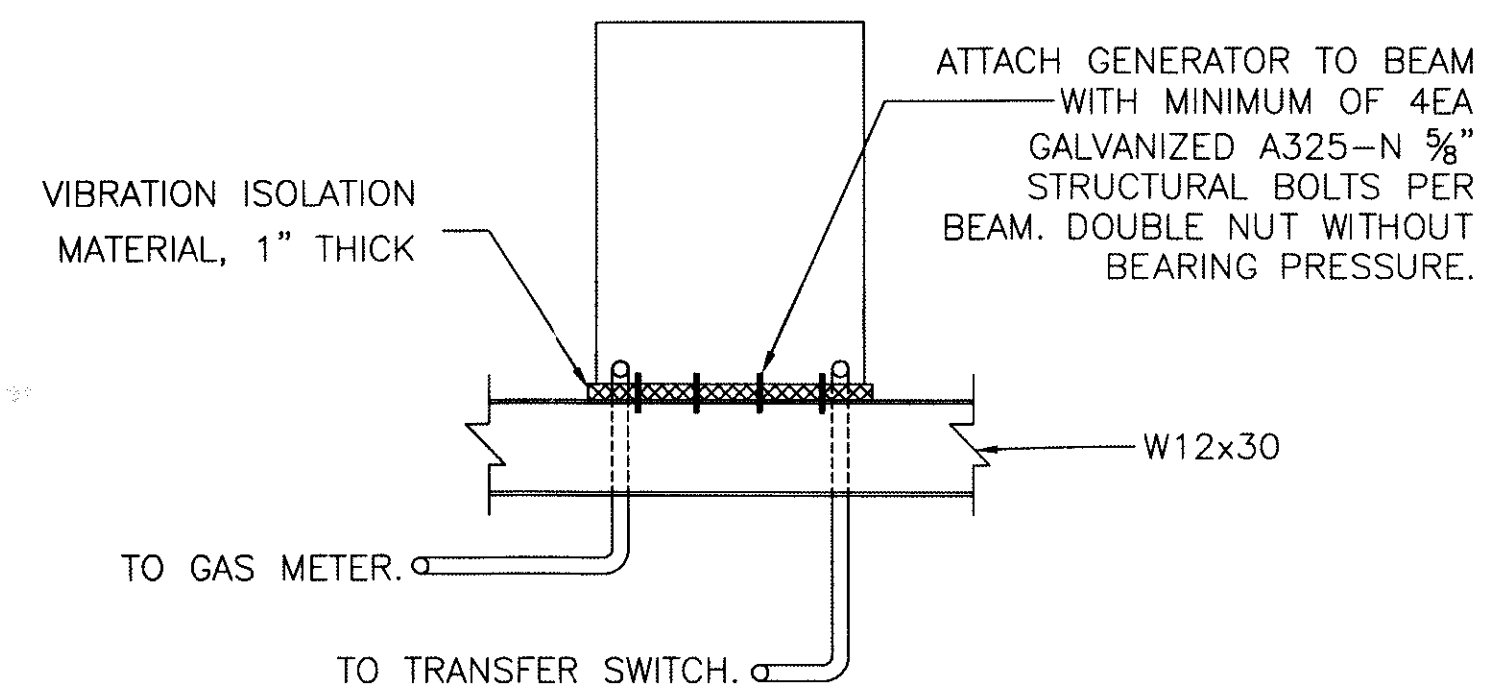

2 TYPICAL GENERATOR SETUP
Scale: Not To Scale

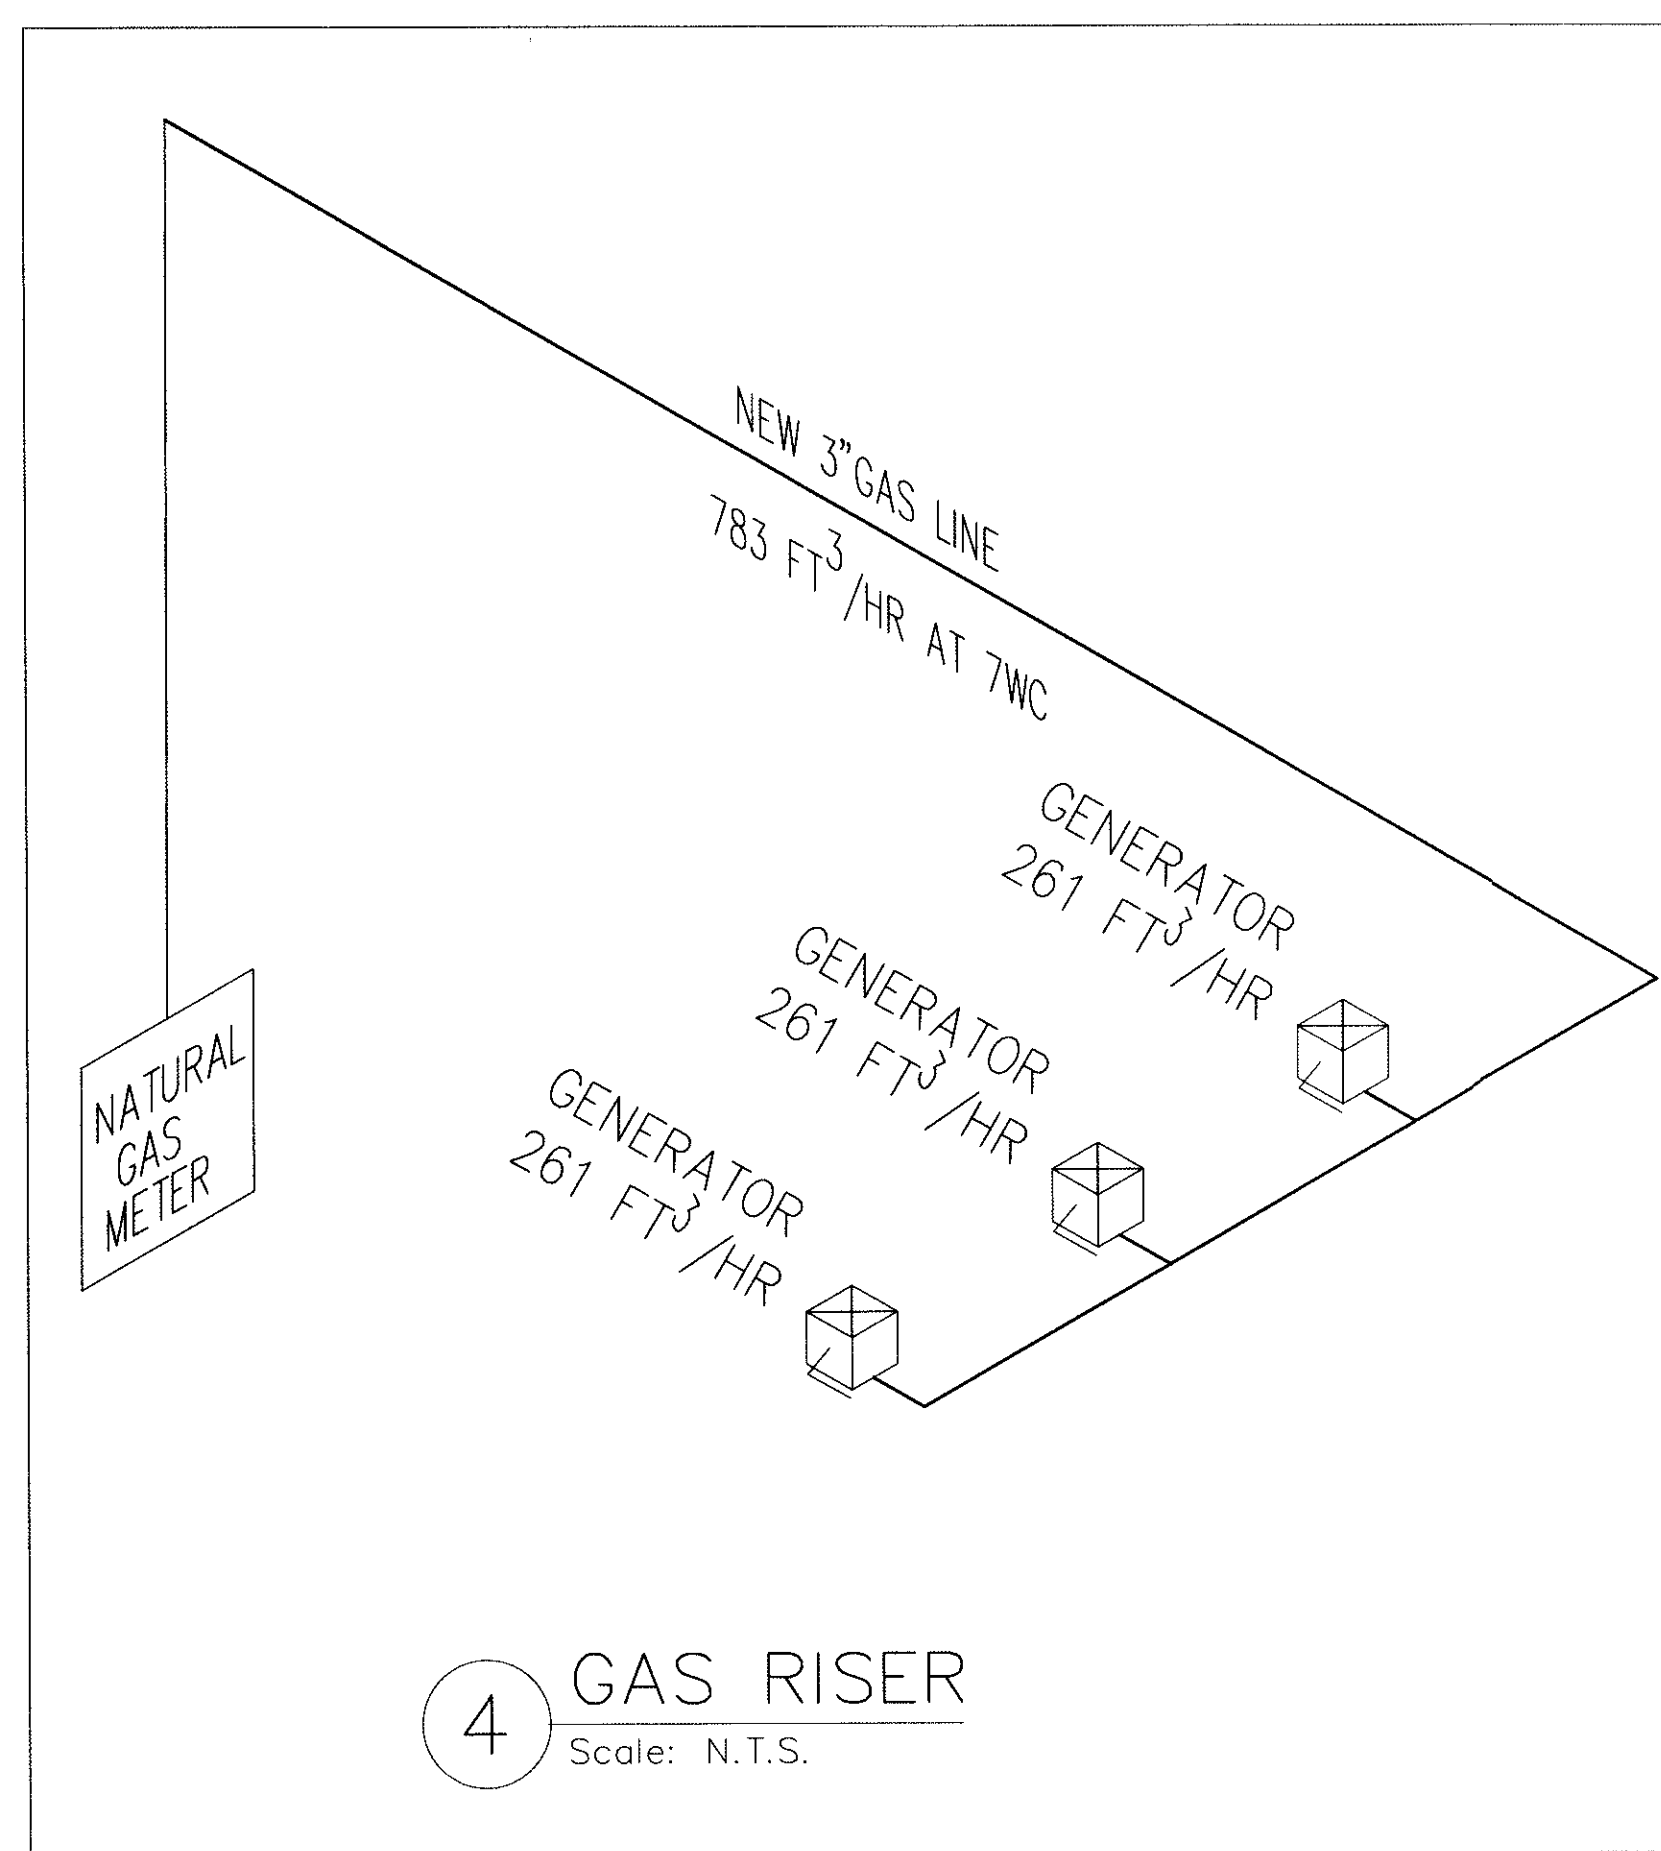

4 GAS RISER
Scale: N.T.S.

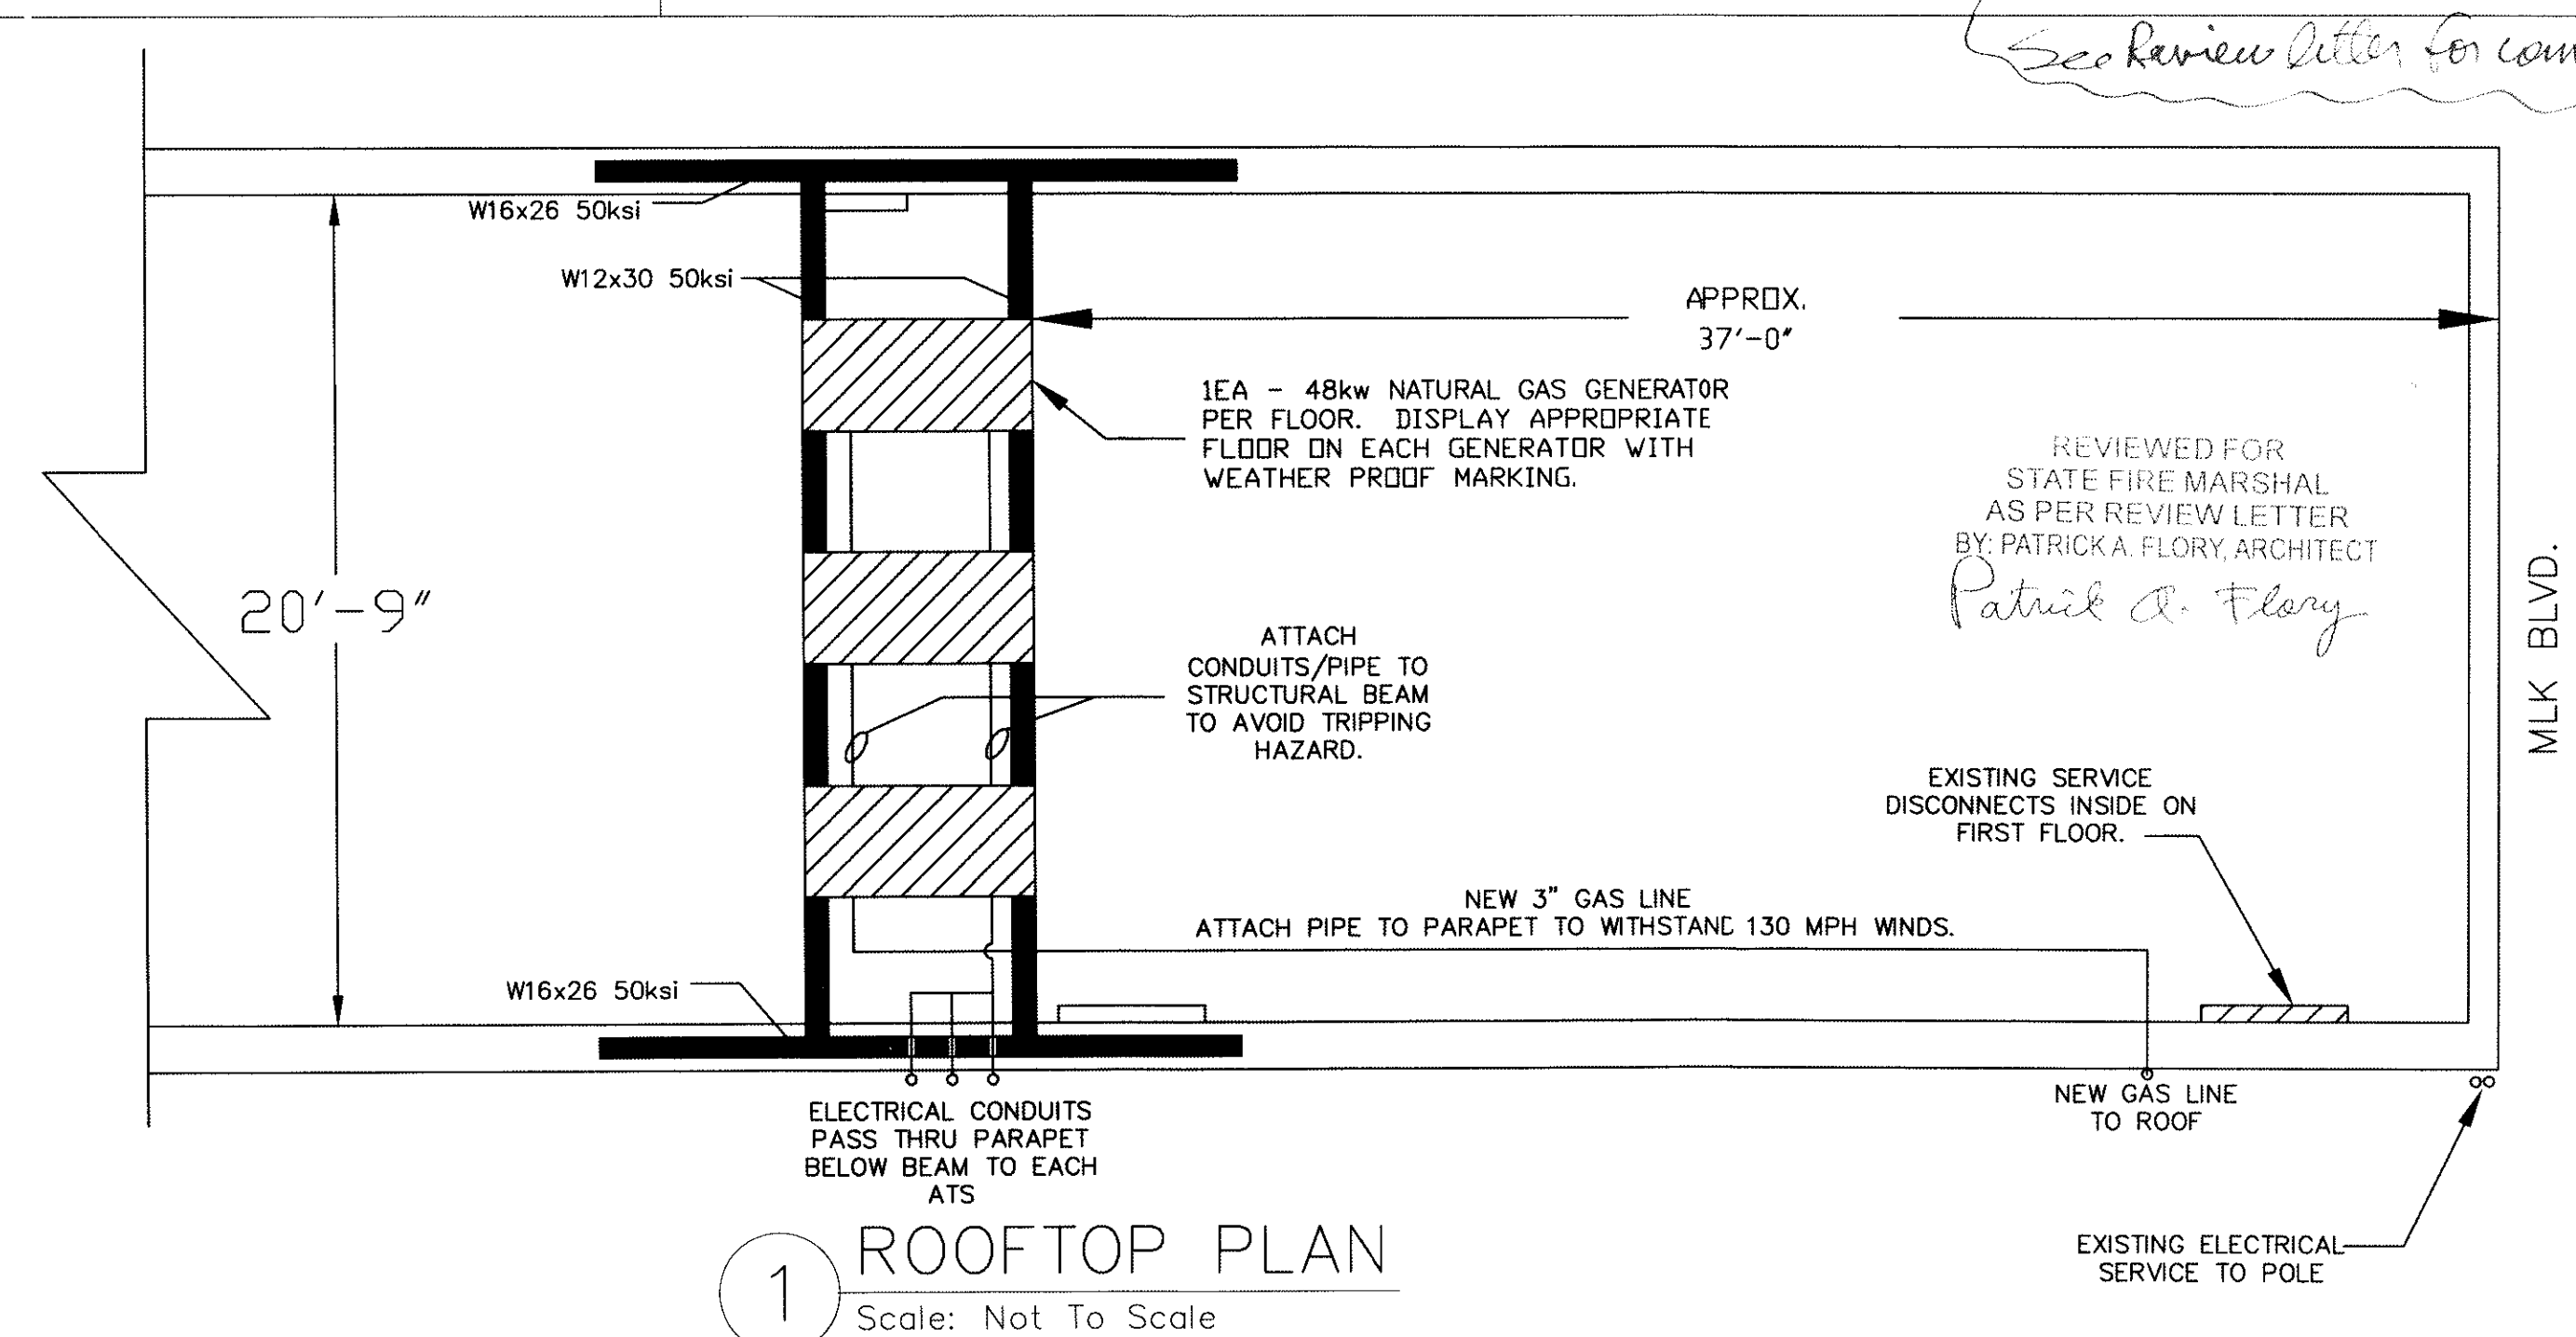

1 ROOFTOP PLAN
Scale: Not To Scale