



E:\WORK\13-0000\13-0000.dwg - Unit: Metric, Graph: Arch, Sheet: Sheet, Date: 11/11/2023, 10:28:44 AM

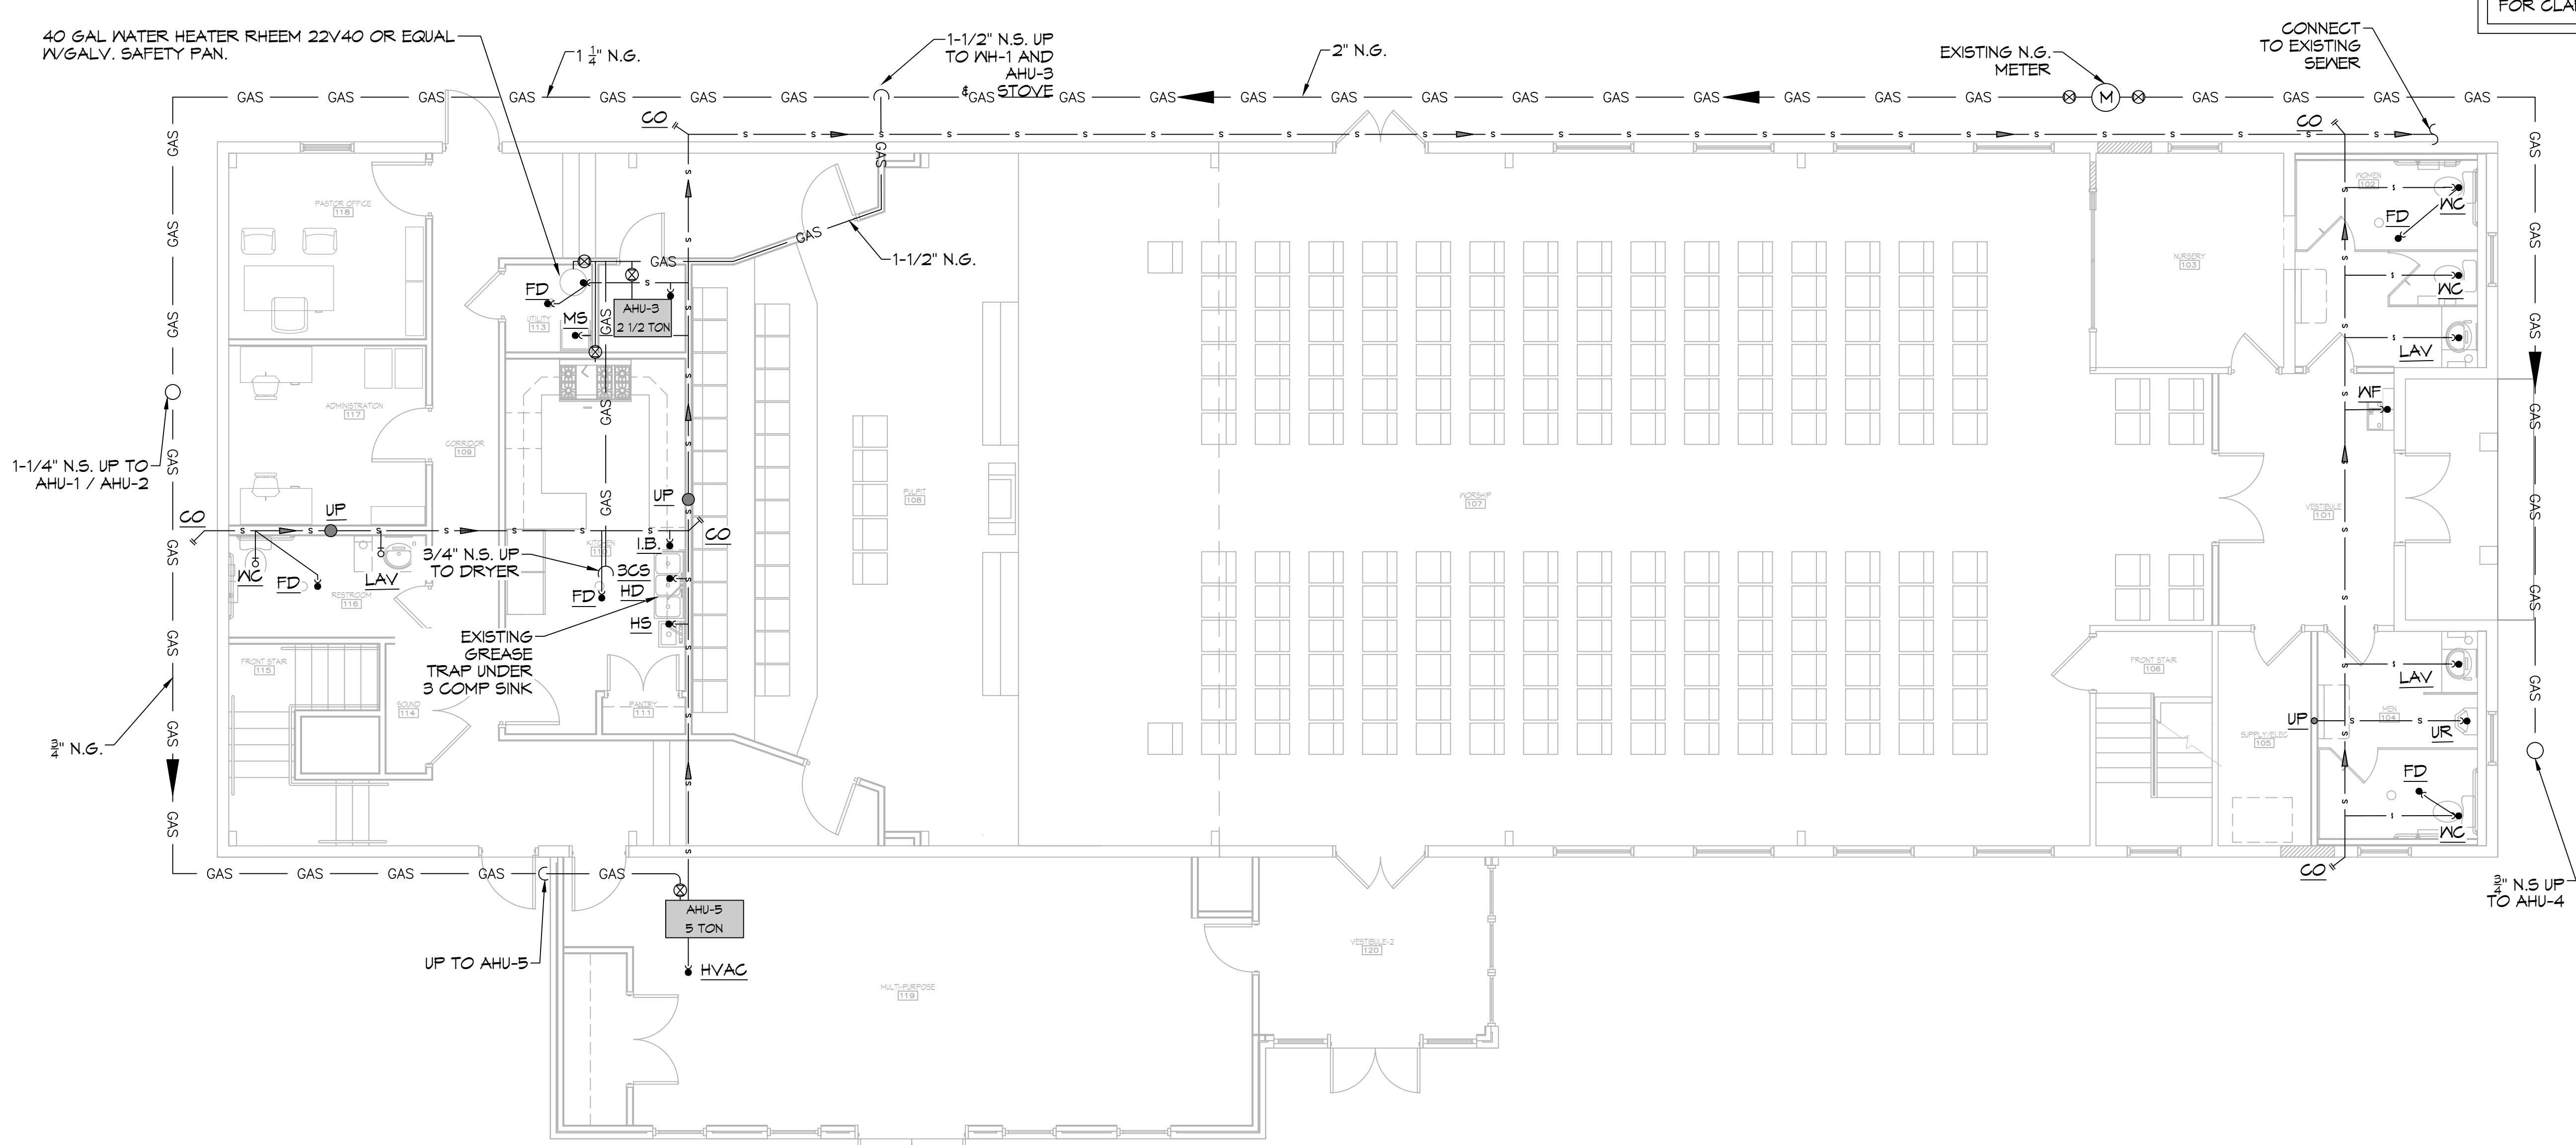

ALL PLUMBING LINES ARE DRAWN DIAGRAMMATICALLY FOR CLARITY.

12 SEWER & GAS PLUMBING PLAN
SCALE: 3/16"=1'-0"

FIRST FLOOR

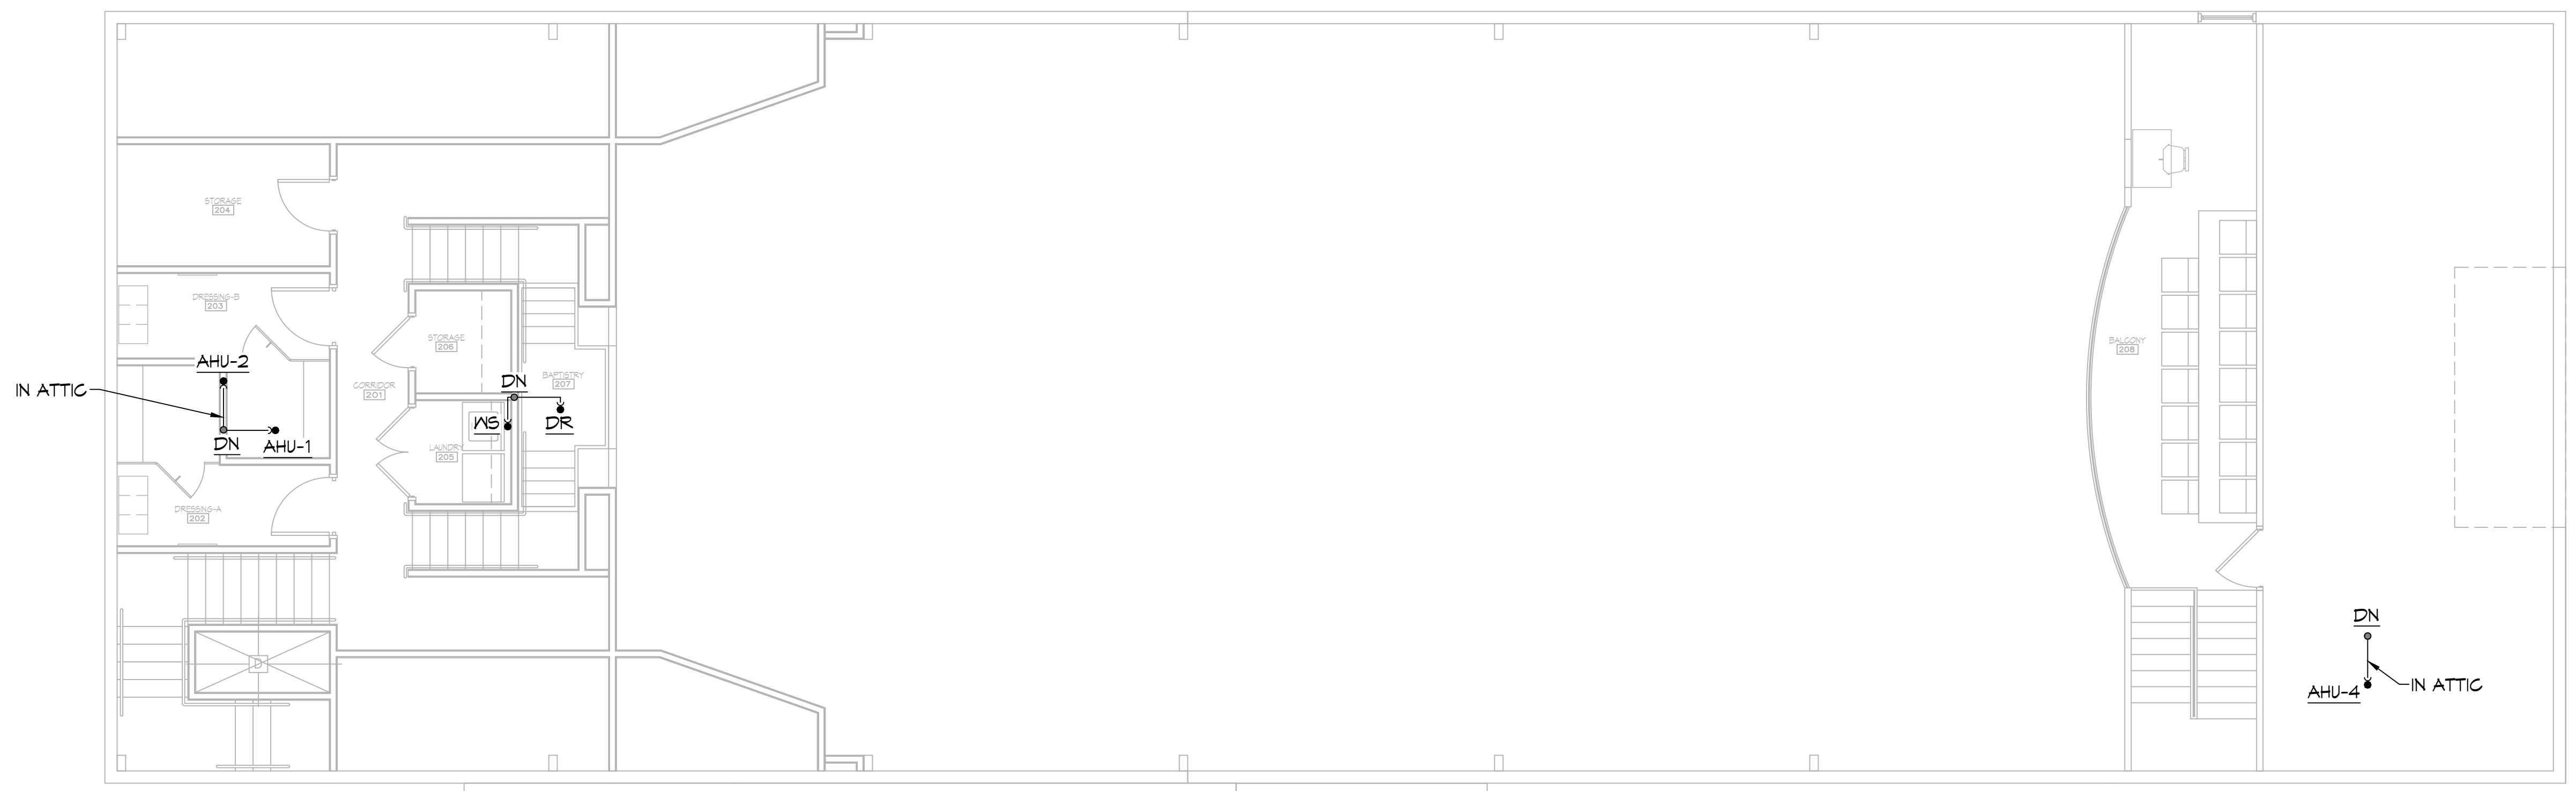

13 SEWER & GAS PLUMBING PLAN
SCALE: 3/16"=1'-0"

SECOND FLOOR

DAMMON ENGINEERING, INC.
LOUISIANA & MISSISSIPPI

Chief Engineer: Brian Mistich, PE
554 Old Spanish Trail
Slidell, LA 70458
www.dammonengineering.com
info@dammonengineering.com
PH: 985.649.5832 F: 985.641.5950

#	DESCRIPTION	REVISIONS	DATE

SIXTH CHURCH REFORMATION BREWERY

420 FELICITY STREET
NEW ORLEANS LA 70130

JOB No: 2470 DATE: 05-26-2023
DRAWN BY: CKD CHECKED BY: BAY

SHEET TITLE:
SEWER AND GAS
PLUMBING PLAN -
FIRST FLOOR, SECOND
FLOOR AND ATTIC

DRAWING NUMBER:
P101