


PLUMBING FIXTURE SCHEDULE									
MARK	FIXTURE	HW	CW	RAIN	TRAP	DESCRIPTION	MFR	NAME	NUMBER
WC	WATER CLOSET	-	1/2"	4"	-	VITREOUS CHINA GLOBE COUPLED SIPHON JET. ELONG TOILET, BOLT CAPS, OPEN FRONT SEAT W/COVER, ANGLE SUPPLY	KOHLER	"WELLWORTH"	K-3500 EB
LAV	LAVATORY	1/2"	1/2"	2"	1 1/2"	VITREOUS CHINA WALL MTR LAV. W/ SINGLE LEVER FAUCET, AERATOR, POP UP DRAIN, ANGLE SUPPLIES, TRAP	KOHLER	"GREENWICH"	K-2030, 20"x10" W/ K-6883 TRIM
SINK	SINK	1/2"	1/2"	2"	1 1/2"	SELF RIMMING 3/4" 18 GA. 22"x22" 3/4" COMP SINK W/ 10" H. GOOSE NECK SPOUT, 6" WRIST BLADES, ①	ELKAY	"WIMERTONE"	LK-2222
SERVICE SINK	SERVICE SINK	1/2"	1/2"	2"	1 1/2"	3/4" COMP 14 GA. 3/4" SCULLERY SINK, 2 LK 66 C FAUCETS, 1/4" TO CONT. WASTE, 3/4" 35 WASTE FITTINGS	ELKAY	"WELD BILT"	46 8130
FD	FLOOR DRAIN	-	-	4"	-	FLOOR DRAIN W/ SATIN BRONZE STRAINER	JOHNSON		30,000 A
OSD	OPEN SAHIT DRAIN	-	-	-	-	OPEN SAHIT DRAIN W/ FUNNEL & SATIN BRONZE STRAINER	JOHNSON		30,000 E2
EWL	ELECTRIC WATER COOLER	-	-	-	-	6.7 GPH, 350 W., 4.5 FLA, 1/8 HP	HALSEY TAYLOR		EFZ-75S
WH	WATER HEATER	3/4"	3/4"	-	-	ELECTRIC W.H., 50 GAL, 240 V., 1 φ W/2 SIMULTANEOUS 4500 W. ELEMENTS			


① AERATOR, STRAINER & STOPPER, ANGLE SUPPLIES, TRAP

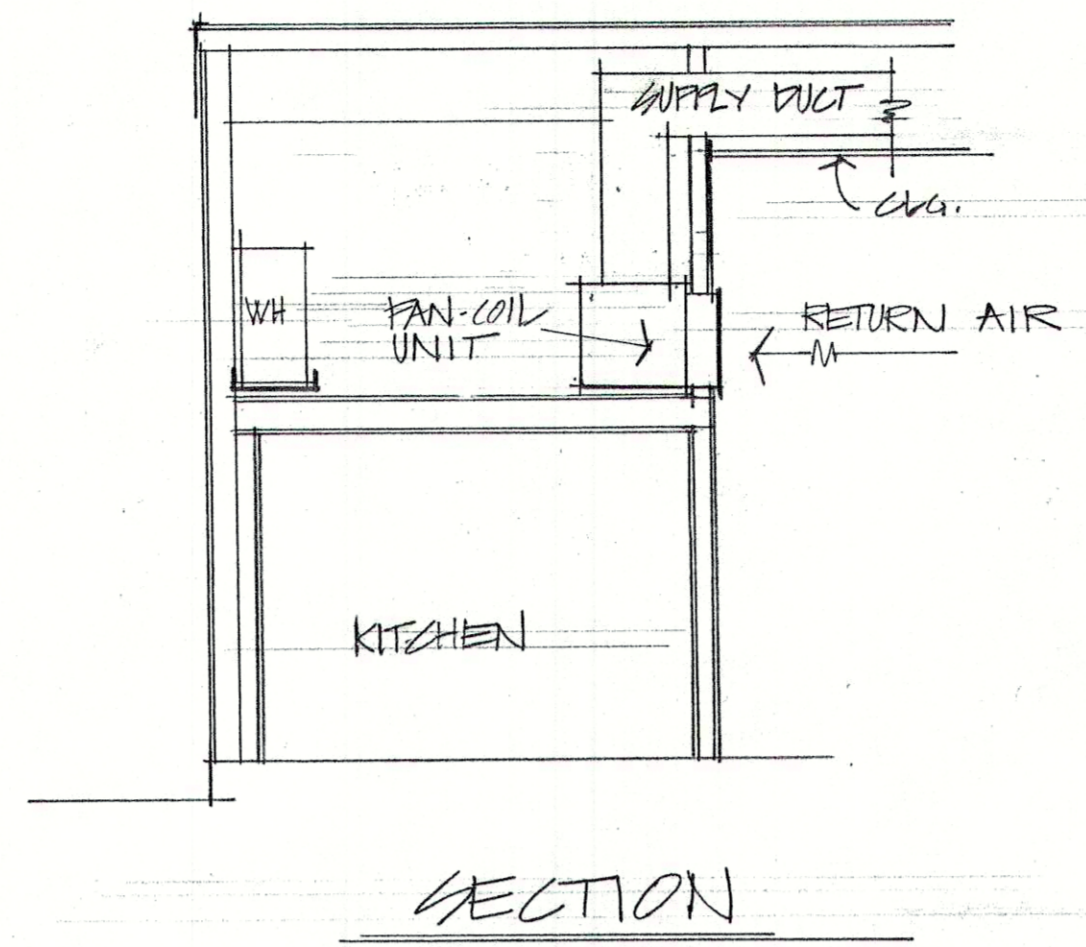

HEATING & AIR CONDITIONING UNIT SCHEDULE												
FAN COIL UNIT							CONDENSING UNIT					
MARK	COOLING BTU/HR	CFM	FAN HP	VOLTS	PH	HTR KW	MODEL NO.	VOLTS	PH	COMP FLA	COMP FAN	MODEL NO.
HVAC	74,000	2400	1	230	3	10	LENNOX CB 17-95V	208/230	3	26.7	2.9	H 817-013V ②


EXHAUST FAN SCHEDULE										
MARK	TYPE	CFM	GRATIC IN W/G	MIN. HP	VOLTS	PH	MAX. SPEED	MODEL NO.	CONTROL	
EF 1	CEILING MOUNT CENTRIFUGAL	110			120	1	3.5	NUTONE 8814	INTERLOCK W/ LIGHTS, ①	
EF 2	RANGE HOOD & SHELF W/CENTRIFUGAL BLOWER	300			120	1	4.5	BROAN 123035		

① FURNISH W/ VARIABLE SPEED CONTROL, COOK FAN TYPE
② EER 8.5

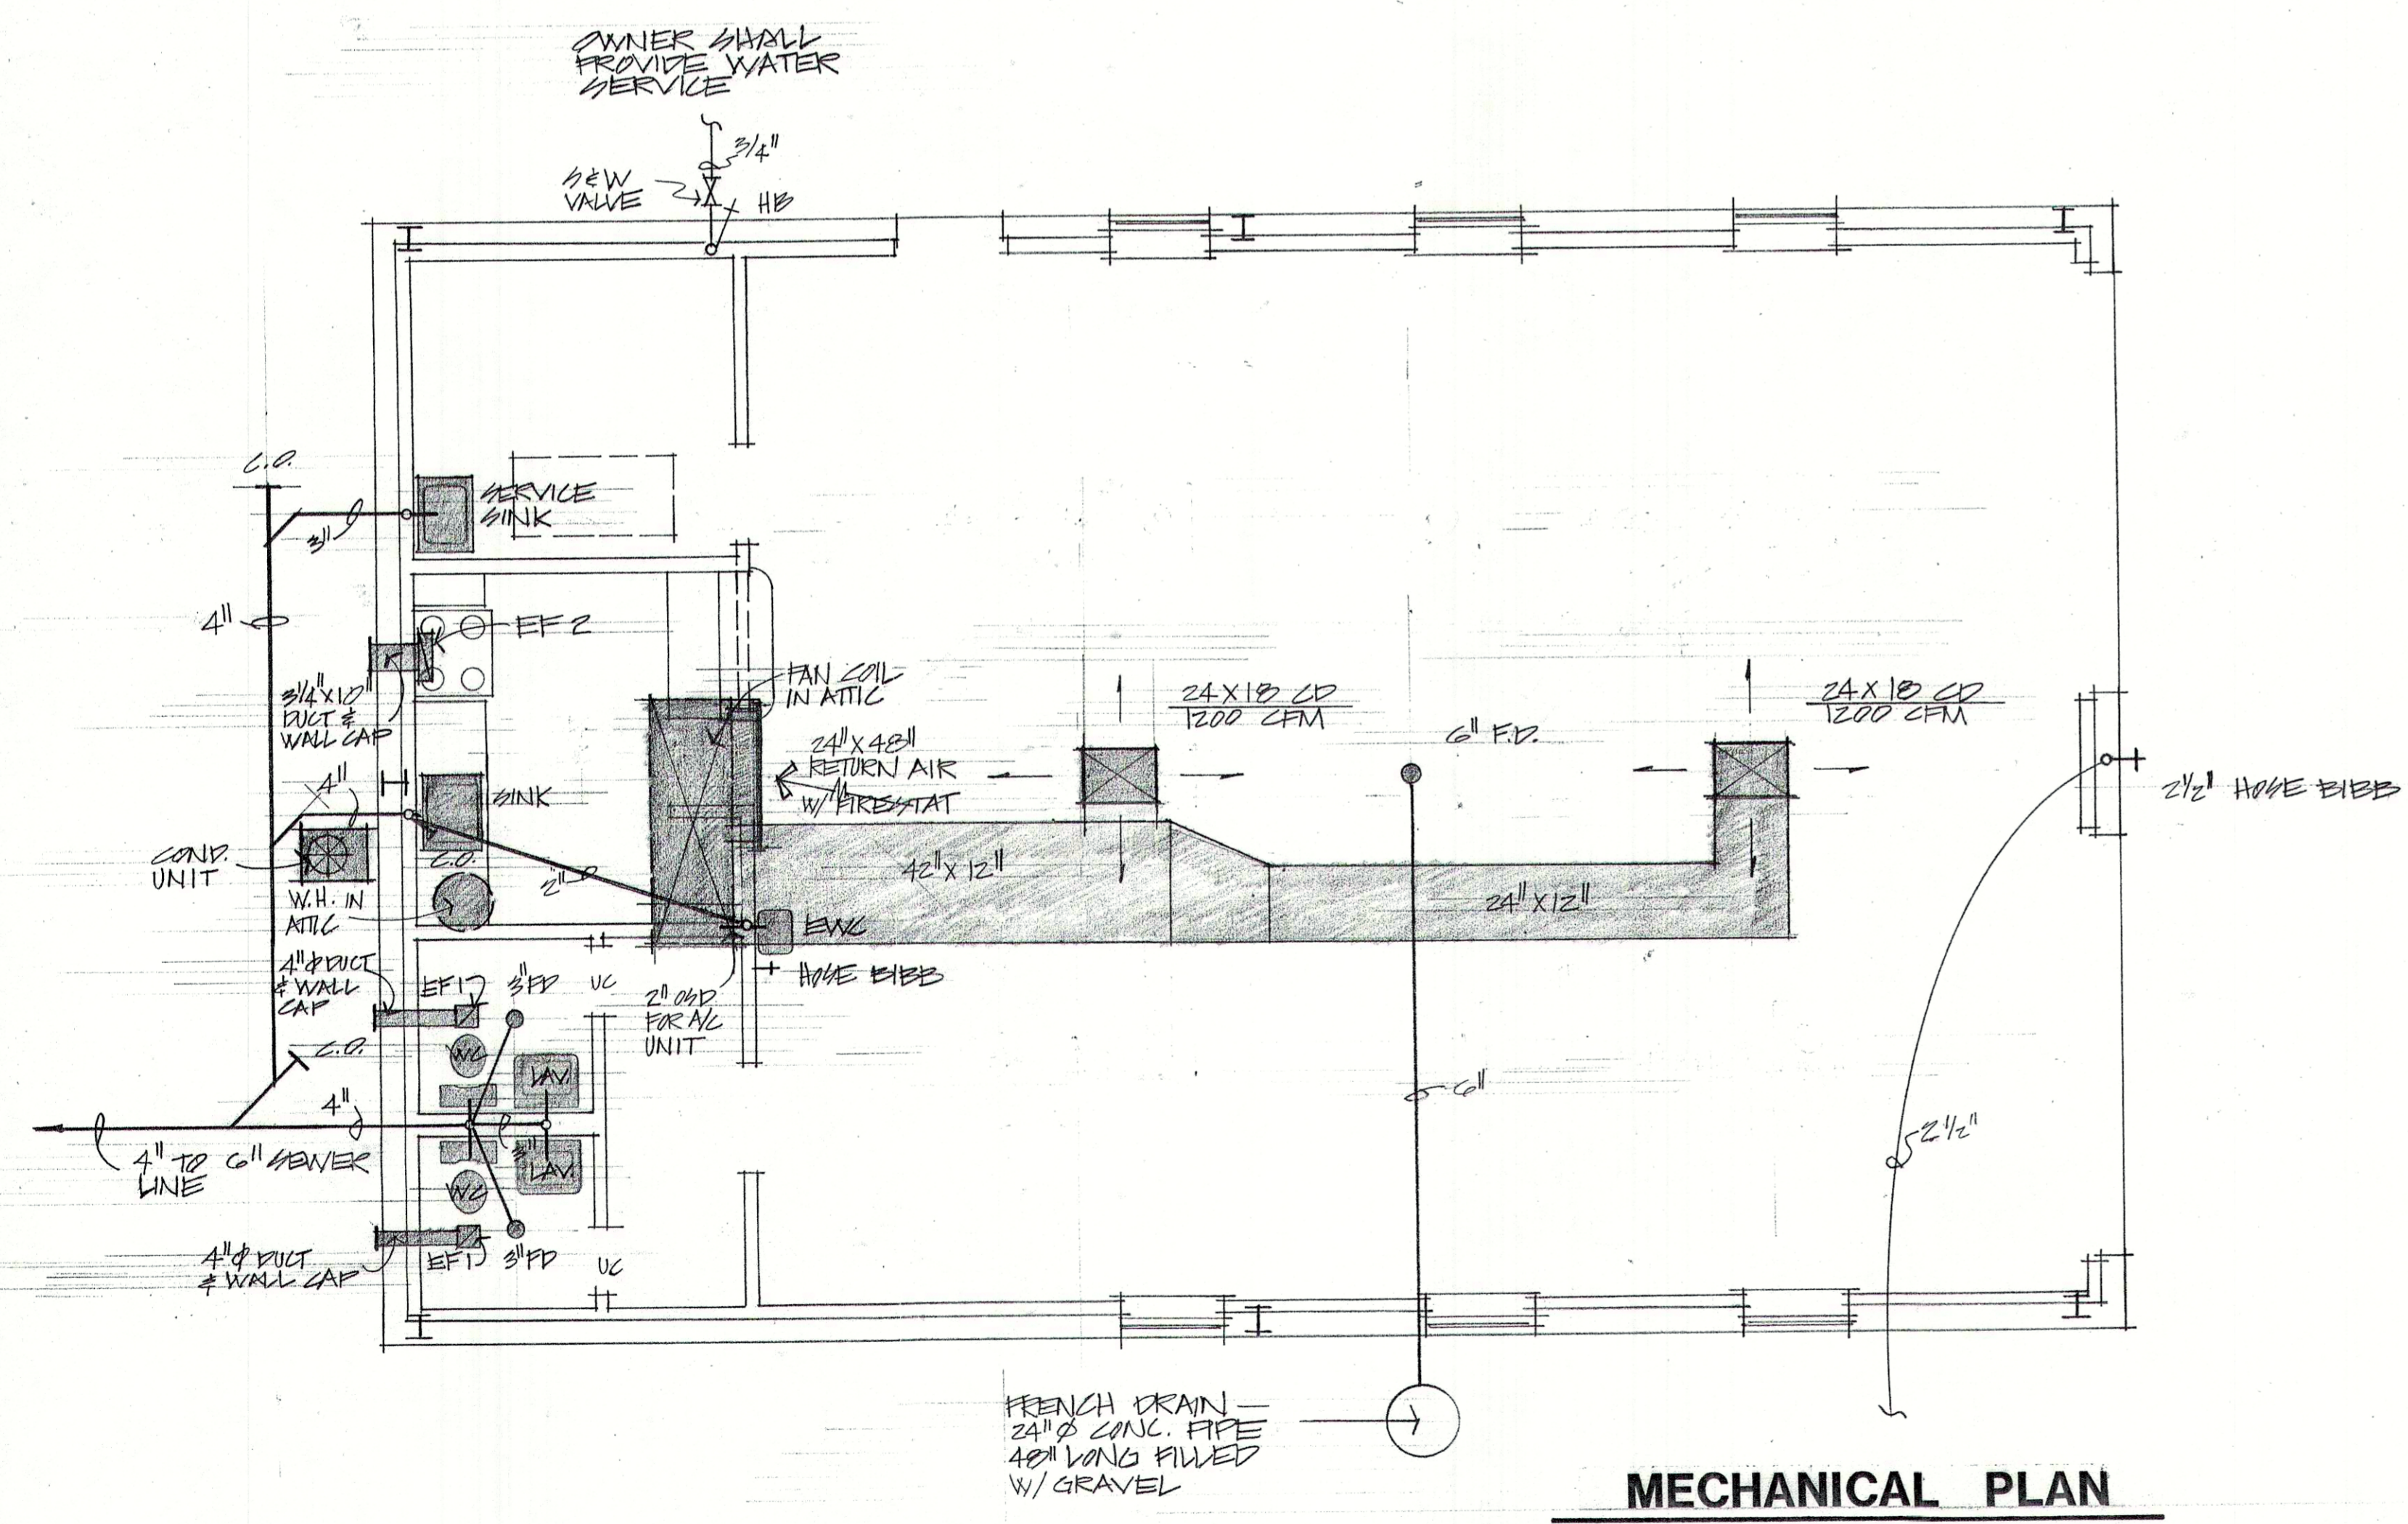

MECHANICAL PLAN

SCALE 1/4" = 1'-0"

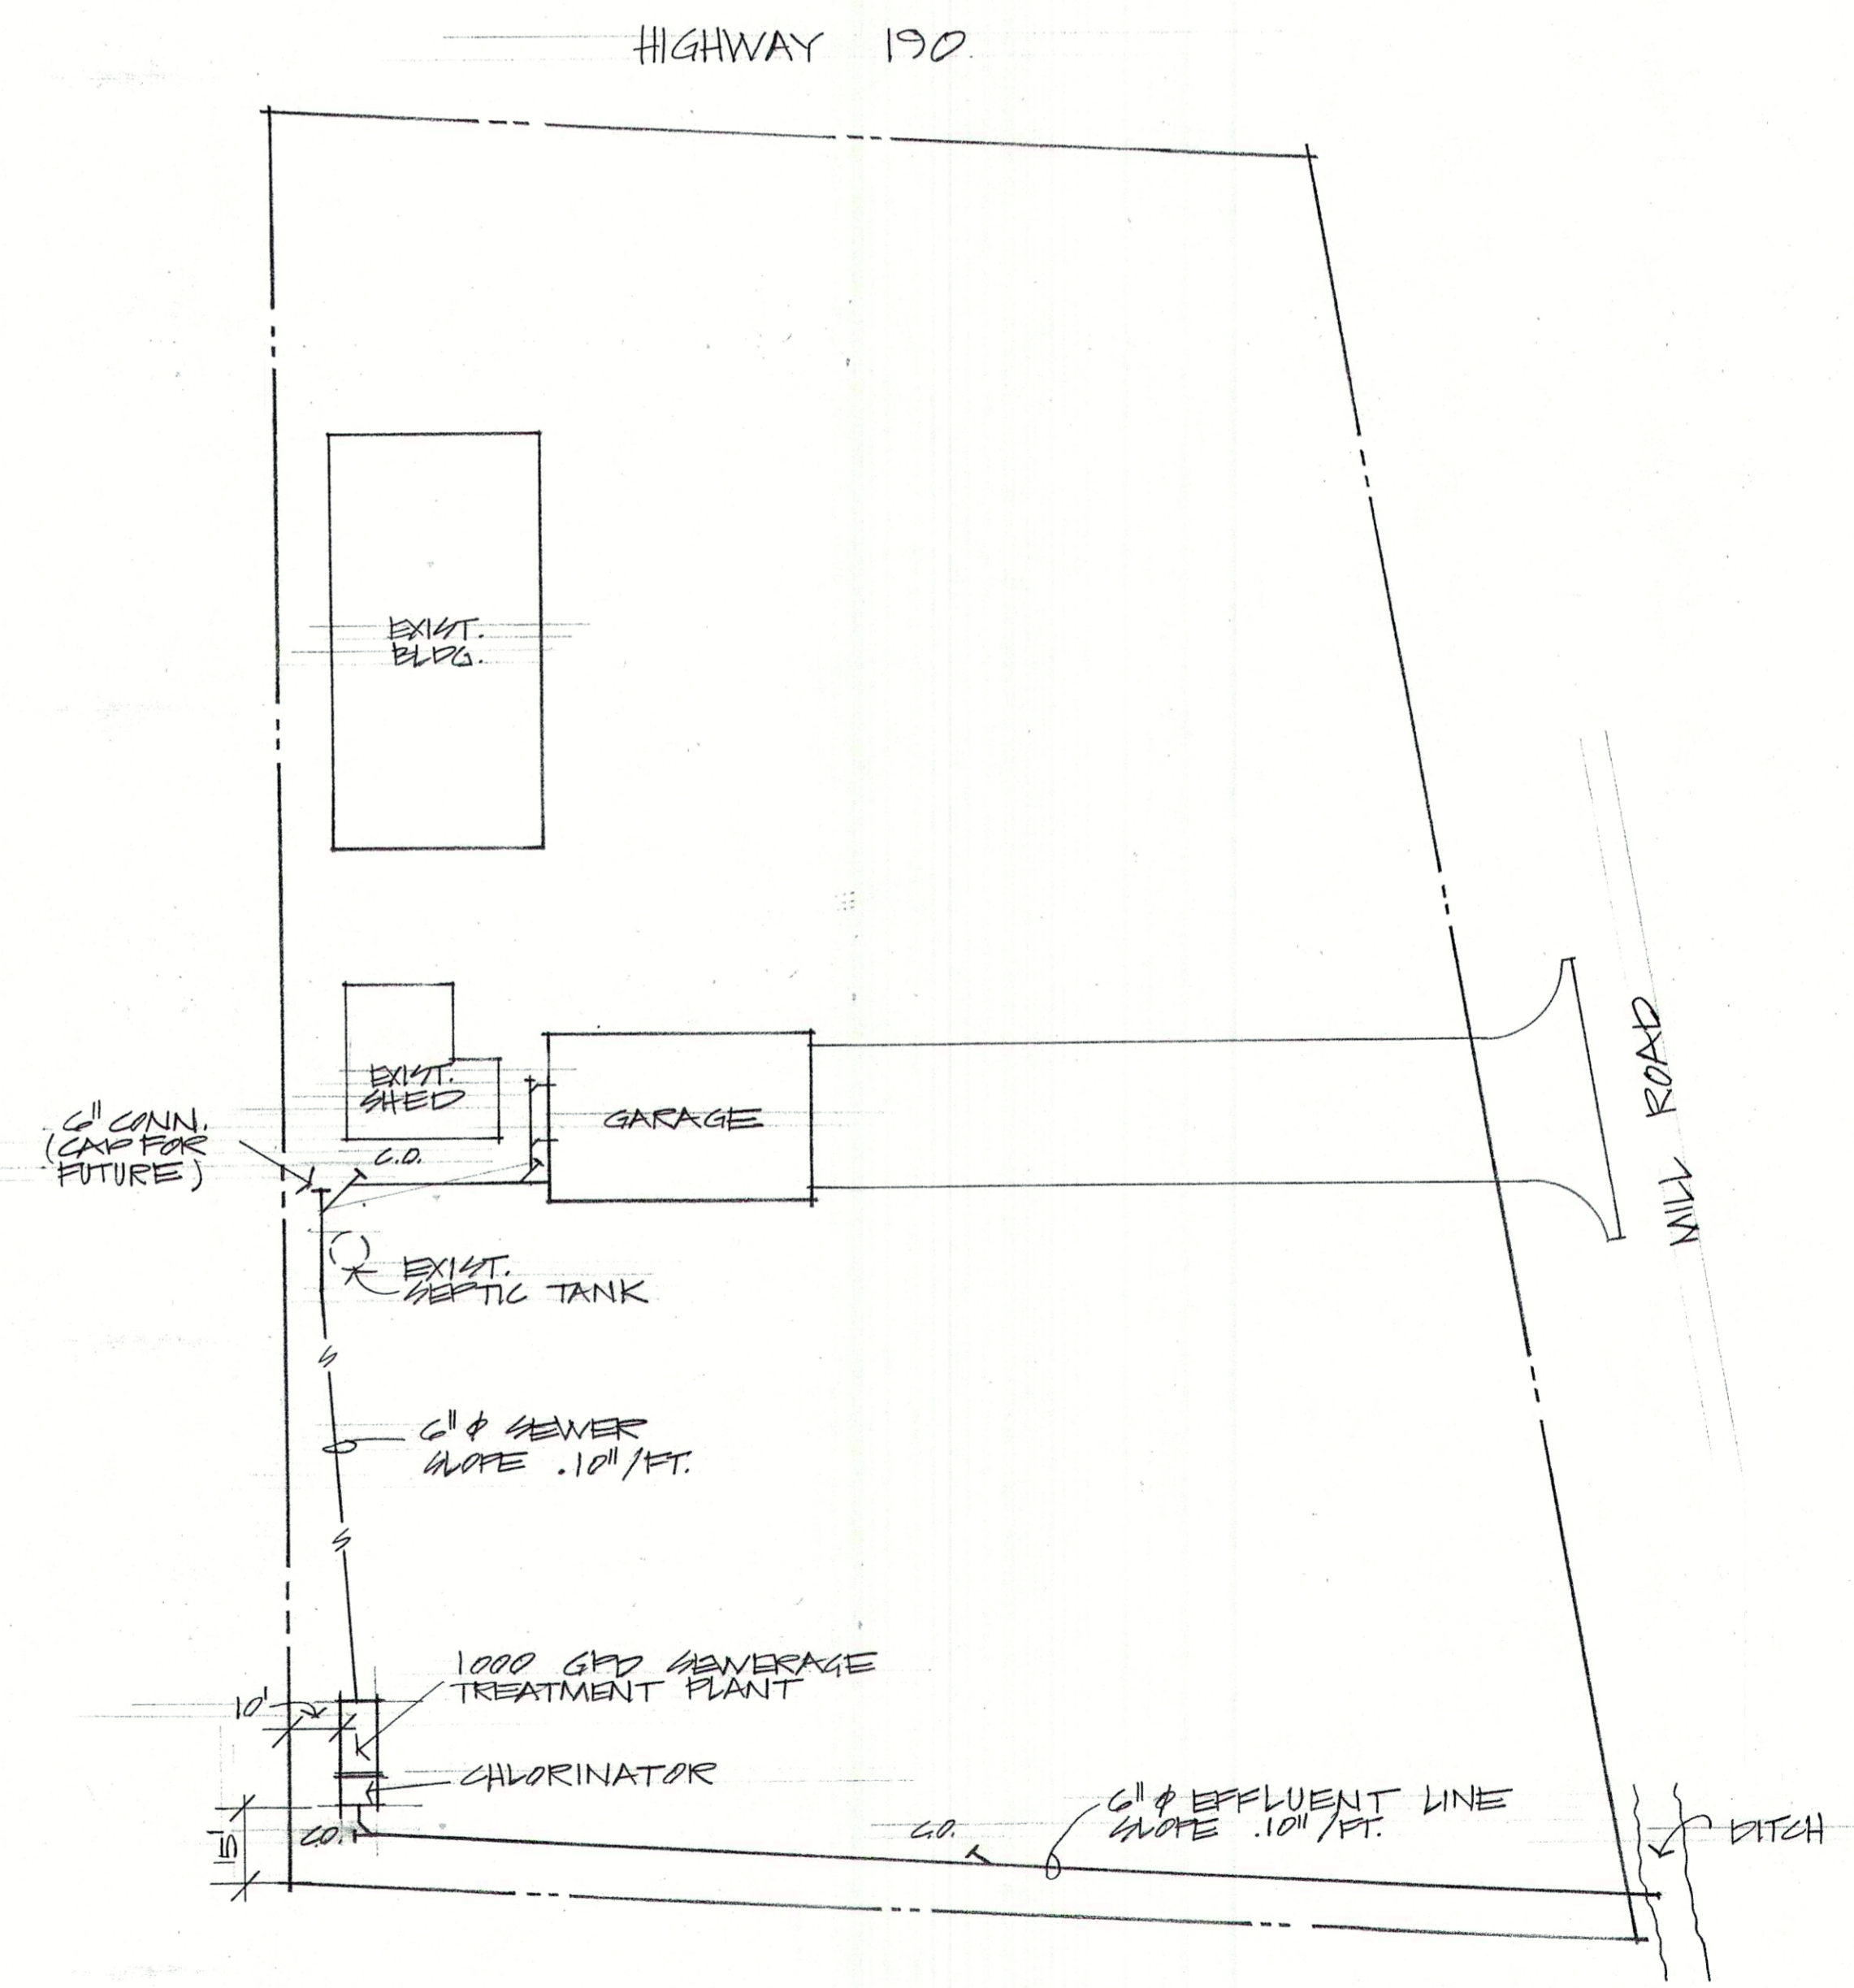

SITE PLAN

SCALE 1" = 30'

RENE A. HARRIS & ASSOCIATES
CONSULTING ENGINEER

OAKLAWN FIRE STATION
GARAGE ADDITION - PHASE III

DATE
3-1-90

SHEET
3
OF 5