


MECHANICAL PLAN - LEVELS 2 & 3
SCALE: 3/32"=1'-0"

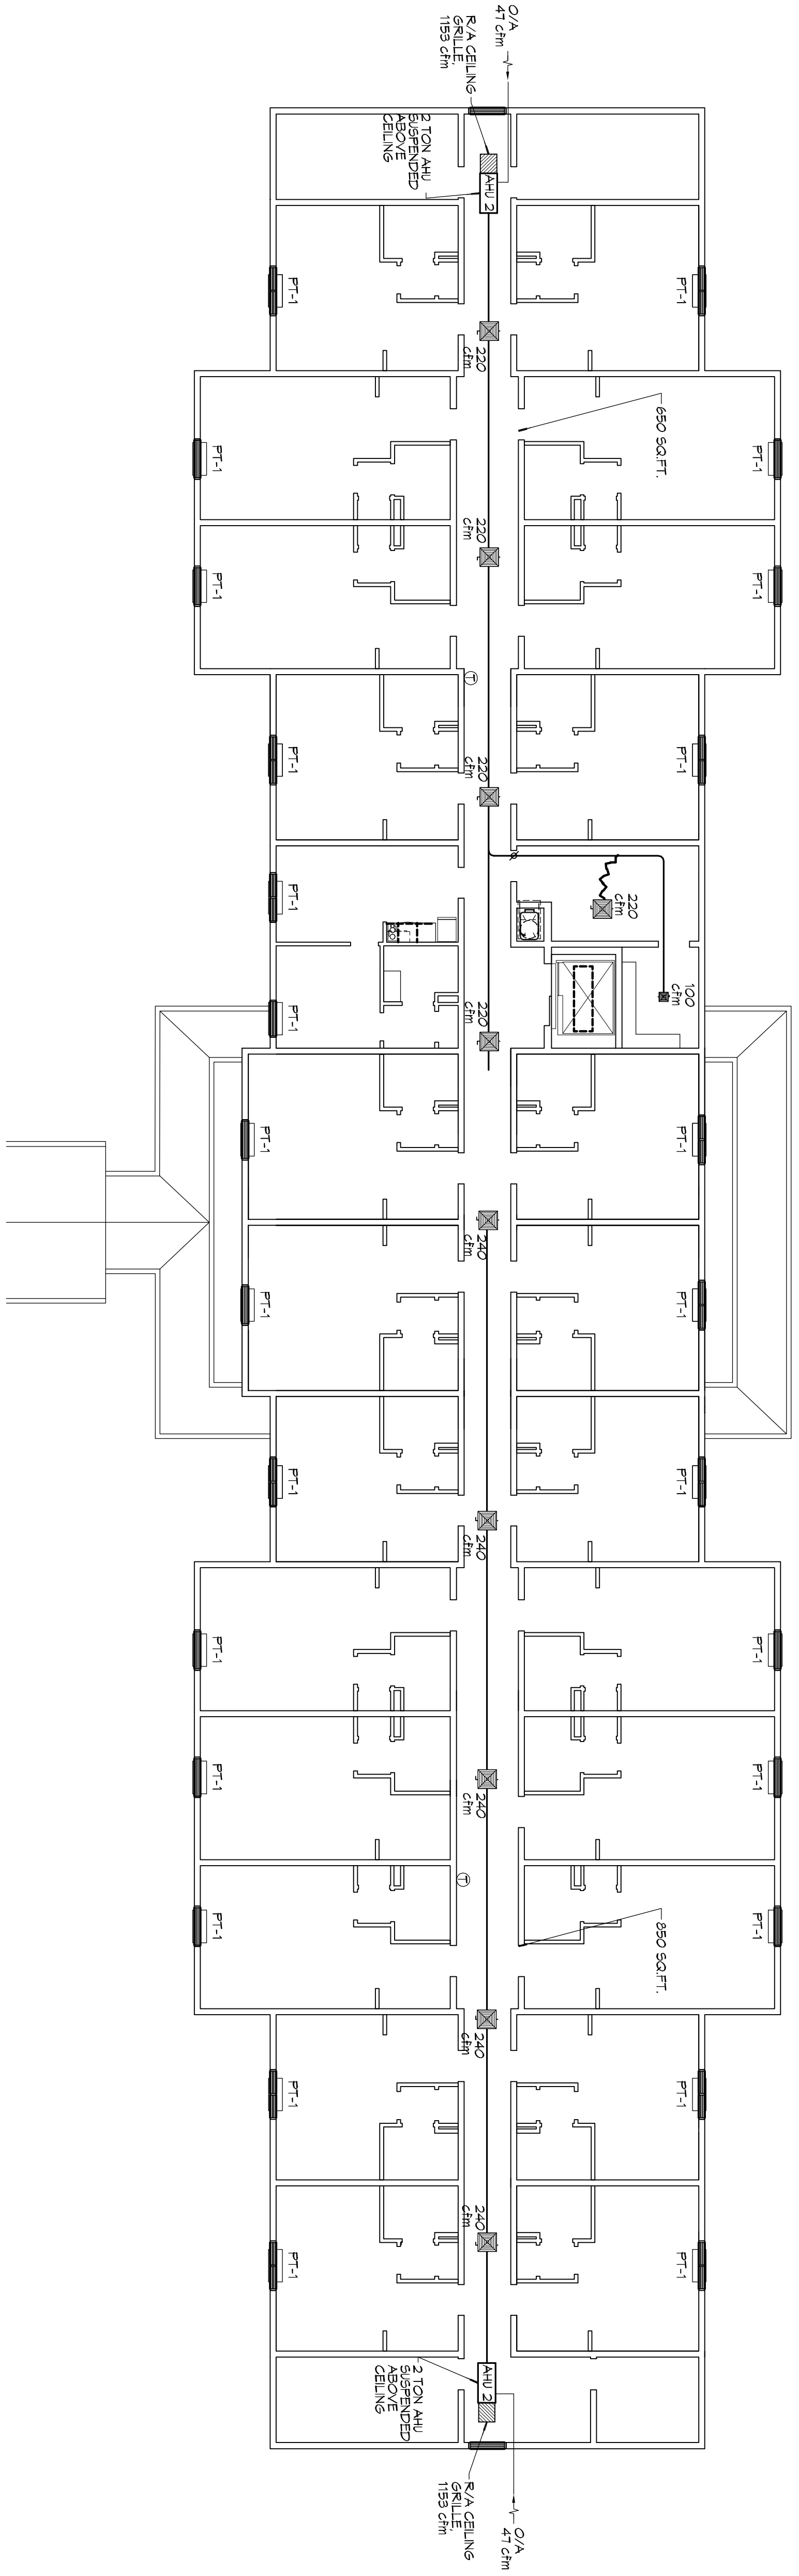

PTAC SCHEDULE									
UNIT	TOTAL BTU	CFM	OA	HEA T (KW)	ELECTRICAL VOLT	MC A	YAW O/G/P	MMR	
PT-1	9,000	360	36	3.5	208V/3Ø	145	20	AMANA	
PT-2	4000	330	33	-	208V/3Ø	5.1	15	AMANA	
PT-3	12000	370	37	5.0	208V/3Ø	21	30	AMANA	
COREDORS									

MAINSTAY SUITES

LOT #1 LA HWY 27 HACKBERRY, LA 70645
 JOB No: 2265 DATE: JANUARY, 2016
 DRAWN BY: CKD CHECKED BY: CKD

This drawing contains the specifications, design and engineering responsibility and shall remain the property of Dammon Engineering, and no part thereof shall be copied, reproduced, or used in connection with any work or project other than that specified in the contract. The user shall be responsible for obtaining all necessary permits and approvals from the appropriate authorities. Dammon Engineering, Inc. shall not be held responsible for any errors or omissions in this drawing. Dammon Engineering, Inc. shall not be held responsible for any damage or injury resulting from the use of this drawing.

REVISIONS		
#	DESCRIPTION	DATE

DAMMON ENGINEERING, INC.
 LOUISIANA & MISSISSIPPI

Chief Engineer: Brian Mistch, PE
 554 Old Spanish Trail
 Stidell, LA 70458
 www.dammonengineering.com
 info@dammonengineering.com
 PH: 985.649.5832 F: 985.641.5950

M102
 SHEET No: 30 of 30