


MECHANICAL PLAN - LEVELS 2 & 3
SCALE: 3/32"=1'-0"

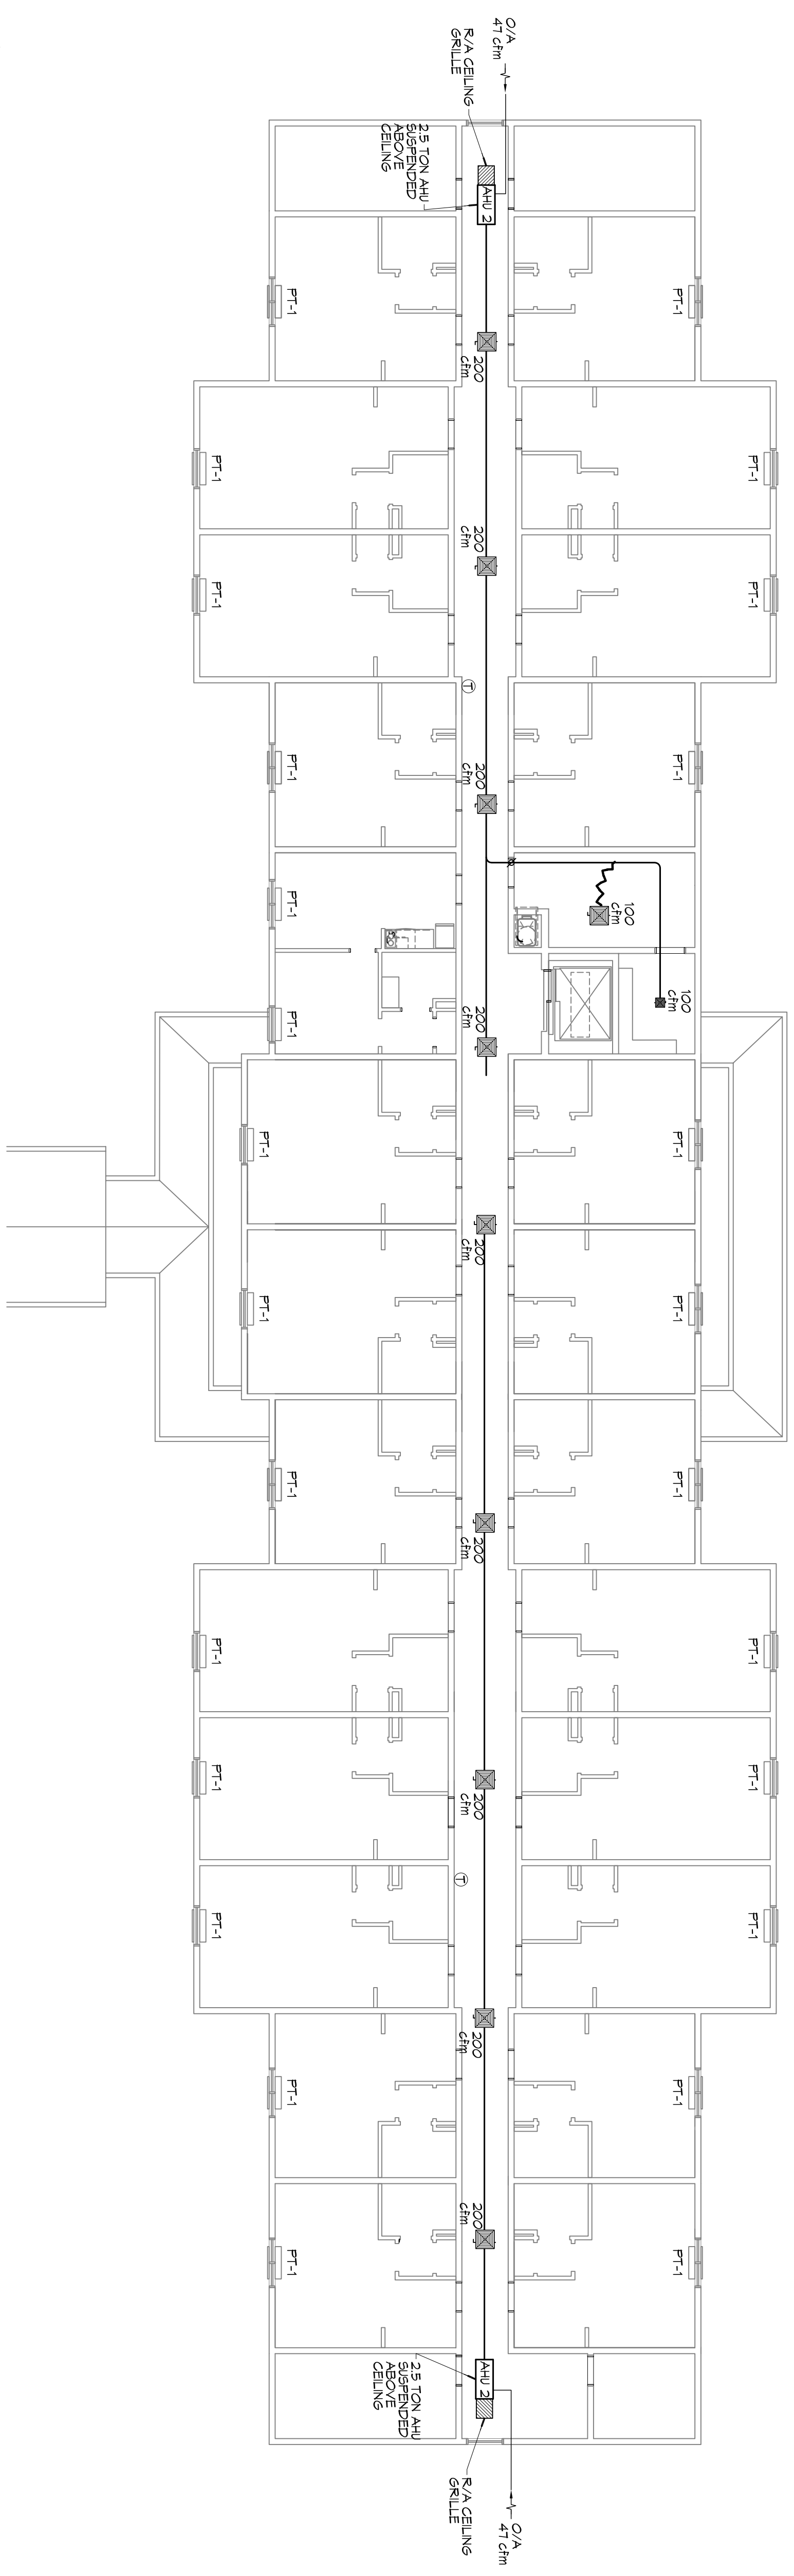

PTAC SCHEDULE									
UNIT	TOTAL BTU	CFM	OA	HEAT (KW)	VOLT	MCA	MAX O.C.F.	MFR	
PT-1 GUESTROOMS	9,000	360	36	3.5	208V, 3P	145	20	AMANA	
HALLWAY	36,000 AC	1000	47	10	208V, 3P	10	15	TRANE OR EQUAL	

MAIN STAY SUITES

100 MAIN STREET
LOT #1 LA HWY 27
HACKBERRY, LA 70645

JOB No: 2265 DATE: FEBRUARY, 2016
DRAWN BY: CKD CHECKED BY: BAM

The above drawings and specifications, design and all expressions represented thereby are the property of Dammon Engineering, Inc. and shall remain the property of Dammon Engineering, Inc. and shall not be used, reproduced or used in connection with any work or project other than the specific project for which they have been prepared and developed without written consent of Dammon Engineering, Inc. If you are not the intended recipient of this drawing or specification, please contact the sender immediately. If you are the intended recipient, please contact the sender immediately if you have any questions or concerns regarding this drawing or specification.



REVISIONS		
#	DESCRIPTION	DATE

DAMMON ENGINEERING, INC.
LOUISIANA & MISSISSIPPI

Chief Engineer: Brian Mistich, PE
554 Old Spanish Trail
Slidell, LA 70458

www.dammonengineering.com
info@dammonengineering.com
PH: 985.649.5832 F: 985.641.5950

DRAWING NUMBER:
M102

SHEET TITLE:
MECHANICAL PLANS - LEVELS 2, 3, AND 4

SHEET No: 44 of 53