


GENERAL NOTES

1. SEE GENERAL DRAWINGS FOR WIRING AND MOUNTED SMOKE DETECTOR LOCATIONS.
2. THE CONTRACTOR SHALL REFER TO ES-XX SERIES RACEWAY DRAWINGS FOR ALL RACEWAY INSTALLATIONS. THE CONTRACTOR IS RESPONSIBLE FOR ALL VOICE DATA DEVICES.


DEMOLITION NOTES

1. THE CONTRACTOR SHALL VERIFY THE SPECIFIED SCHEDULE IS MET BEFORE SUBMITTING.
2. WORK IN THE EXISTING BUILDING SHALL BE SCHEDULED WITH THE REMAINING BUILDING AND ADVANCED WITH THE OWNER'S APPROVAL. WORK SHALL BE PERFORMED AT THE DISCRETION OF THE OWNER.
3. REMOVE WIRING DEVICES, FIXTURES, COMPONENTS, AND FIXTURES FROM THE EXISTING SERVICE IN REMODELED AREAS WHEN THIS PROJECT IS COMPLETE.
4. RECONNECT CIRCUITS TO OTHER PANELBOARDS WHEN REQUIRED TO COMPLETE REMOVAL WORK.
5. REMOVE EXISTING CONDUIT AND WIRE FROM AREAS TO BE REMODELED. EXISTING CONDUIT AND WIRE FROM AREAS TO BE REMODELED SHOULD NOT BE REUSED IN AREAS NOT BEING REMODELED. CONTACT THE OWNER PRIOR TO REFORMING THIS WORK.
6. WHERE A CIRCUIT IS INTERRUPTED BY REMOVAL OF A PANEL OR CIRCUIT, THE CONTRACTOR SHALL BE RESPONSIBLE FOR THE RELOCATION OF THE CIRCUIT.
7. LIGHTING FIXTURES, WIRING DEVICES, PANELBOARDS, AND CONDUITS SHALL BE REMOVED FROM AREAS TO BE REMODELED. THE CONTRACTOR SHALL BE RESPONSIBLE FOR THE RELOCATION OF THE CIRCUIT.

THE CONTRACTOR SHOULD REFER TO ES-XX SERIES RACEWAY DRAWINGS FOR ALL RACEWAY INSTALLATIONS. THE CONTRACTOR IS RESPONSIBLE FOR ALL VOICE DATA DEVICES.

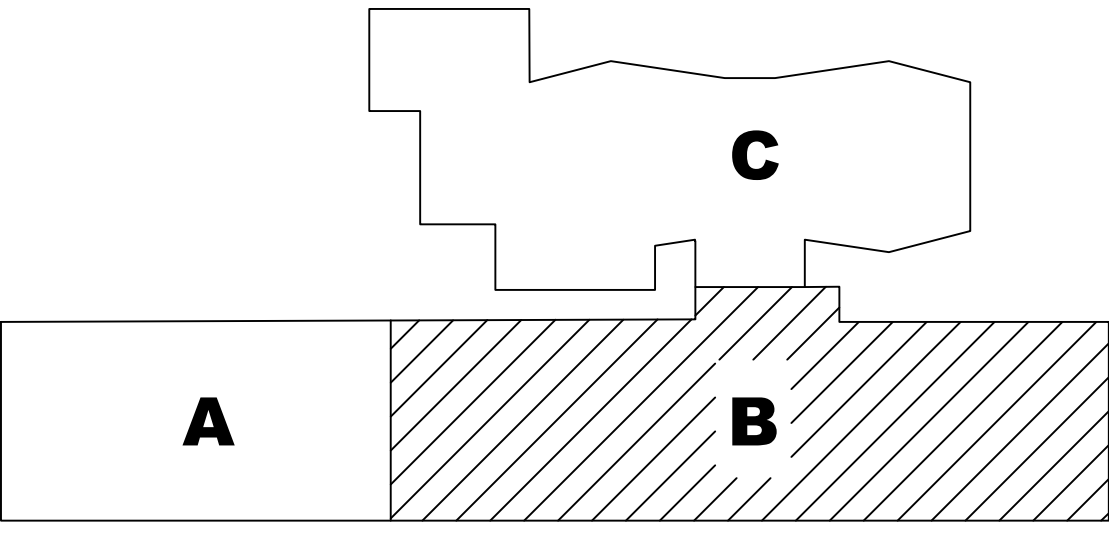

THIRD FLOOR PLAN - SYSTEMS - PART B
 E3.07 SCALE: 1/8" = 1'-00"

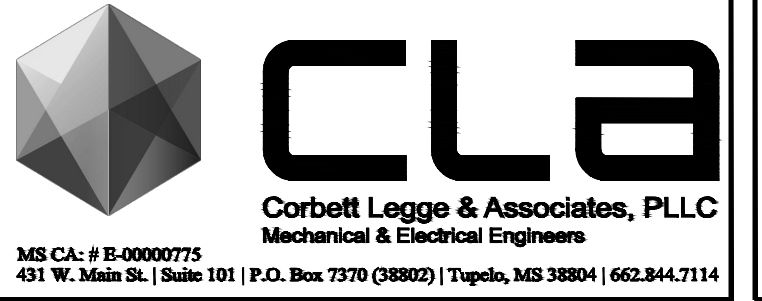

628 WASHINGTON AVENUE, SUITE C
 OCEAN SPRINGS, MS 39564
 PHONE: (228) 742-1975 FAX: (228) 749-9545
 EMAIL: CONTACT@ALLREDARCHITECTURALGROUP.COM

allred
 ARCHITECTURAL
 GROUP

THIRD FLOOR PLAN - SYSTEMS - PART B

CS# 108 2014-2017 UNIVERSITY OF SOUTHERN MISSISSIPPI
 HATTIESBURG CAMPUS

APPROVED BY	APPROVED BY	APPROVED BY
DATE	DATE	DATE
REVIEWED	REVIEWED	REVIEWED
DRAWN BY	DRAWN BY	DRAWN BY
CHECKED BY	CHECKED BY	CHECKED BY

JOB NUMBER: 2014-29
 DATE: 04-07-2017
 REVIEWED: ESW
 DRAWN BY: ESW
 CHECKED BY: JLD

SHEET

E3.07

OF SHEETS