


MECHANICAL PLAN - LEVELS 2 & 3
SCALE: 3/8"=1'-0"

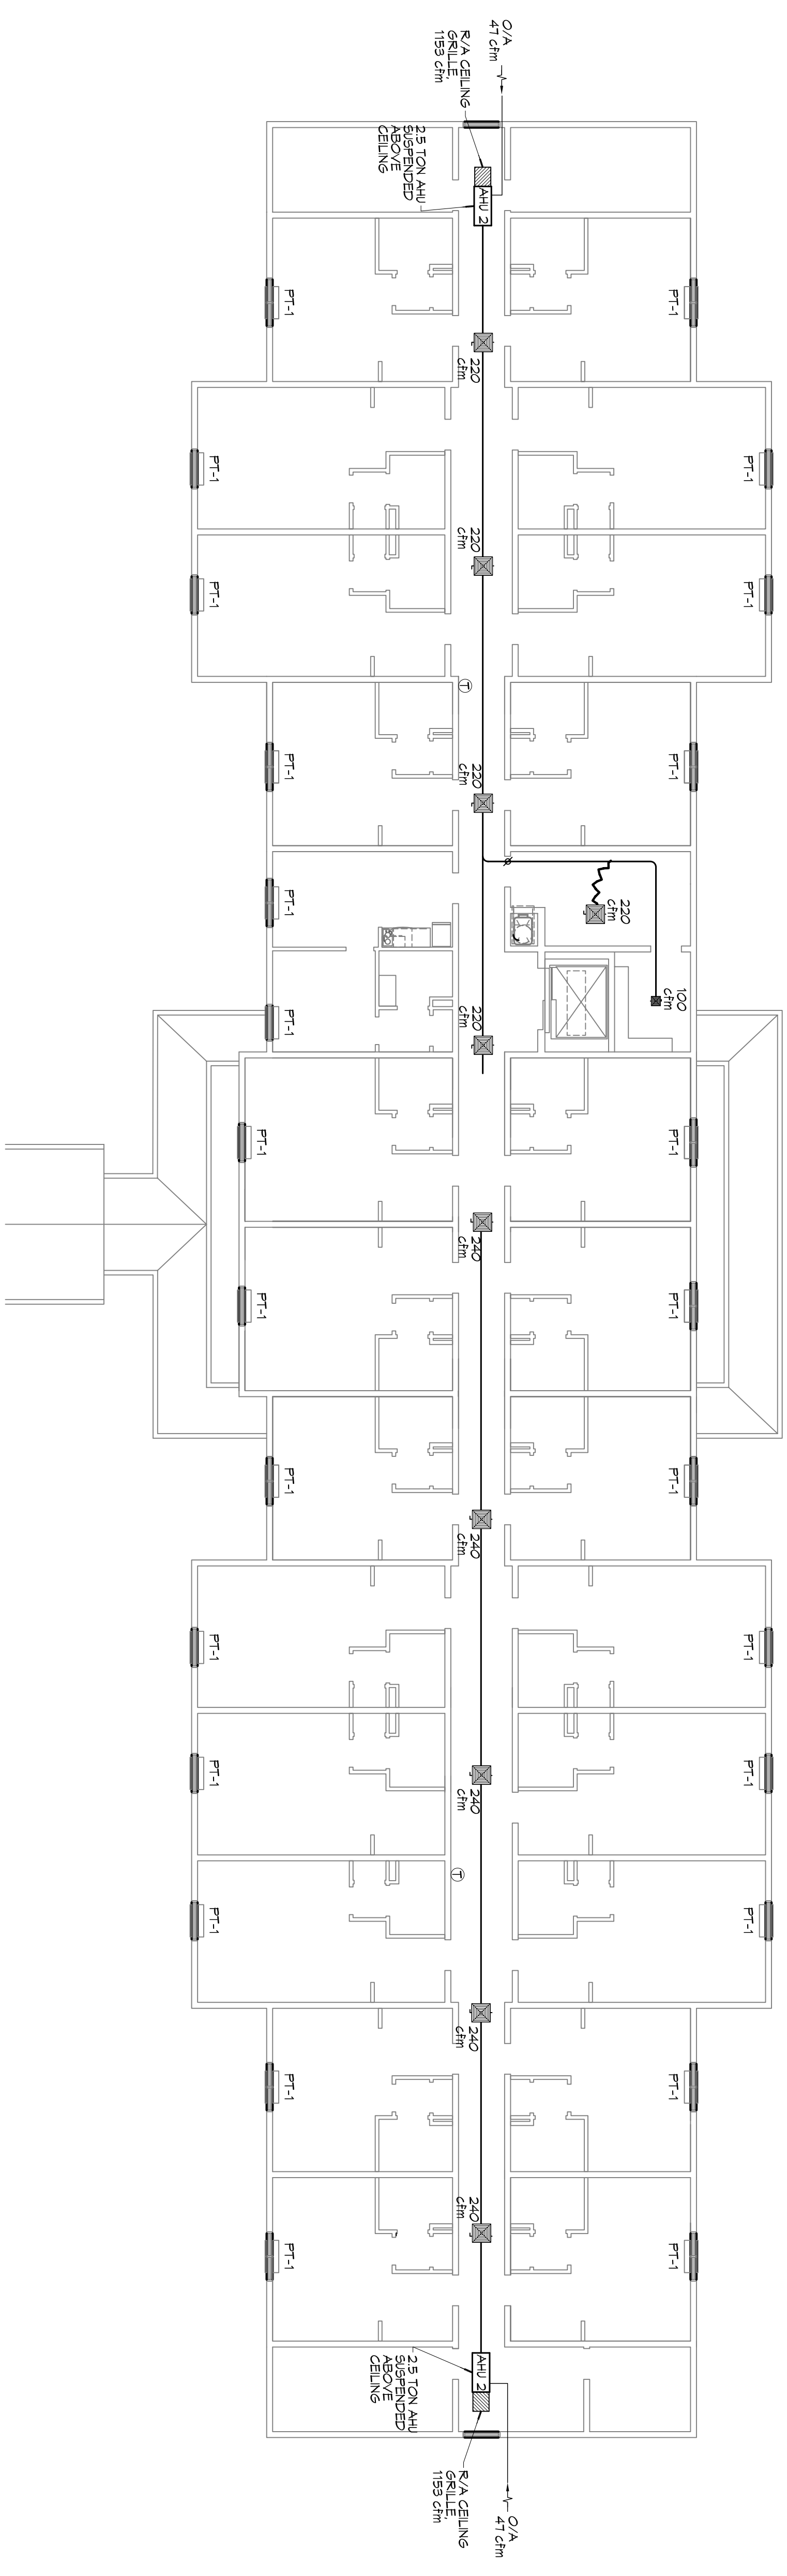

PTAC SCHEDULE									
UNIT	TOTAL BTU	CFM	OA	HEA T (KW)	ELECTRICAL VOLT	MC O.C.P.	MAX	MFR	AMANA
PT-1 (GUESTROOMS)	9,000	360	96	95	208V, 3Ø	19.5	20		

DAMMON ENGINEERING, INC.
LOUISIANA & MISSISSIPPI

Chief Engineer: Brian Mistich, PE
554 Old Spanish Trail
Slidell, LA 70458

www.dammonengineering.com
info@dammonengineering.com
PH: 985.649.5832 F: 985.641.5950

REVISIONS		DATE
#	DESCRIPTION	

MAINSTAY SUITES

LOT #1 LA HWY 21
HACKBERRY, LA 70645

JOB No: 2265 DATE: JANUARY, 2016

DRAWN BY: CKD CHECKED BY: CKD

The above drawings and specifications, except and in agreement with the notes hereon, and shall remain the property of Dammon Engineering, and no part thereof shall be copied, reproduced, or used in connection with any work or project without the express written consent of Dammon Engineering. Your contact with these drawings or specifications shall constitute your agreement to these terms and conditions.

SHEET TITLE:
MECHANICAL PLANS -
LEVELS 2, 3, AND 4

DRAWING NUMBER:

M102

SHEET No. 30 of 30