


1 DRAINAGE SITE PLAN
SCALE: 1" = 20'

GENERAL NOTES

1. DRAIN PIPES MUST BE THE BELL AND GASKET TYPE WITH 10' RINGS. ALL JOINTS SHALL BE INSPECTED WITH GEOTECHNICAL FABRIC. ALL PIPES SHALL REQUIRE A 3" COMPACTED SAND OR LIMESTONE BASE.
2. REMOVE DEBRIS AND CLEAN BOTTOM OF DITCHES DOWN 6" IN DEPTH. REPLACE ANY BROKEN/CRUSHED PIPES OR CURBVERTS WITH SAME SIZE AND TYPE.
3. DRAIN PIPE AND FITTINGS WITHIN PROPERTY LINE SHALL BE POLYVINTL. CHLORIDE PLASTIC PIPE MEETING CLASS 100 C-900 PVC.
4. ELEVATIONS SHOWN ARE MSL.
5. FIELD VERIFY ALL ELEVATIONS AND DRAINAGE SYSTEM PLACEMENT PRIOR TO START OF WORK.
6. PROVIDE VERTICAL ELBOW AT DOWNSPOUTS FOR CONNECTION TO SUBSURFACE DRAINAGE WHERE INDICATED. ELBOW ID SHALL BE SIZED SUCH THAT THE DOWNSPOUT CAN BE INSERTED INTO THE PIPE OPENING WITHOUT DEFORMATION TO THE DOWNSPOUT.

SITE DRAINAGE LEGEND

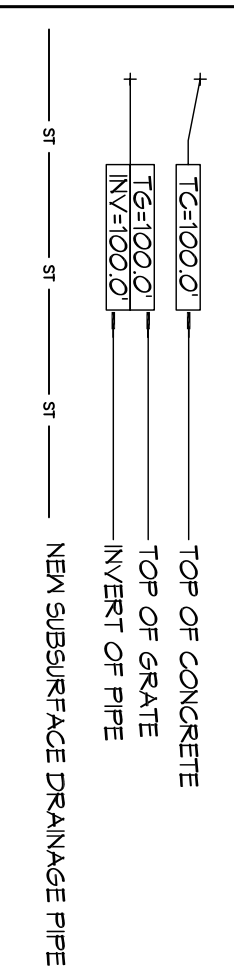

DAMMON ENGINEERING, INC.
LOUISIANA & MISSISSIPPI

Chief Engineer: Brian Mistich, PE
554 Old Spanish Trail
Slidell, LA 70458

www.dammonengineering.com
info@dammonengineering.com
PH: 985.649.5832 F: 985.641.5950

REVISIONS	DATE	DESCRIPTION



MAINSTAY SUITES

100 MAIN STREET
LOT #1 LA HWY 27
HACKBERRY, LA 70645

JOB No: 2265 DATE: FEBRUARY, 2016

DRAWN BY: KHM CHECKED BY: BAM

SHEET TITLE:
DRAINAGE SITE PLAN

DRAWING NUMBER:
C104

SHEET NO.: 9 OF 32