



NOTE: EACH WATER HEATER SHALL HAVE A CONTROLLER, FURNISHED WITH UNIT. (SCHEMATIC FURNISHED BY HEATER MANUFACTURER). CONNECT CONTROLS PER MANUFACTURERS INSTRUCTIONS.


8 MAIN WATER HEATER RISER DIAGRAM
SCALE: N.T.S.

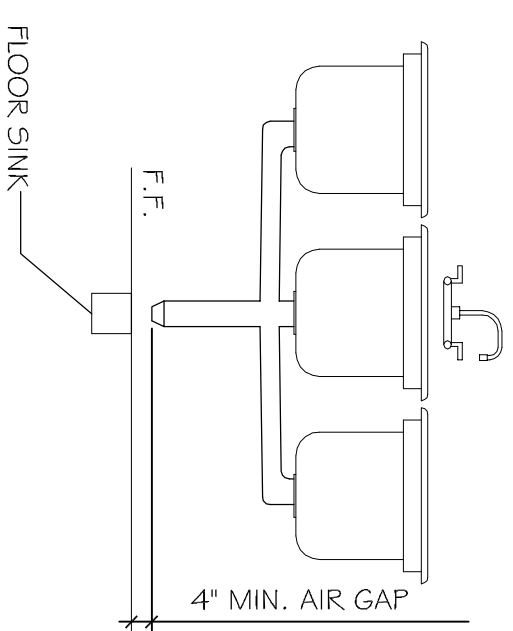


7 FLOOR SINK DETAIL
SCALE: N.T.S.

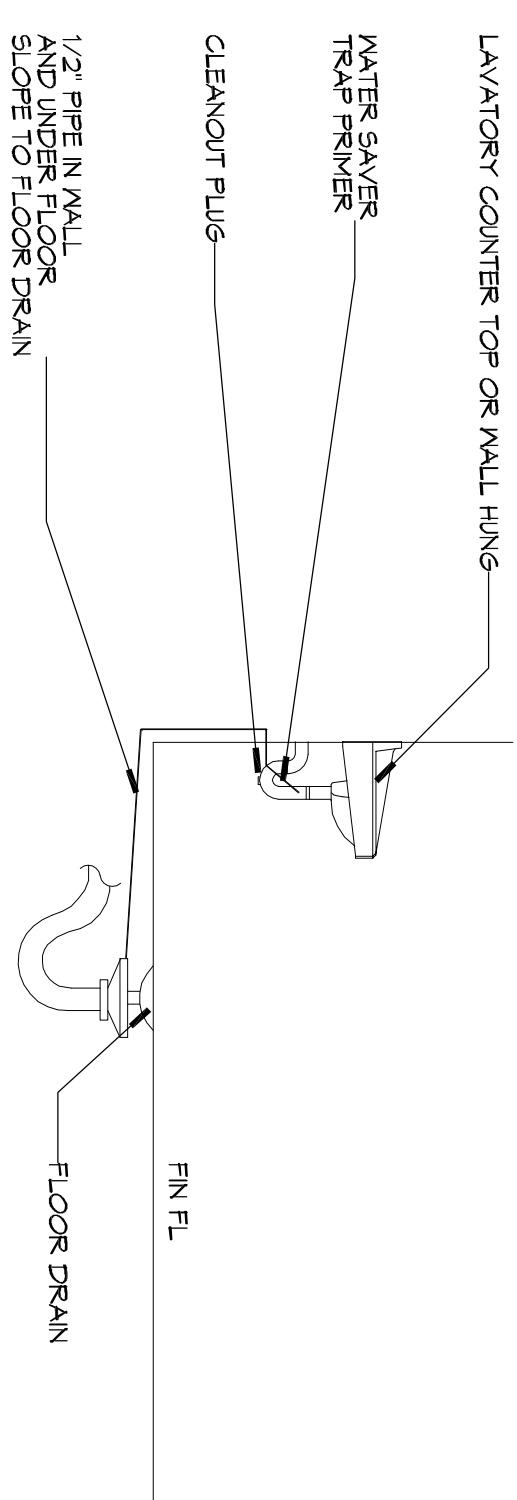


4 TYPICAL FLOOR DRAIN DETAIL
SCALE: N.T.S.

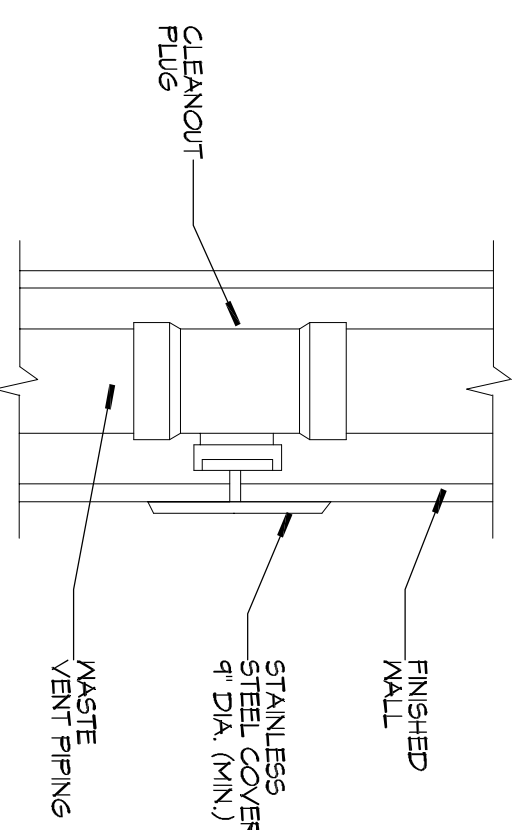


3 WALL CLEANOUT DETAIL
SCALE: N.T.S.

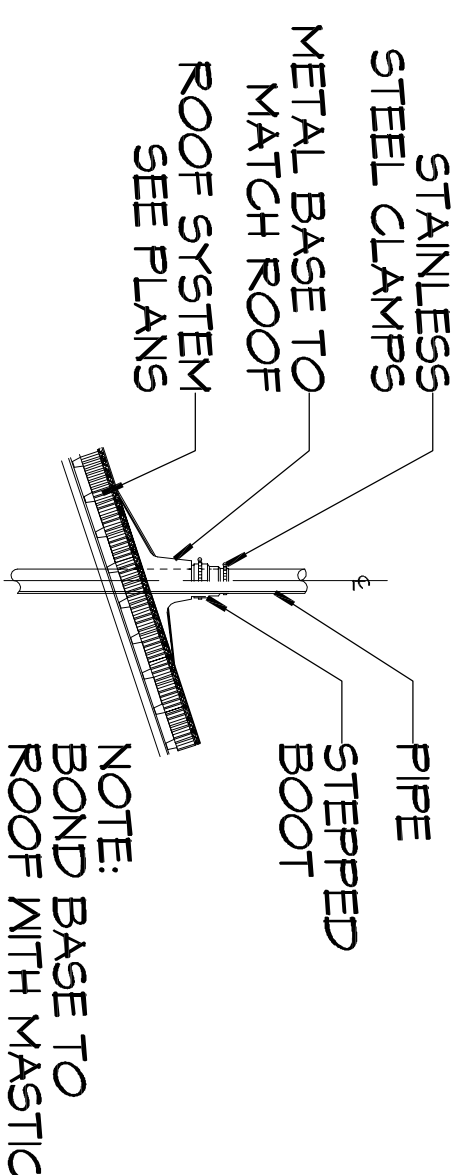


9 WALL CLEANOUT DETAIL
SCALE: N.T.S.

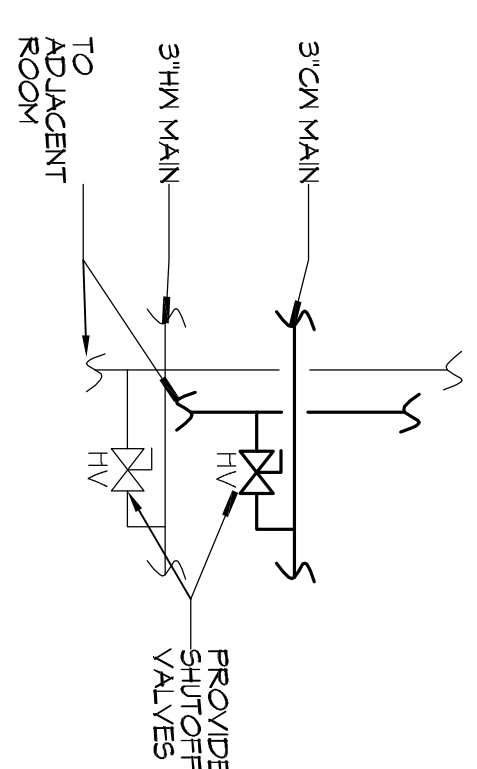


6 TYPICAL SUITE SHUTOFF VALVE
SCALE: N.T.S.

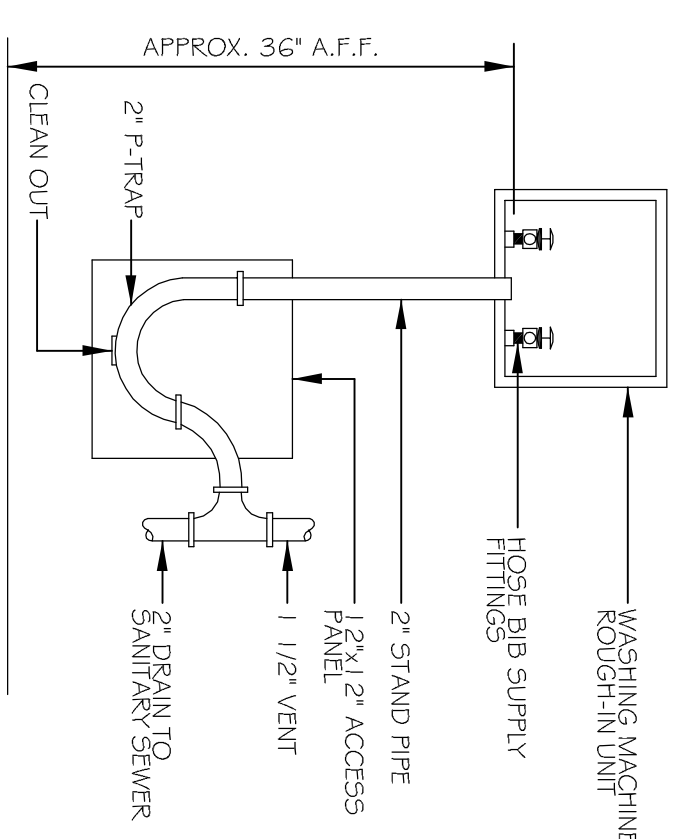

5 WASHING MACHINE HOOK-UP (GUEST LAUNDRY)
SCALE: N.T.S.

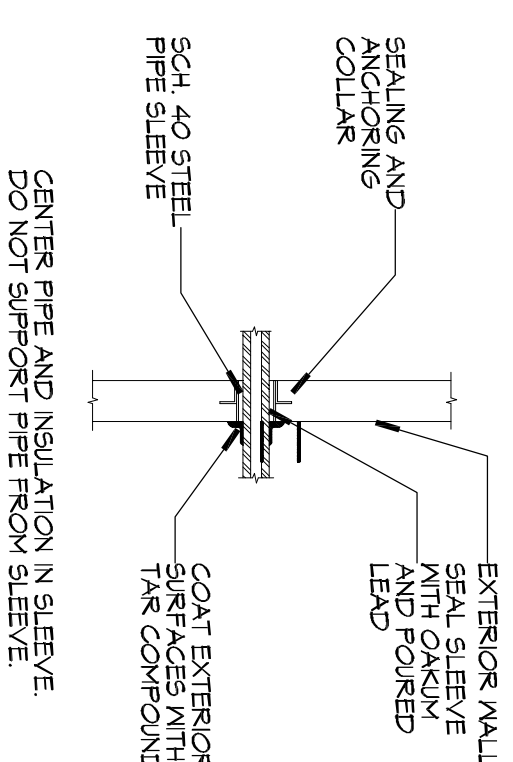

2 EXTERIOR WALL SLEEVE DETAIL
SCALE: N.T.S.

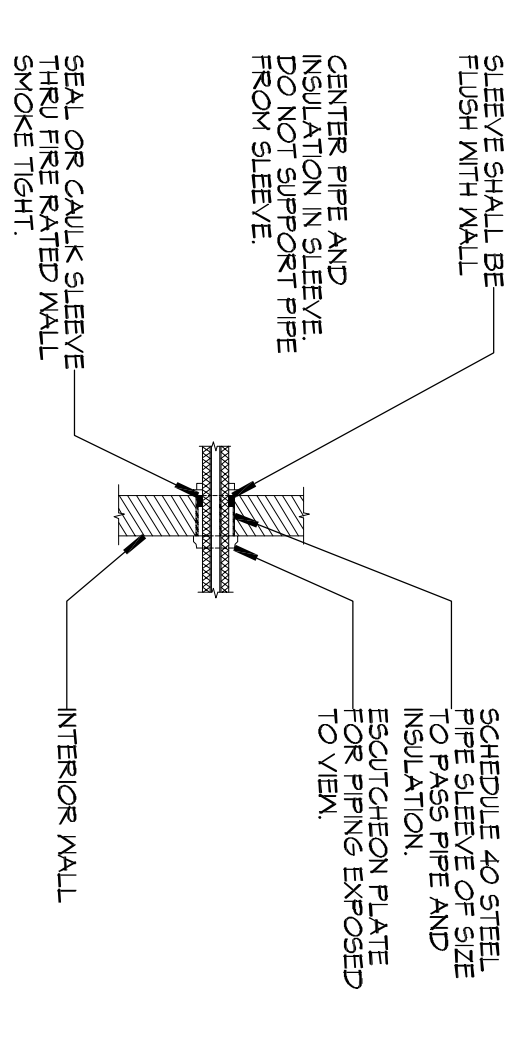

1 TYPICAL INTERIOR WALL SLEEVE DETAIL
SCALE: N.T.S.

REVISIONS		DATE
#	DESCRIPTION	



MAIN STAY SUITES

100 MAIN STREET
LOT #1 LA HWY 27
HACKBERRY, LA 70645

JOB No: 2265 DATE: APRIL, 2016
DRAWN BY: CKD/JTL CHECKED BY: BAM

SHEET TITLE:
PLUMBING SCHEDULES AND DETAILS

DRAWING NUMBER:

P103