

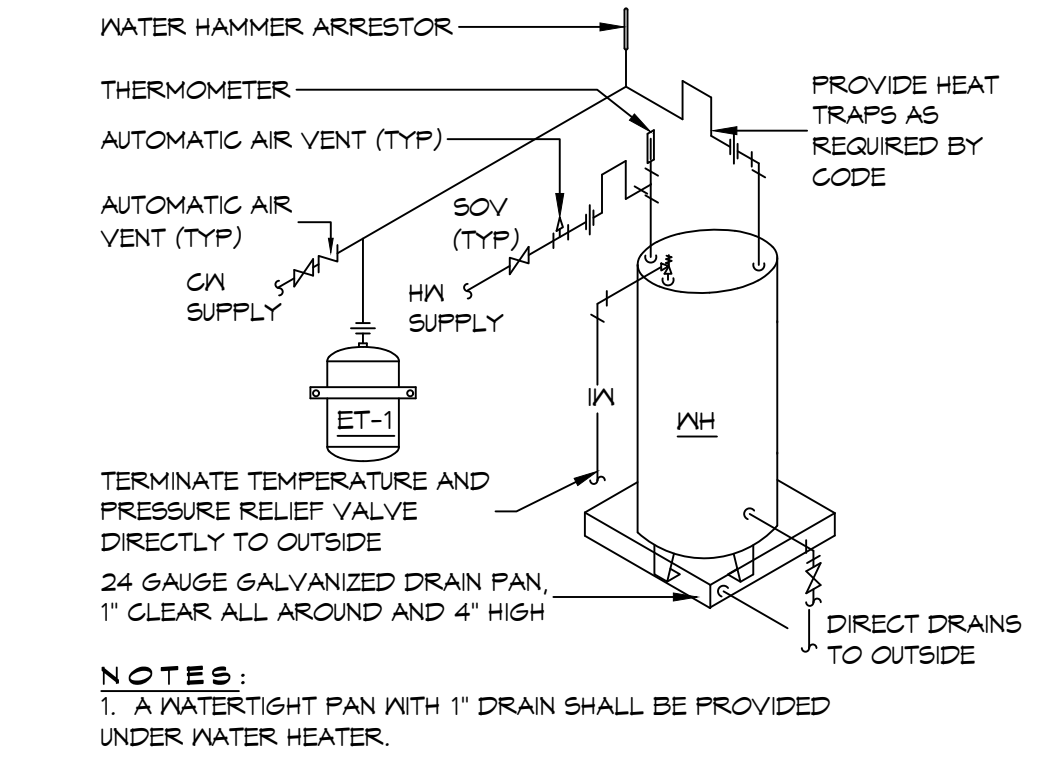
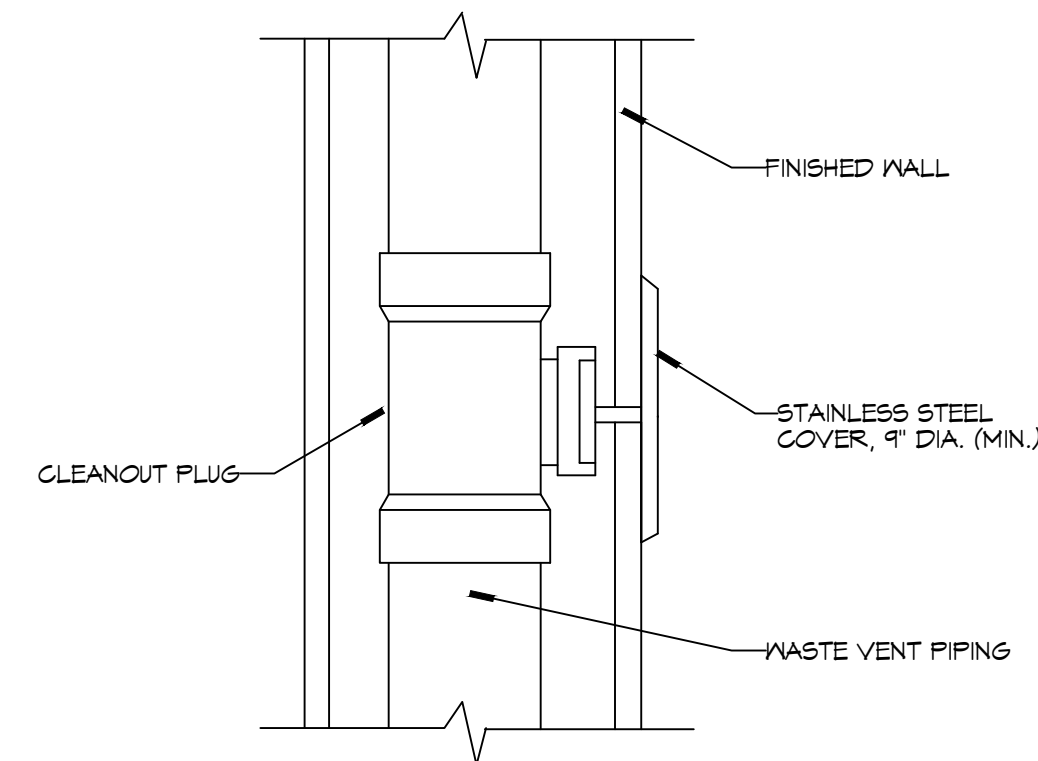



23 PLUMBING PLAN
 SCALE: 3/8" = 1'-0"
 24 PLUMBING RISER
 SCALE: N.T.S.
 25 PLUMBING LEGEND
 26 PLUMBING NOTES
 27 PLUMBING LEGEND
 28 PLUMBING NOTES
 29 PLUMBING LEGEND
 30 PLUMBING NOTES
 31 PLUMBING LEGEND
 32 PLUMBING NOTES
 33 PLUMBING LEGEND
 34 PLUMBING NOTES
 35 PLUMBING LEGEND
 36 PLUMBING NOTES
 37 PLUMBING LEGEND
 38 PLUMBING NOTES
 39 PLUMBING LEGEND
 40 PLUMBING NOTES
 41 PLUMBING LEGEND
 42 PLUMBING NOTES
 43 PLUMBING LEGEND
 44 PLUMBING NOTES
 45 PLUMBING LEGEND
 46 PLUMBING NOTES
 47 PLUMBING LEGEND
 48 PLUMBING NOTES
 49 PLUMBING LEGEND
 50 PLUMBING NOTES
 51 PLUMBING LEGEND
 52 PLUMBING NOTES
 53 PLUMBING LEGEND
 54 PLUMBING NOTES
 55 PLUMBING LEGEND
 56 PLUMBING NOTES
 57 PLUMBING LEGEND
 58 PLUMBING NOTES
 59 PLUMBING LEGEND
 60 PLUMBING NOTES
 61 PLUMBING LEGEND
 62 PLUMBING NOTES
 63 PLUMBING LEGEND
 64 PLUMBING NOTES
 65 PLUMBING LEGEND
 66 PLUMBING NOTES
 67 PLUMBING LEGEND
 68 PLUMBING NOTES
 69 PLUMBING LEGEND
 70 PLUMBING NOTES
 71 PLUMBING LEGEND
 72 PLUMBING NOTES
 73 PLUMBING LEGEND
 74 PLUMBING NOTES
 75 PLUMBING LEGEND
 76 PLUMBING NOTES
 77 PLUMBING LEGEND
 78 PLUMBING NOTES
 79 PLUMBING LEGEND
 80 PLUMBING NOTES
 81 PLUMBING LEGEND
 82 PLUMBING NOTES
 83 PLUMBING LEGEND
 84 PLUMBING NOTES
 85 PLUMBING LEGEND
 86 PLUMBING NOTES
 87 PLUMBING LEGEND
 88 PLUMBING NOTES
 89 PLUMBING LEGEND
 90 PLUMBING NOTES
 91 PLUMBING LEGEND
 92 PLUMBING NOTES
 93 PLUMBING LEGEND
 94 PLUMBING NOTES
 95 PLUMBING LEGEND
 96 PLUMBING NOTES
 97 PLUMBING LEGEND
 98 PLUMBING NOTES
 99 PLUMBING LEGEND
 100 PLUMBING NOTES

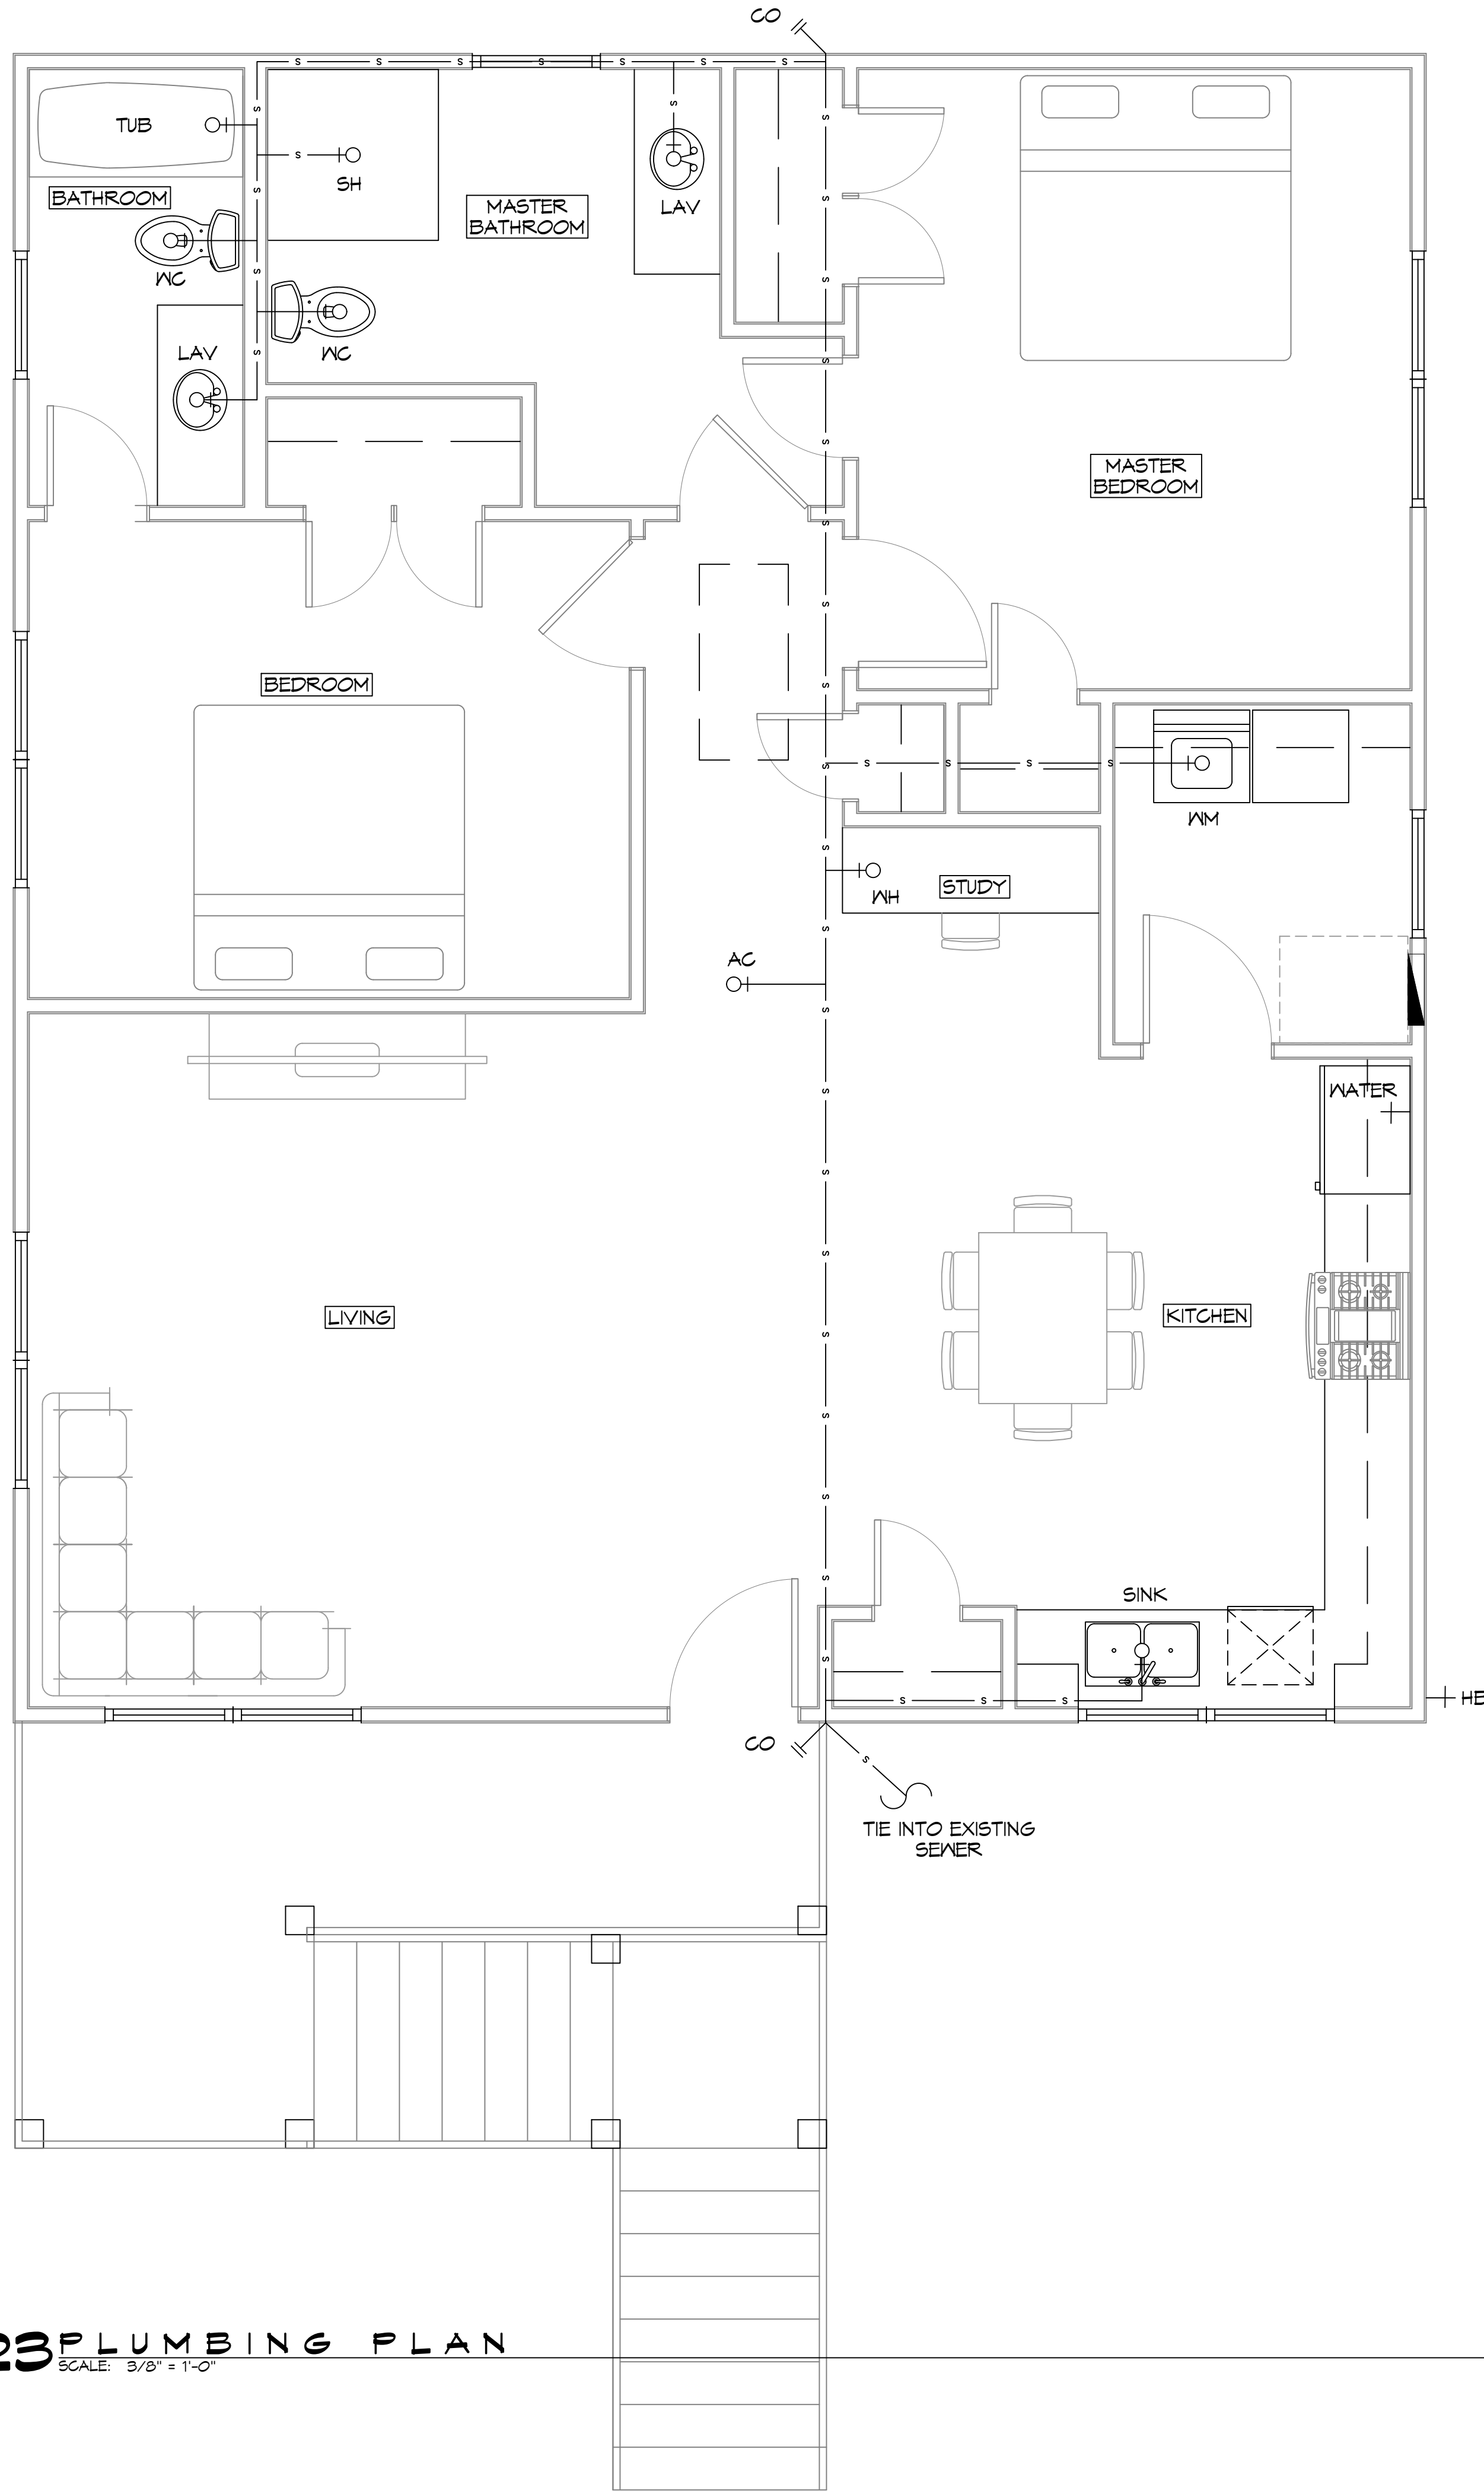

TYPICAL DETAILS
 SCALE: N.T.S.

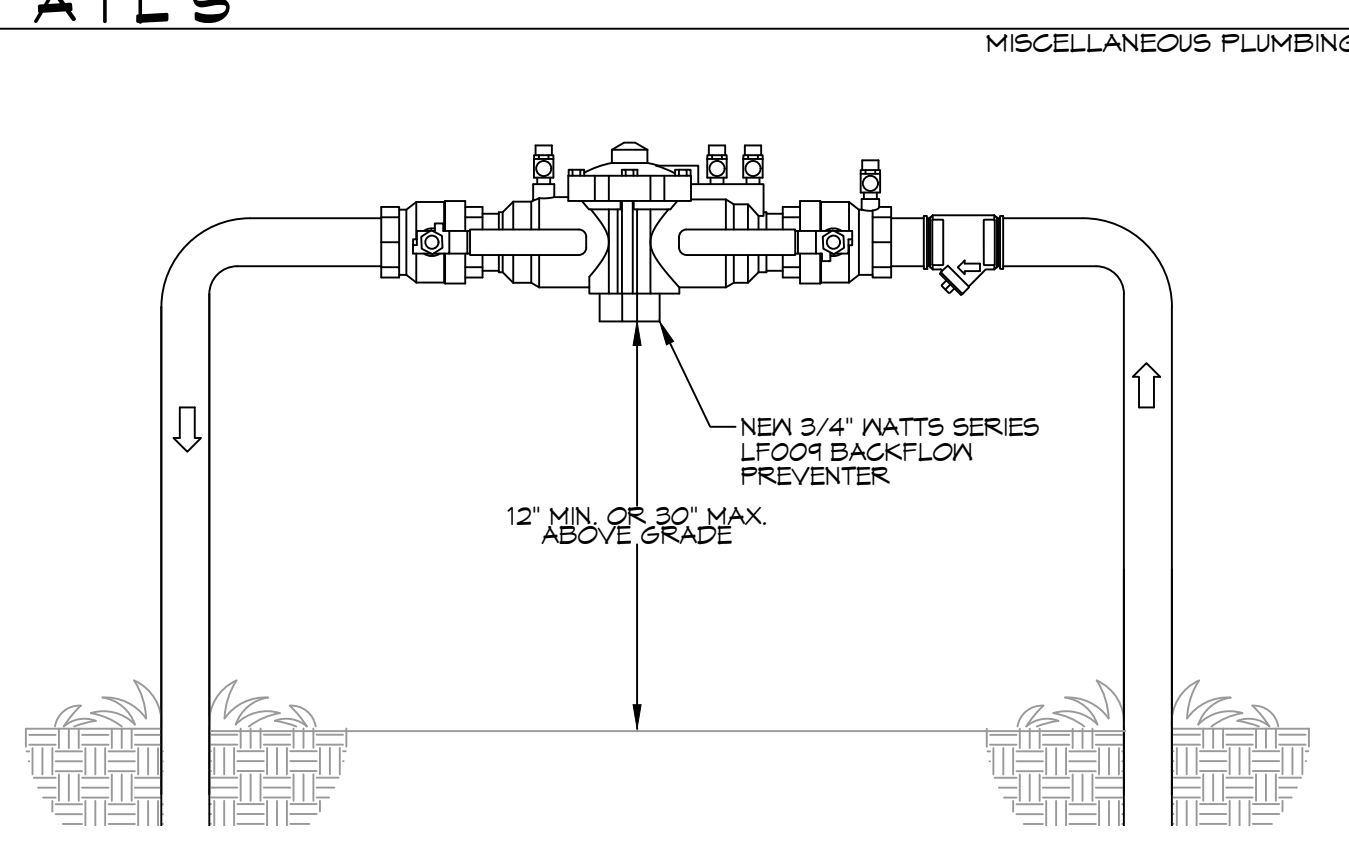

TYPICAL BACKFLOW DETAIL
 SCALE: N.T.S.

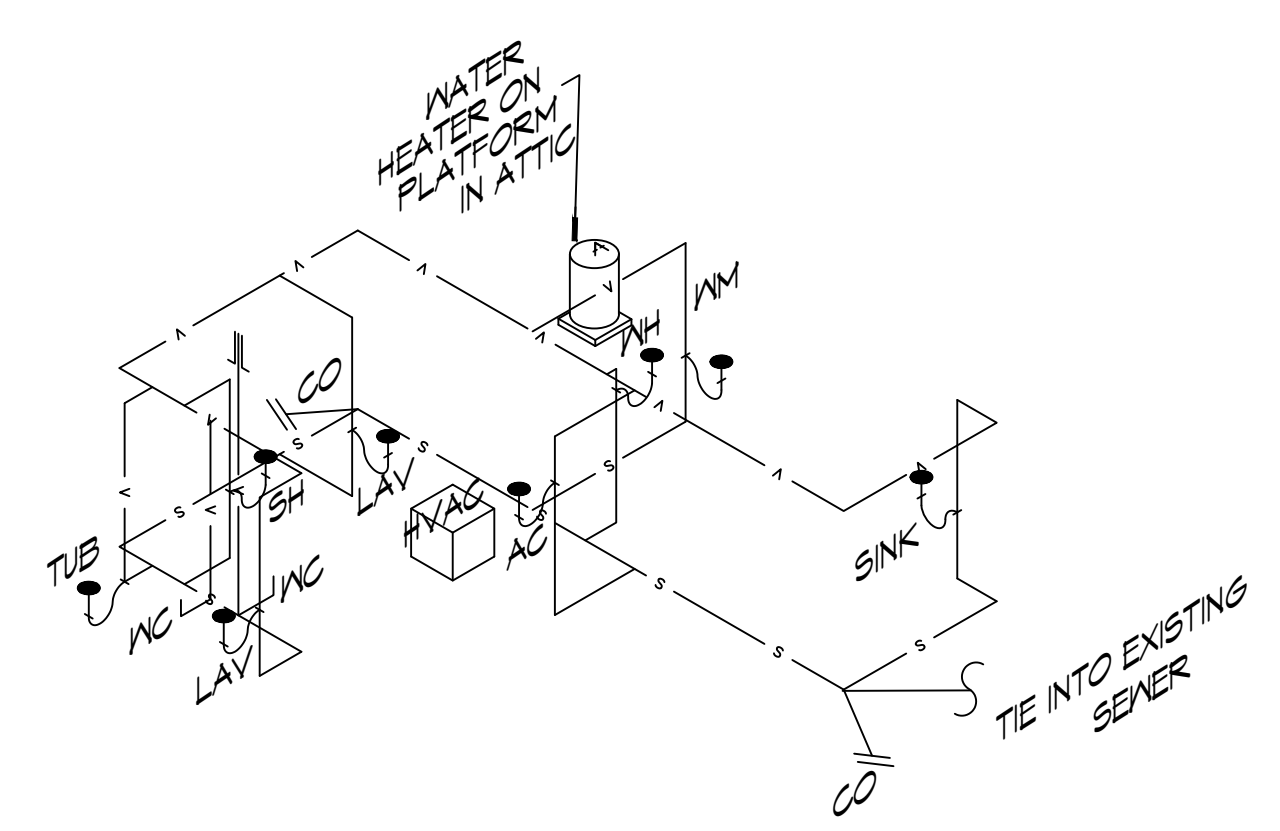

24 PLUMBING RISER
 SCALE: N.T.S.

PLUMBING NOTES

1. PLUMBING LINES SHOWN ARE DRAWN DIAGRAMMATIC IN NATURE AND REPRESENT CONCEPTUAL ROUTING ONLY. CONTRACTOR IS RESPONSIBLE FOR FIELD VERIFICATION OF ALL ACTUAL CONDITIONS.
2. PROVIDE ALL LABOR, MATERIAL, TRANSPORTATION, SUPERVISION, CLEAN-UP, SERVICES, AND EQUIPMENT FOR A COMPLETE OPERATING SYSTEM. THE SYSTEM SHALL INCLUDE HOT AND COLD WATER PIPING, SEWER AND VENT PIPING, INSULATION, WATER HEATER, HANGERS, VALVES, SUPPORTS WITHOUT ANY RESTRICTIONS TO VOLUME. CUT AND PATCH AS REQUIRED TO INSTALL PIPES.
3. ALL WORK AND MATERIAL SHALL CONFORM STRICTLY TO THE LATEST LOCAL CITY, PARISH, STATE AND NATIONAL GOVERNING CODES. MUST MEET LA STATE PLUMBING CODE 2013 REQUIREMENTS.
4. CONTRACTOR IS TO FIELD VERIFY ALL EXISTING UTILITY LOCATIONS, ELEVATIONS AND SIZES PRIOR TO COMMENCING ANY WORK. CONTRACTOR SHALL PAY NECESSARY FEES FOR THE UTILITIES CONNECTIONS.
5. CONTRACTOR IS RESPONSIBLE TO VERIFY THE EXISTING INVERTS AND SET NEW INVERTS OF SEWERAGE AND DRAINAGE PIPES.
6. SEWERAGE LINES 3-INCH AND SMALLER SHALL BE SLOPED 1/4" PER FOOT AND LINES 4-INCH AND LARGER SHALL BE 1/8" PER FOOT.
7. TEST ALL PIPING AT REQUIRED PRESSURE.
8. ALL PLUMBING SHALL BE CLOSELY COORDINATED WITH STRUCTURAL, MECHANICAL SYSTEM AND ELECTRICAL SYSTEMS TO INSURE NO TRADES WILL CONFLICT WITH EACH OTHER.
9. DO NOT SCALE DRAWINGS. SEE ARCHITECTURAL DRAWINGS FOR EXACT LOCATIONS OF DOORS, WINDOWS, WALLS, FIXTURES, ETC.
10. ALL WATER MAINS AND PIPING NOT SHOWN FOR CLARITY, ALL LOCATIONS FIELD VERIFIED.
11. DOMESTIC HOT AND COLD WATER PIPING AND FITTINGS UNDER SLAB SHALL BE ASTM B88 COPPER WATER TUBE, TYPE K, SOFT ANNEALED. NO JOINTS SHALL BE ALLOWED UNDER THE SLAB.
12. DOMESTIC WATER PIPING AND FITTINGS ABOVE THE SLAB SHALL BE ASTM B88 COPPER WATER TUBE, TYPE L, HARD DRAWN WITH COPPER PRESSURE TYPE FITTINGS, ANSI B16.22. THE JOINTS SHALL BE SOLDERED TYPE USING ASTM B32, ALLOY GRADE 95A (95-5) SOLDER OR PEX PIPING.
13. SOIL, WASTE, VENT PIPING AND FITTINGS ABOVE THE SLAB SHALL BE SERVICE WEIGHT CAST IRON PIPE WITH BELL AND SPIGOT ENDS AND ONE PIECE NEOPRENE INSERT TYPE GASKET. USE PVC SCHEDULE 40 OR ABS DWV PIPES AND FITTINGS WHERE PERMITTED BY CODE.
14. ALL WATER PIPING AND FITTINGS ABOVE THE FLOOR SHALL BE INSULATED WITH 1/2" THICK FIBERGLASS INSULATION AND JACKET.
15. ALL VENTS THROUGH ROOF (VTR) SHALL BE LOCATED A MINIMUM OF 10'-0" FROM ANY MECHANICAL OR NATURAL AIR INTAKE.

PLUMBING LEGEND

WM	WASHER MACHINE
WC	WATER CLOSET
2CS	TWO COMPARTMENT SINK
SH	SHOWER/BATH
WH	WATER HEATER
VTR	VENT THRU ROOF
LAV	LAVATORY
HB	HOSE BIB
+O	P-TRAP
CO	CLEANOUT

23 PLUMBING PLAN
 SCALE: 3/8" = 1'-0"

DAMMON ENGINEERING, INC.
 LOUISIANA & MISSISSIPPI
 Chief Engineer: Brian Mitchell, PE
 554 Old Spanish Trail
 Slidell, LA 70458
 www.dammonengineering.com
 info@dammonengineering.com
 PH: 985.649.5832

#	DESCRIPTION	DATE

BOBBY HARRISON
 3030 CAREY DRIVE
 SLIDELL, LOUISIANA
 70458
 JOB No: 09-16-2026
 DRAWN BY: CKD
 CHECKED BY: BAH

SHEET TITLE:
PLUMBING PLAN AND RISER
 DRAWING NUMBER:
P101
 SHEET No: 9 of 11