


DRAINAGE NOTES

- CONTRACTOR SHALL PROVIDE ALL LABOR, MATERIAL, TRANSPORTATION, SUPERVISION, CLEAN-UP, SERVICES, AND EQUIPMENT FOR A COMPLETE OPERATING SYSTEM.
- PROVIDE POSITIVE DRAINAGE AWAY FROM BLDG AND SHALL SLOPE TOWARDS EXISTING DITCHES AND CULVERTS.


DRAINAGE LEGEND

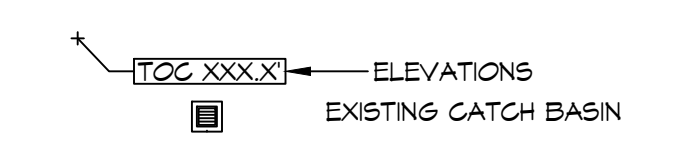

GENERAL SITE NOTES

- PROVIDE ALL LABOR, MATERIAL AND EQUIPMENT FOR A COMPLETE OPERATING SYSTEM. CONTRACTOR IS TO FIELD VERIFY ALL EXISTING UTILITY LOCATIONS, ELEVATIONS, AND INVERTS PRIOR TO COMMENCING ANY WORK. CONTRACTOR SHALL PAY NECESSARY FEES FOR THE UTILITIES CONNECTIONS.
- CONTRACTOR TO BE RESPONSIBLE TO VERIFY ANY INVERTS AND SET NEW INVERTS OF SEWAGE AND DRAINAGE PIPES.
- ALL WORK AND MATERIAL TO COMPLY STRICTLY TO THE LATEST LOCAL CITY PARISH, STATE, AND NATIONAL GOVERNING CODES.
- SEWAGE LINES 3\"/>

SITE UTILITIES LEGEND

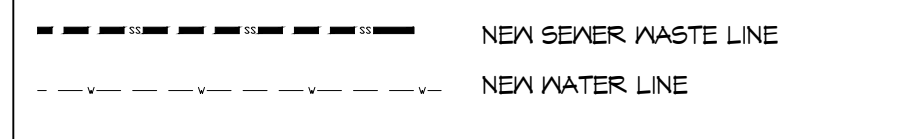

NOTE:
ALL PLUMBING IS DRAWN
DIAGRAMMATICALLY FOR
CLARITY

DAMMON ENGINEERING, INC.
LOUISIANA & MISSISSIPPI
www.dammonengineering.com
info@dammonengineering.com
Chief Engineer: Brian Mistich, PE
554 Old Spanish Trail
Slidell, LA 70468
PH: 985.649.3532

#	DESCRIPTION	DATE

SEAL:

NEW TRAINING FACILITY
ST. TAMMANY FIRE PROTECTION DISTRICT NO. 1
 94180 S RANGE ROAD
 SLIDELL, LA 70460
 JOB No: 25071 DATE: 12-18-2024
 DRAWN BY: BAW
 C&D CHECKED BY: BAW

SHEET TITLE:
DRAINAGE & UTILITY SITE PLAN

DRAWING NUMBER:
C102
 SHEET No: 4 of 15

DRAINAGE & UTILITY SITE PLAN
 SCALE: 1" = 10'-0"