




PAVING DETAILS

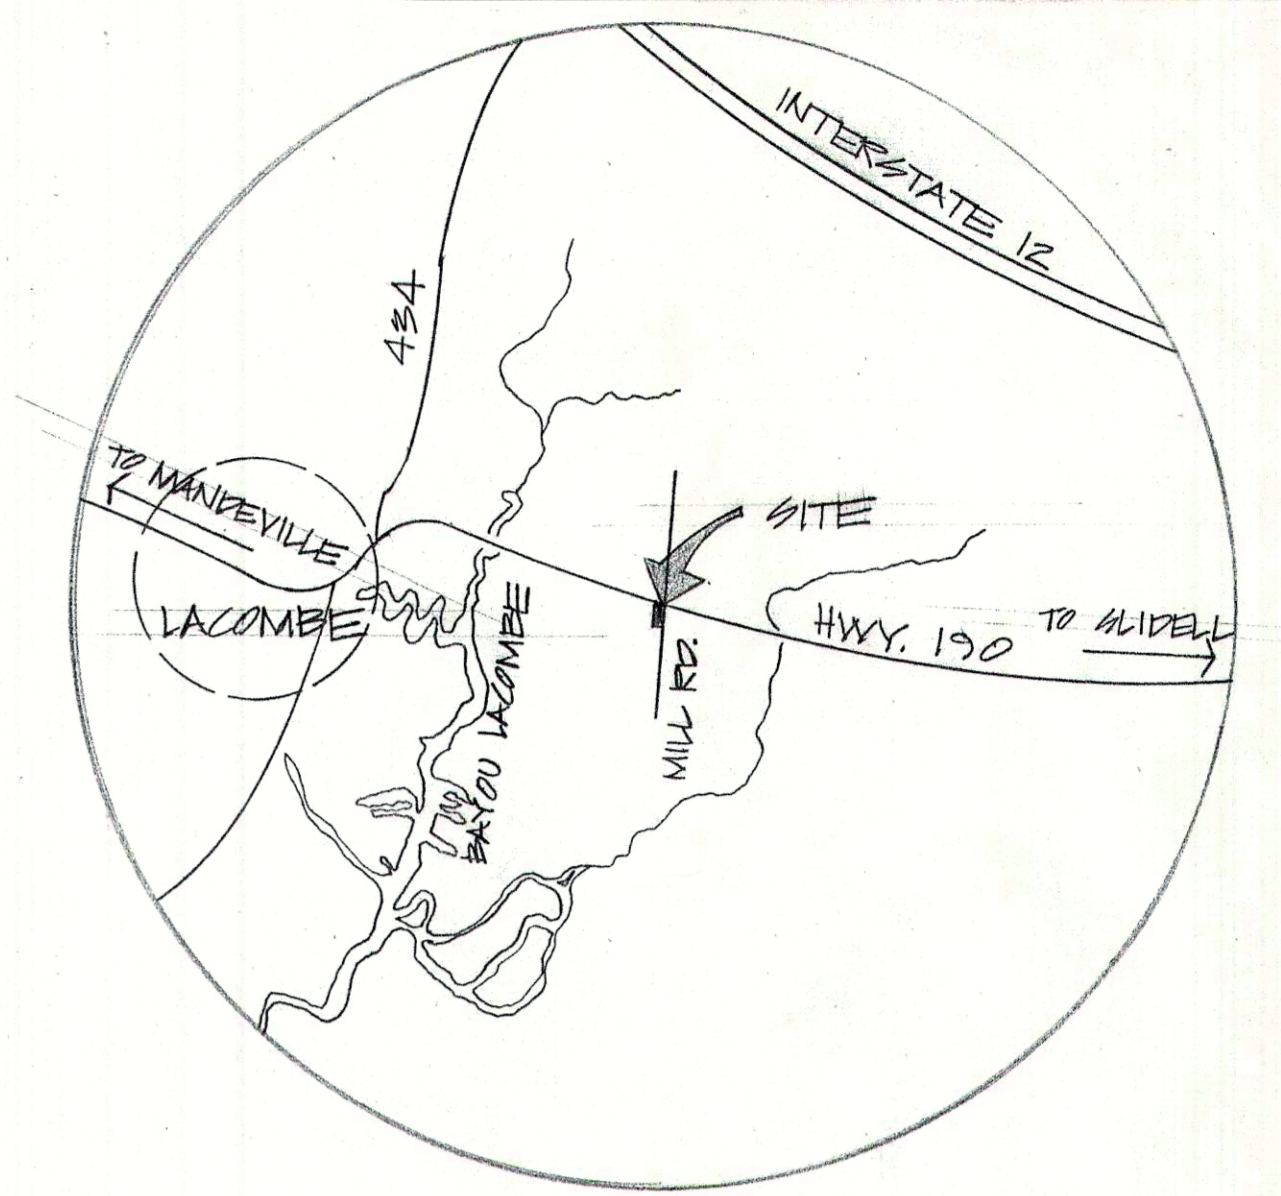

VICINITY MAP

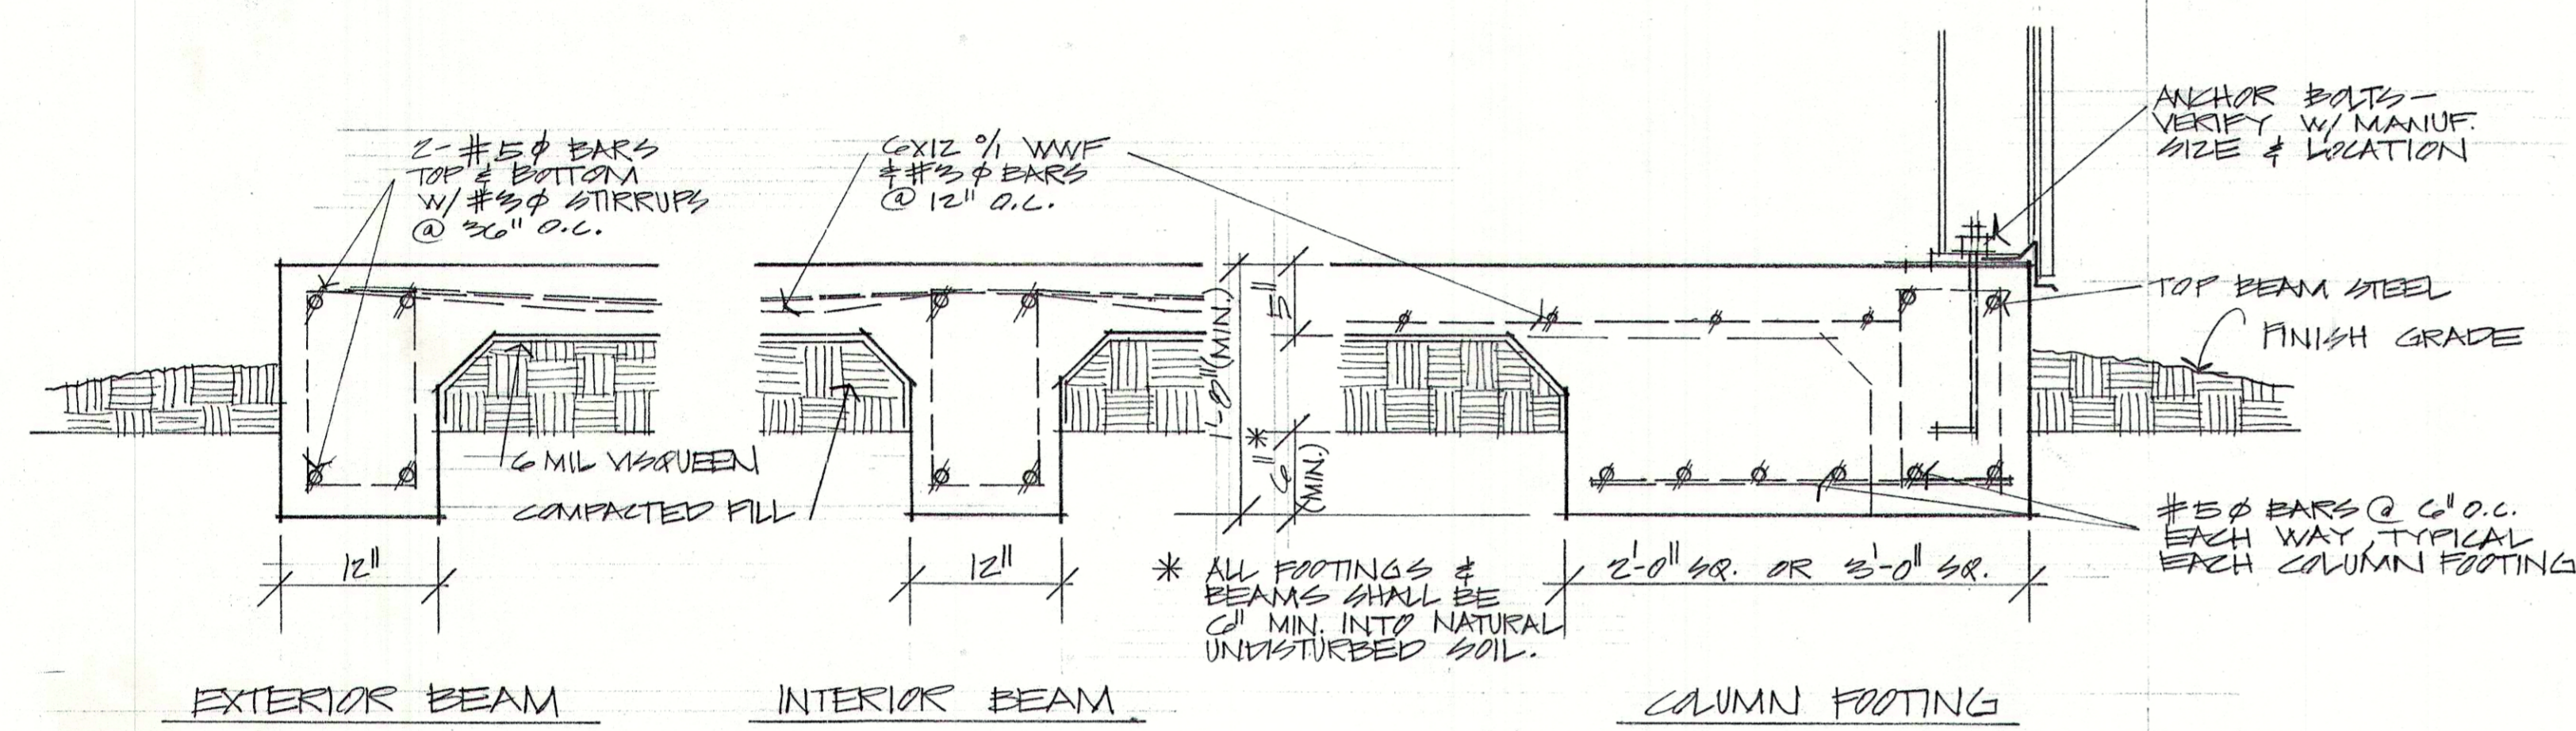


FOUNDATION DETAILS

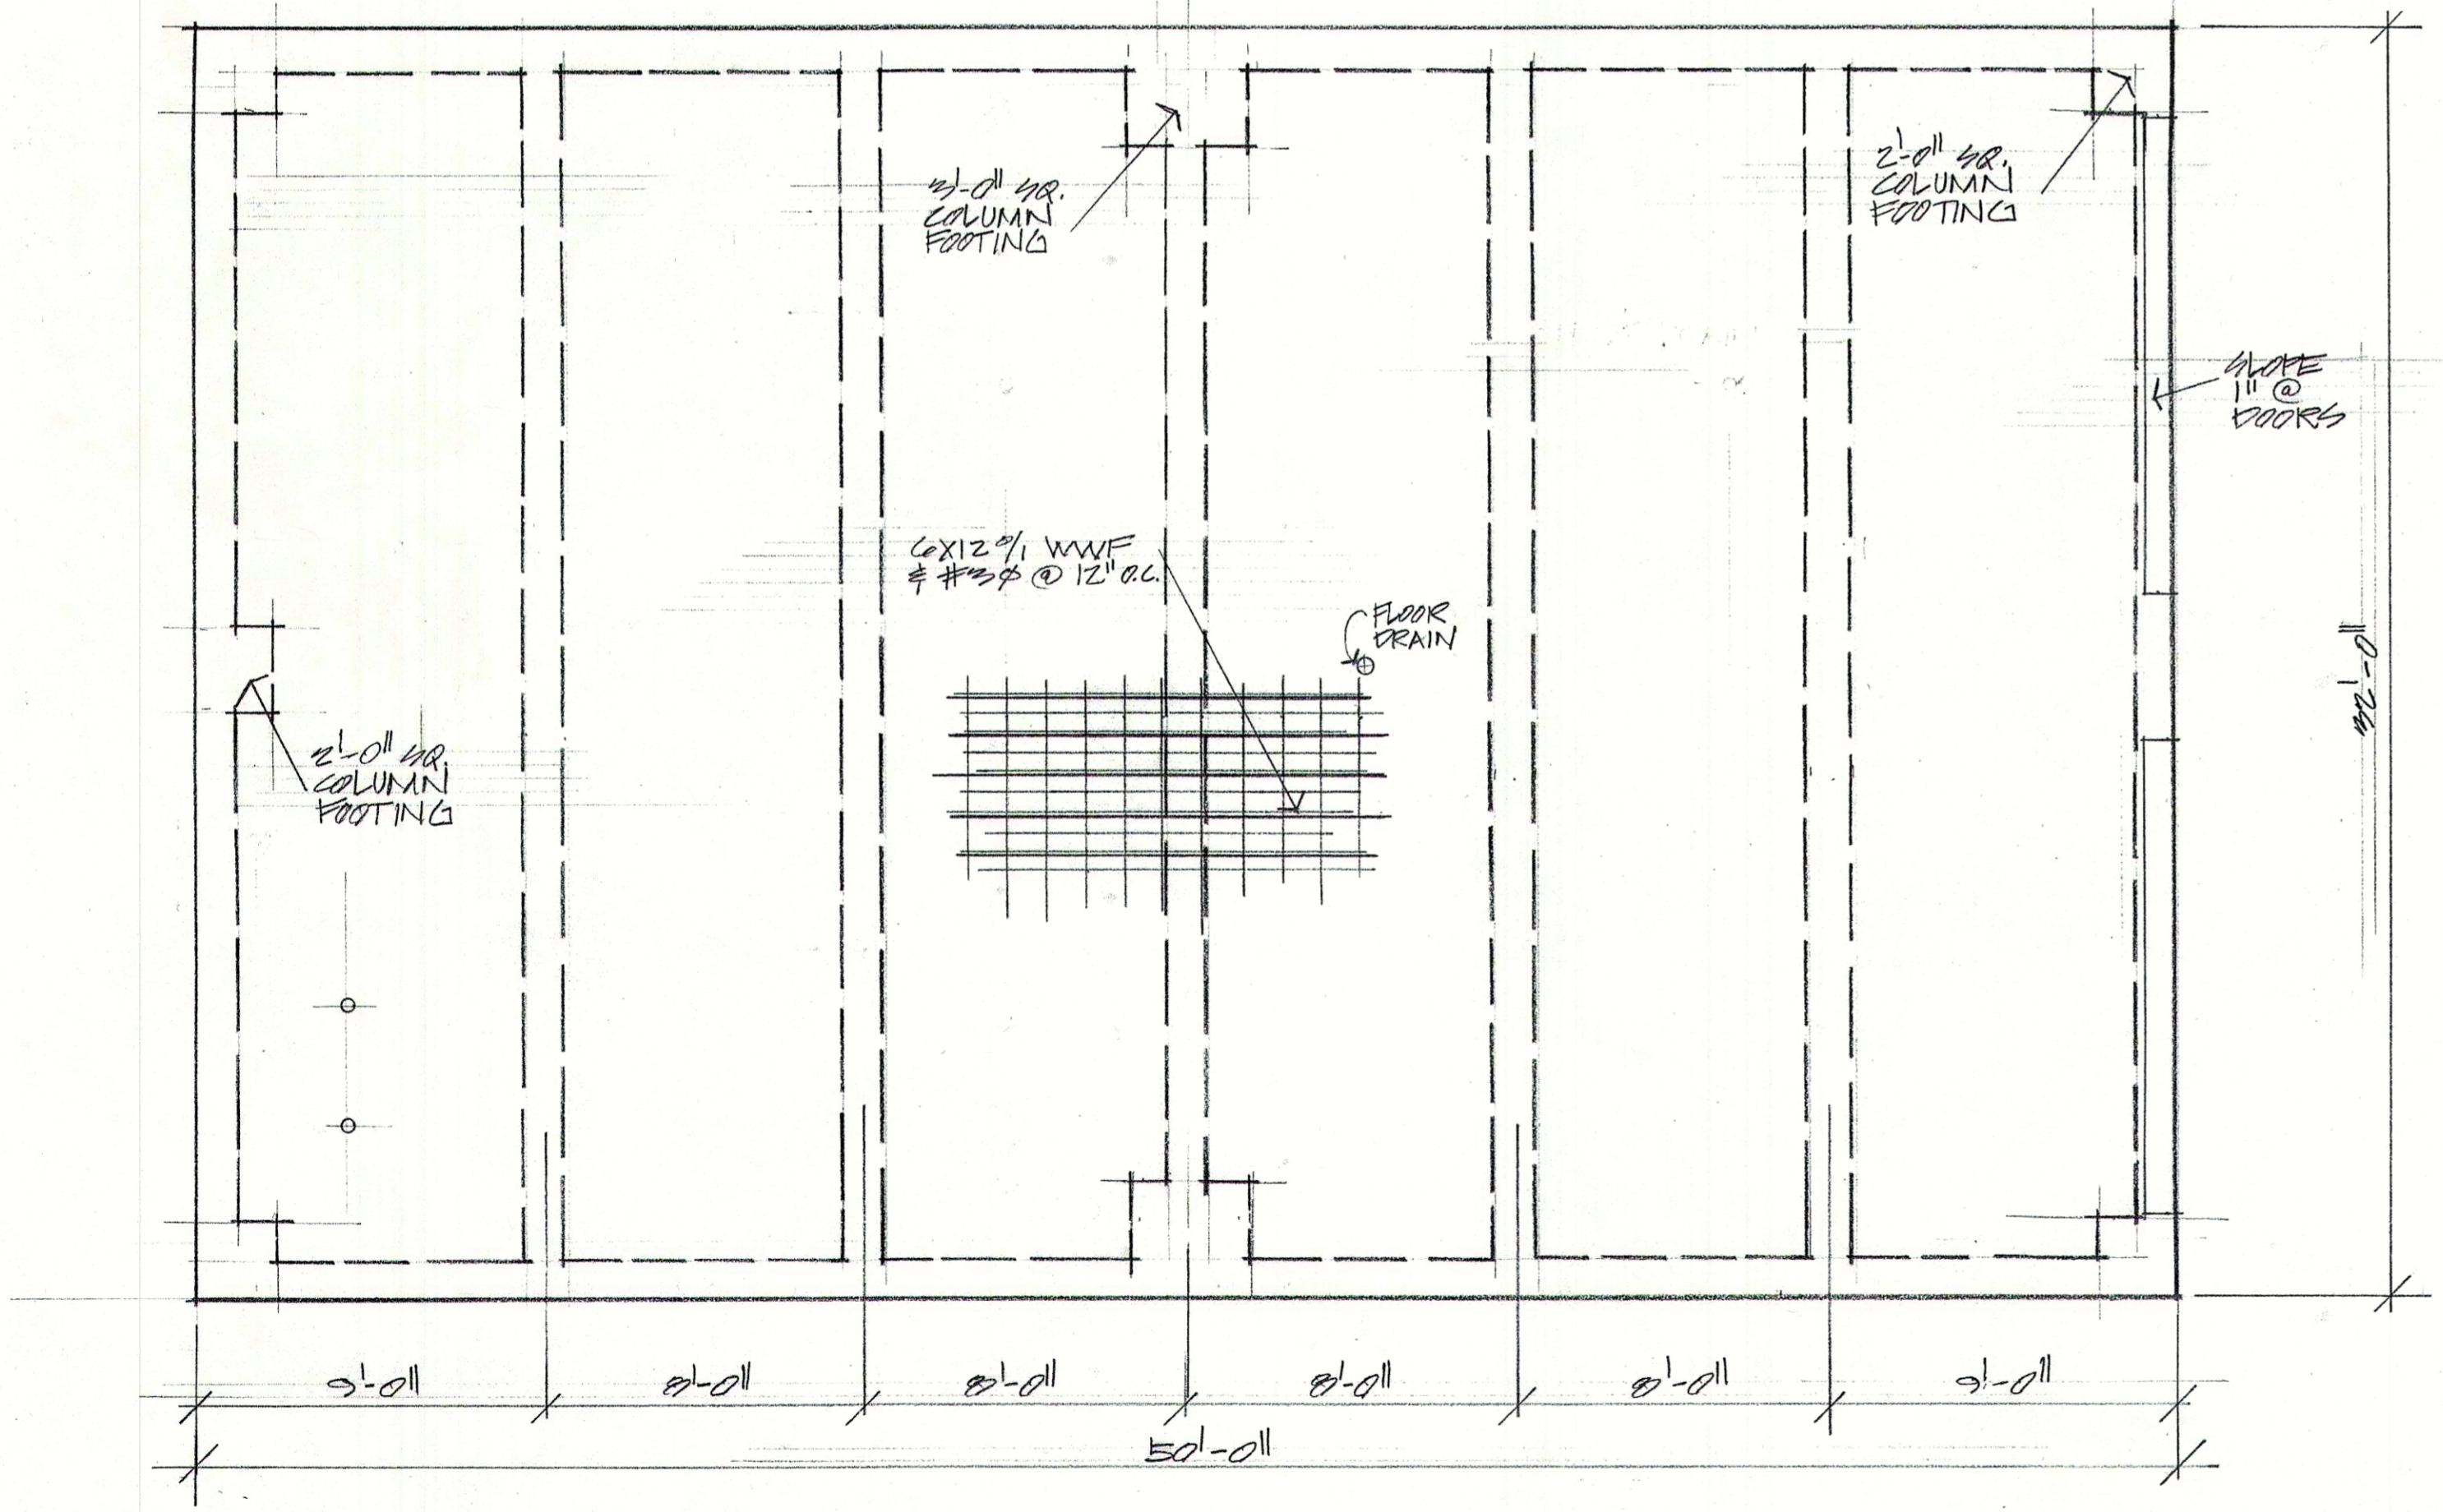

FOUNDATION PLAN

SCALE 1/4" = 1'-0"

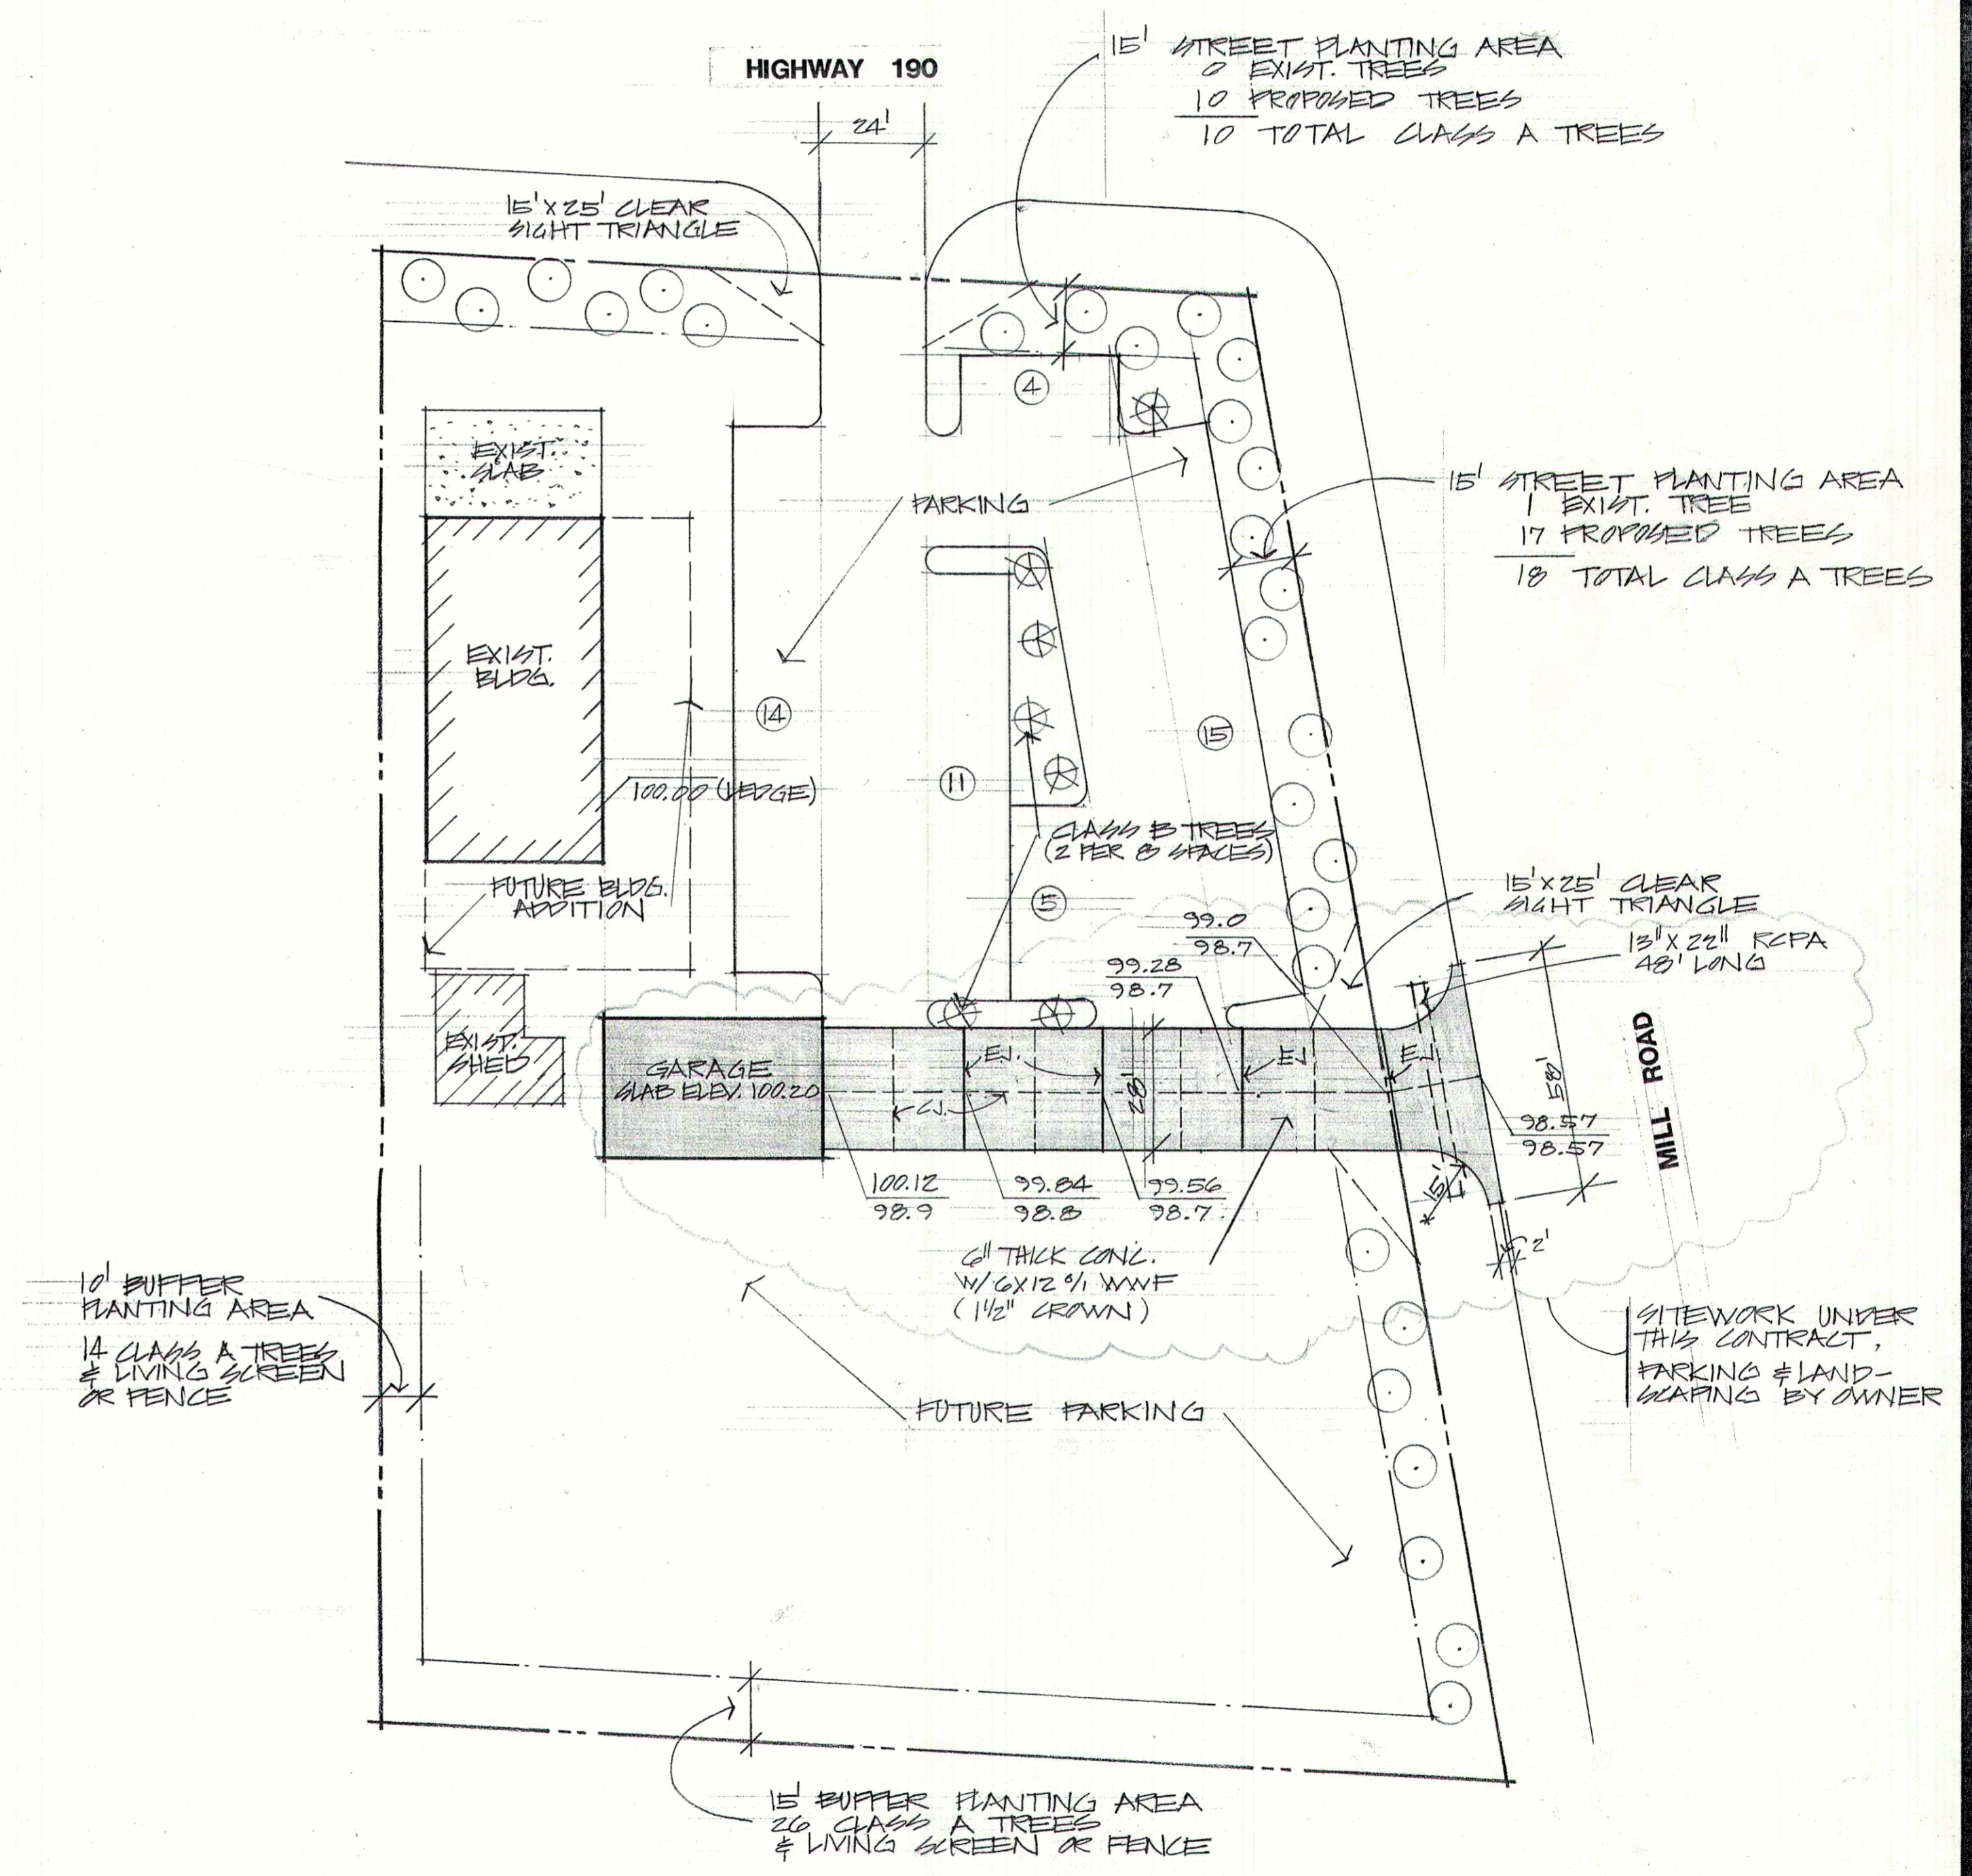

SITE PLAN

SCALE 1" = 30'

RENE A. HARRIS & ASSOCIATES
CONSULTING ENGINEER


OAKLAWN FIRE STATION
GARAGE ADDITION - PHASE III

DATE
3-1-90

SHEET
1
OF 5

PLUMBING FIXTURE SCHEDULE									
MARK	FIXTURE	HW	CW	RAIN	TRAP	DESCRIPTION	MFR	NAME	NUMBER
WC	WATER CLOSET	-	1/2"	4"	-	VITREOUS CHINA SLOPE COUPLED SIPHON JET. ELONG TOILET, BOLT CAPS, OPEN FRONT SEAT W/COVER, ANGLE SUPPLY	KOHLER	"WELLWORTH"	K-3500 EB
LAV	LAVATORY	1/2"	1/2"	2"	1 1/2"	VITREOUS CHINA WALL MTR LAV. W/ SINGLE LEVER FAUCET, AERATOR, POP UP DRAIN, ANGLE SUPPLIES, TRAP	KOHLER	"GREENWICH"	K-2030, 20" X 10" W/ K-6883 TRIM
SINK	SINK	1/2"	1/2"	2"	1 1/2"	SELF RIMMING 3/4. 18 GA. 22" X 22" 3/4. COMP SINK W/ 10" H. GOOSE NECK SPOUT, 6" WRIST BLADES, ①	ELKAY	"WIMERTONE"	LK-2222
SERVICE SINK	SERVICE SINK	1/2"	1/2"	2"	1 1/2"	3/4. COMP 14 GA. 3/4. SCULLERY SINK, 2 LK 66 C FAUCETS, 1/4" TO CONT. WASTE, 3/4" 35 WASTE FITTINGS	ELKAY	"WELD BILT"	46 8130
FD	FLOOR DRAIN	-	-	4"	-	FLOOR DRAIN W/ SATIN BRONZE STRAINER	JOHNSON		30,000 A
OSD	OPEN SAHT DRAIN	-	-	-	-	OPEN SAHT DRAIN W/ FUNNEL & SATIN BRONZE STRAINER	JOHNSON		30,000 E2
EWL	ELECTRIC WATER COOLER	-	-	-	-	6.7 GPH, 350 W., 4.5 FLA, 1/8 HP	HALSEY TAYLOR		EFZ-75S
WH	WATER HEATER	3/4"	3/4"	-	-	ELECTRIC W.H., 50 GAL, 240 V., 1 φ W/2 SIMULTANEOUS 4500 W. ELEMENTS			


① AERATOR, STRAINER & STOPPER, ANGLE SUPPLIES, TRAP

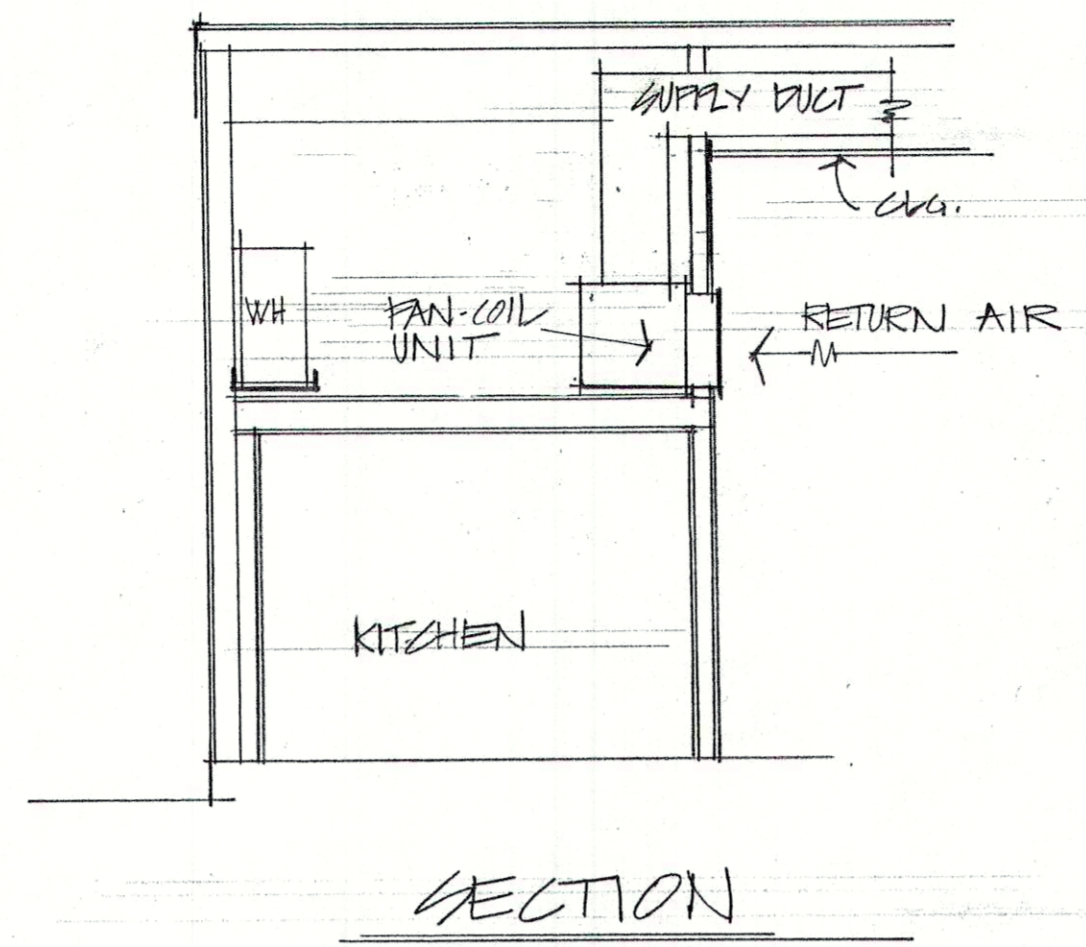

HEATING & AIR CONDITIONING UNIT SCHEDULE												
FAN COIL UNIT							CONDENSING UNIT					
MARK	COOLING BTU/HR	CFM	FAN HP	VOLTS	PH	HTR KW	MODEL NO.	VOLTS	PH	COMP FLA	COMP FAN	MODEL NO.
HVAC	74,000	2400	1	230	3	10	LENNOX CB 17-95V	208/230	3	26.7	2.9	H 317-013V ②


EXHAUST FAN SCHEDULE										
MARK	TYPE	CFM	GRATIC IN W/G	MIN. HP	VOLTS	PH	MAX. SPEED	MODEL NO.	CONTROL	
EF 1	CEILING MOUNT CENTRIFUGAL	110			120	1	3.5	NUTONE 8814	INTERLOCK W/ LIGHTS, ①	
EF 2	RANGE HOOD & SHELF W/CENTRIFUGAL BLOWER	300			120	1	4.5	BROAN 123035		

① FURNISH W/ VARIABLE SPEED CONTROL, COOK FAN TYPE
② EER 8.5

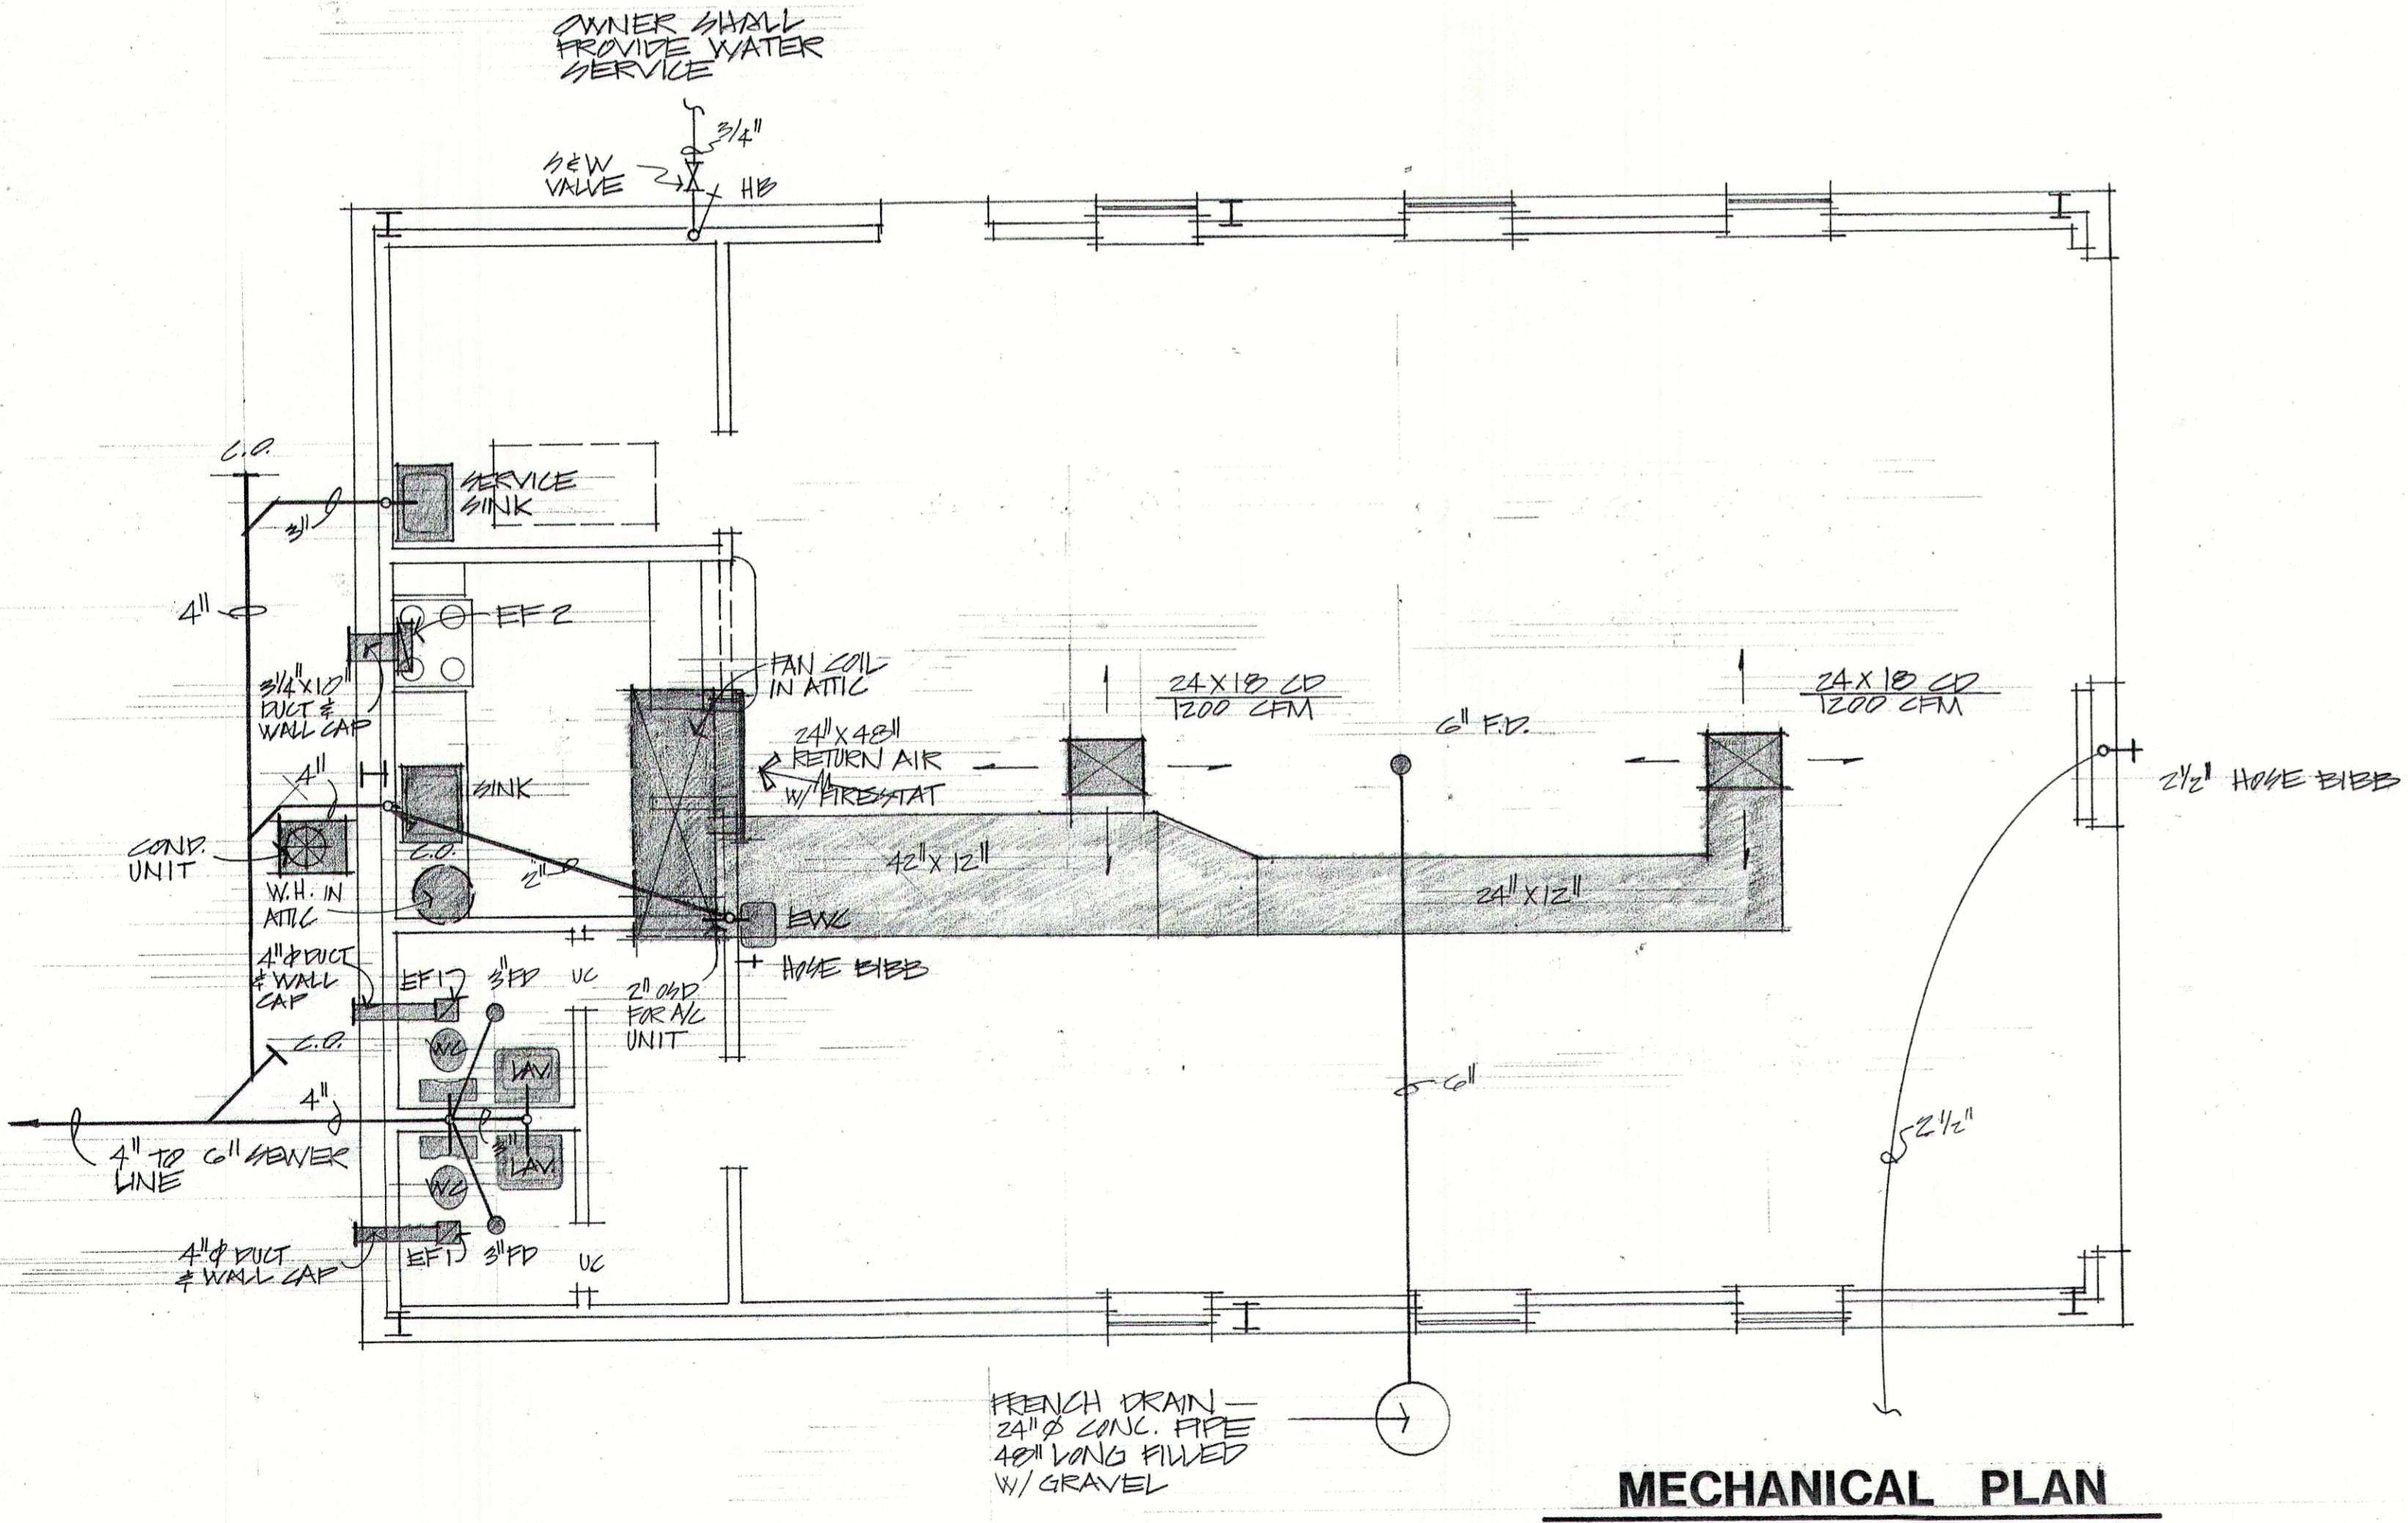

MECHANICAL PLAN

SCALE 1/4" = 1'-0"

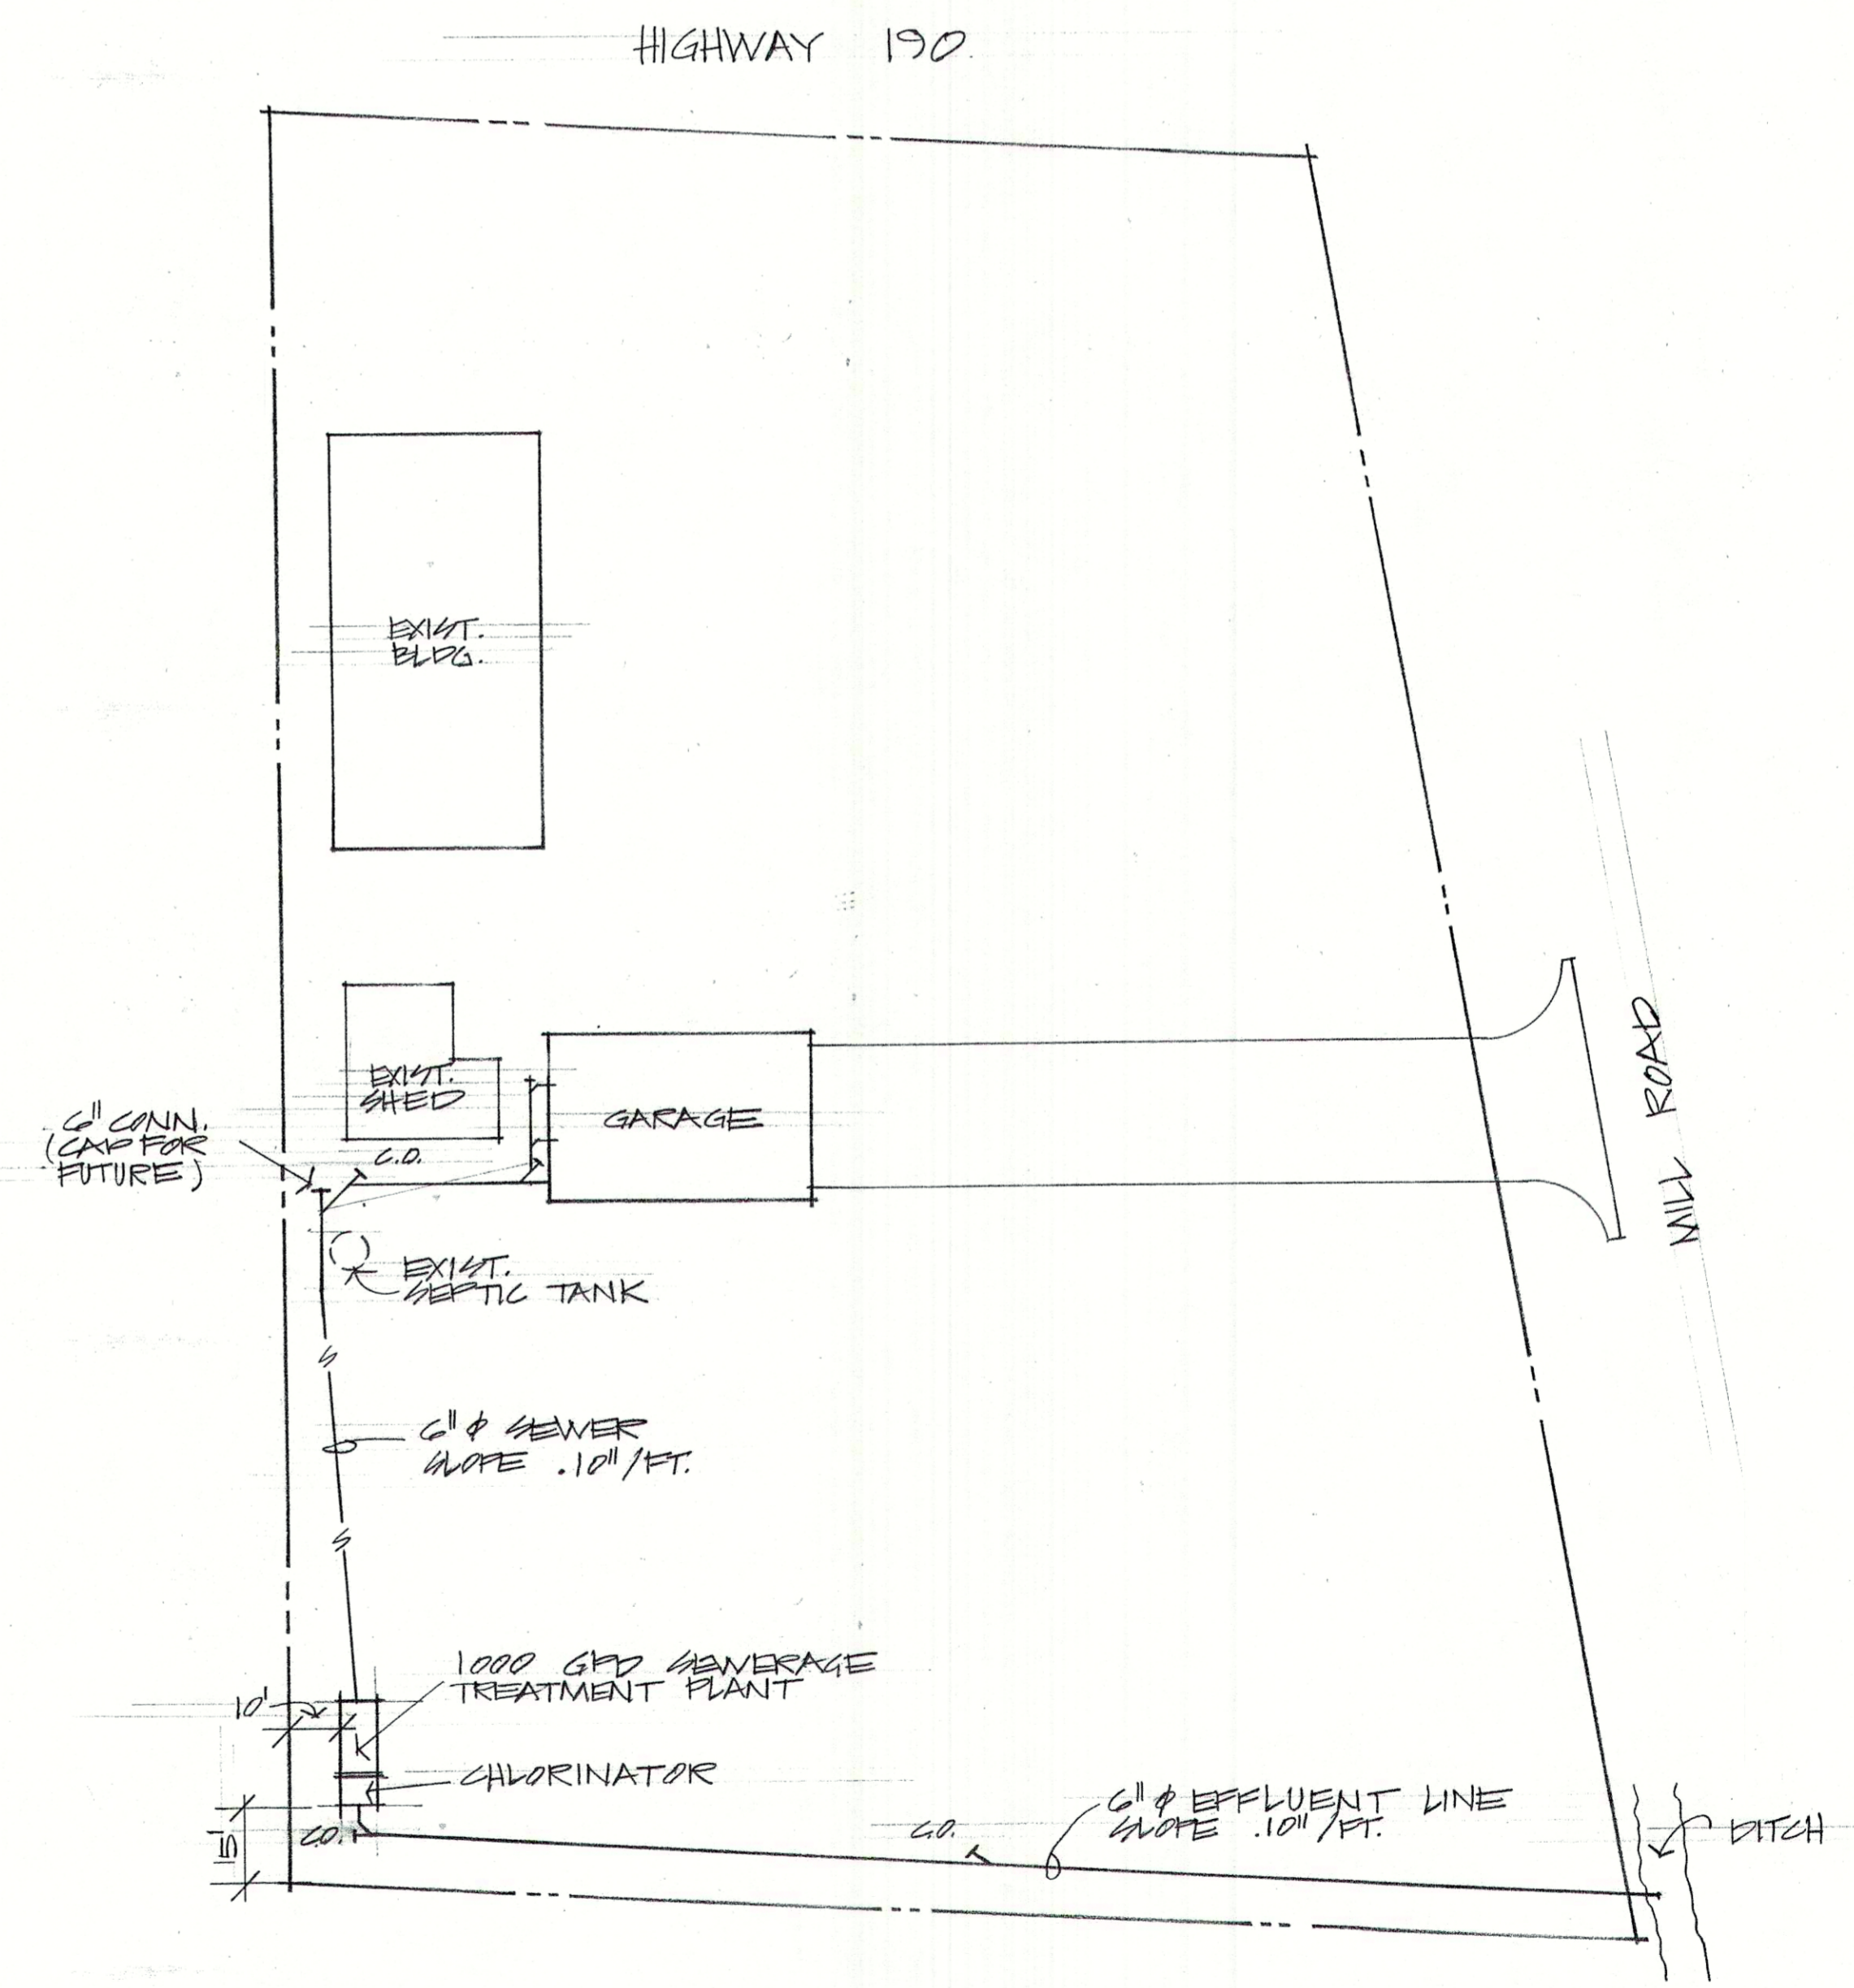

SITE PLAN

SCALE 1" = 30'

RENE A. HARRIS & ASSOCIATES
CONSULTING ENGINEER

OAKLAWN FIRE STATION
GARAGE ADDITION - PHASE III

DATE
3-1-90


SHEET
3
OF 5

PANEL "L-3" SCHEDULE

SERVICE	120/240V - 1Ø - 3W, 3N - 60 Hz AC								
MAINS	125 AMP MVD								
BRANCHES	20								
CABINET TYPE	SURFACE MTD								
	3Ø 1Ø - 24" x 12" - FK15 GTA								
QTY.	No.	TRIP	BRKR	WIRES	RACE	WAD	SERVED	KVA	
No.	POLE	AMP	FRME	No.	SIZE	WAY			
1,3	1	20	RD	2	12	12	NM	LIGHTING	1.6
2	1	20		2	12	12	NM	LIGHTING	.6
4	1	20		2	12	12	NM	EXTR. LTG.	.6
5	1	20		2	12	12	NM	EMER. LTG.	.1
6	1	20		2	12	12	NM	RECEPTS.	1.0
7	1	20		2	12	12	NM	RECEPTS.	1.0
8,10	1	20		2	12	12	NM	RECEPTS.	2.0
9	1	20		2	12	12	NM	RECEPTS.	1.0
11	1	20		2	12	12	NM	RECEPTS.	1.0
12	1	20		2	12	12	NM	RECEPTS.	1.0
13,15	1	20		2	12	12	NM	DR. DR. OPENG.	2.4
14	2	60		3	6	10	NM	RANGE	3.0
16	2	30		2	10	12	NM	WATER HEATER	4.5
17	1	20		2	12	12	1/2	WV. TREATMENT	.6
18	1	20		2	12	12	NM	RECEPT.	1.0
19,22	1	20		-	-	-	-	STAIR	
TOTAL								25.0	

SYMBOL SCHEDULE


- FLUORESCENT FIXTURE - SEE SCHEDULE
- INCANDESCENT FIXTURE - SEE SCHEDULE
- ⚡ SINGLE POLE TRIPPLE SWITCH - 20 AMP 125V. - AC, QUIET TYPE
- ⊕ DUPLEX RECEPTACLE - 15 AMP - 125V. - 3W GROUNDING TYPE
- ⊙ JUNCTION BOX
- ▭ PANELBOARD - SEE SCHEDULE
- 100/100 (2) DISCONNECT SWITCH - 240V. - FUSIBLE 100/100 DENOTES SIZE OF SWITCH, 100 SIZE OF FUSE - (2) NO. WIRES - HEAVY DUTY - NEMA - 1 INDOORS, NEMA - 3R OUTDOORS.
- ⊙ MOTOR - NUMERAL DENOTES HORSEPOWER DENOTES MOUNTED ABOVE COUNTER MIN. 6"
- WF WEATHER PROOF
- ELECTRICAL WIRING RUN CONCEALED IN WALLS OR CEILING
- ELECTRICAL RACEWAY - RUN UNDERGROUND
- HOME RUN
- GF1 GROUND FAULT INTERRUPTER
- ⊠ STARTER OR CONTACTOR
- ⊠ ELECTROL HEAT ELEMENT
- SM MOTOR OR HORSEPOWER RATED SWITCH

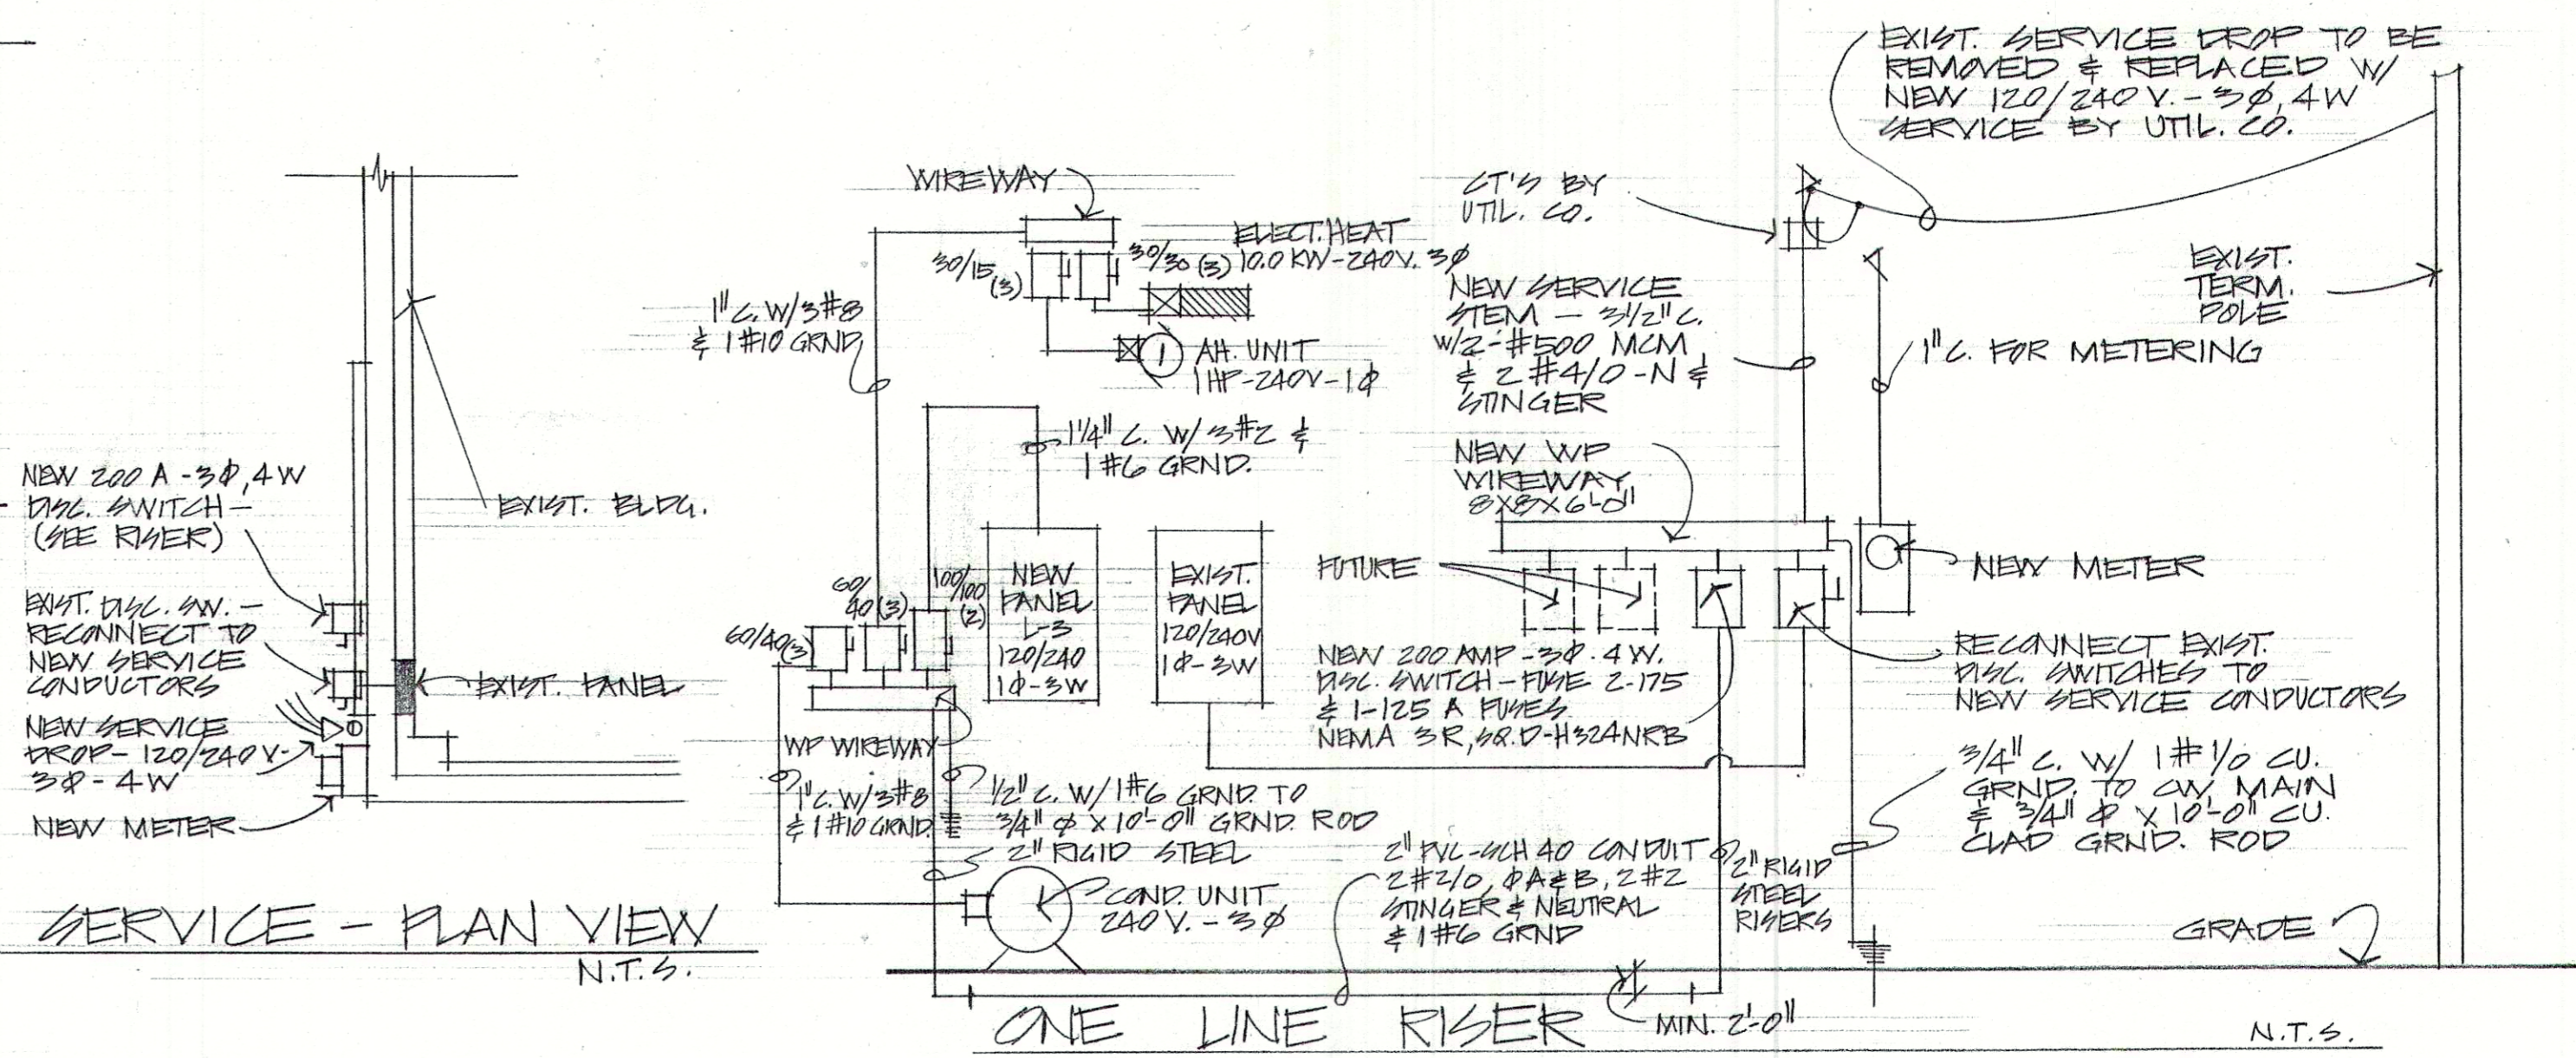

LIGHTING FIXTURE SCHEDULE

FIXTURE	TYPE	SIZE	MOUNTING	LAMPS			REMARKS	NOTES	MANUFACTURER & CATALOG NUMBER	ADDITIONAL APPROVED MANUFACTURER
				NUMBERS	VOLTAGE	COLOR				
F1	F	24 x 48	SURF. CLG.	4	40	RS T12	CW	WRAP AROUND ACRYLIC DIFF.	WILLIAMS SERIES 1024-A	METALUX BENJAMIN
F2	F	12 x 48	SURF. CLG.	2	40	RS T12	CW	(SAME AS F1)	WILLIAMS SERIES 1722-A	METALUX BENJAMIN
F3	INC	-	SURF. CLG.	1	60	A	IF	ENCL. GLOBE FIX.	PROGRESS #P5797	MARCO HUBBELL
F4	-	-	WALL MTD.	2	3W	PAR 25	FL	EMER. LGT. W/ BATTERY PACK	DUAL LITE #EE-2I-1P3	CHLORIDE LIGHTALARM
F5	#10	-	WALL MTD.	1	100	E	HPS	WALL PACK UNIT W/ URBAN DIFF.	SIMKAR #H4100 HCL6/HPS 120V.	MOLDCAST BENJAMIN


① PHOTO-CELL CONTROL

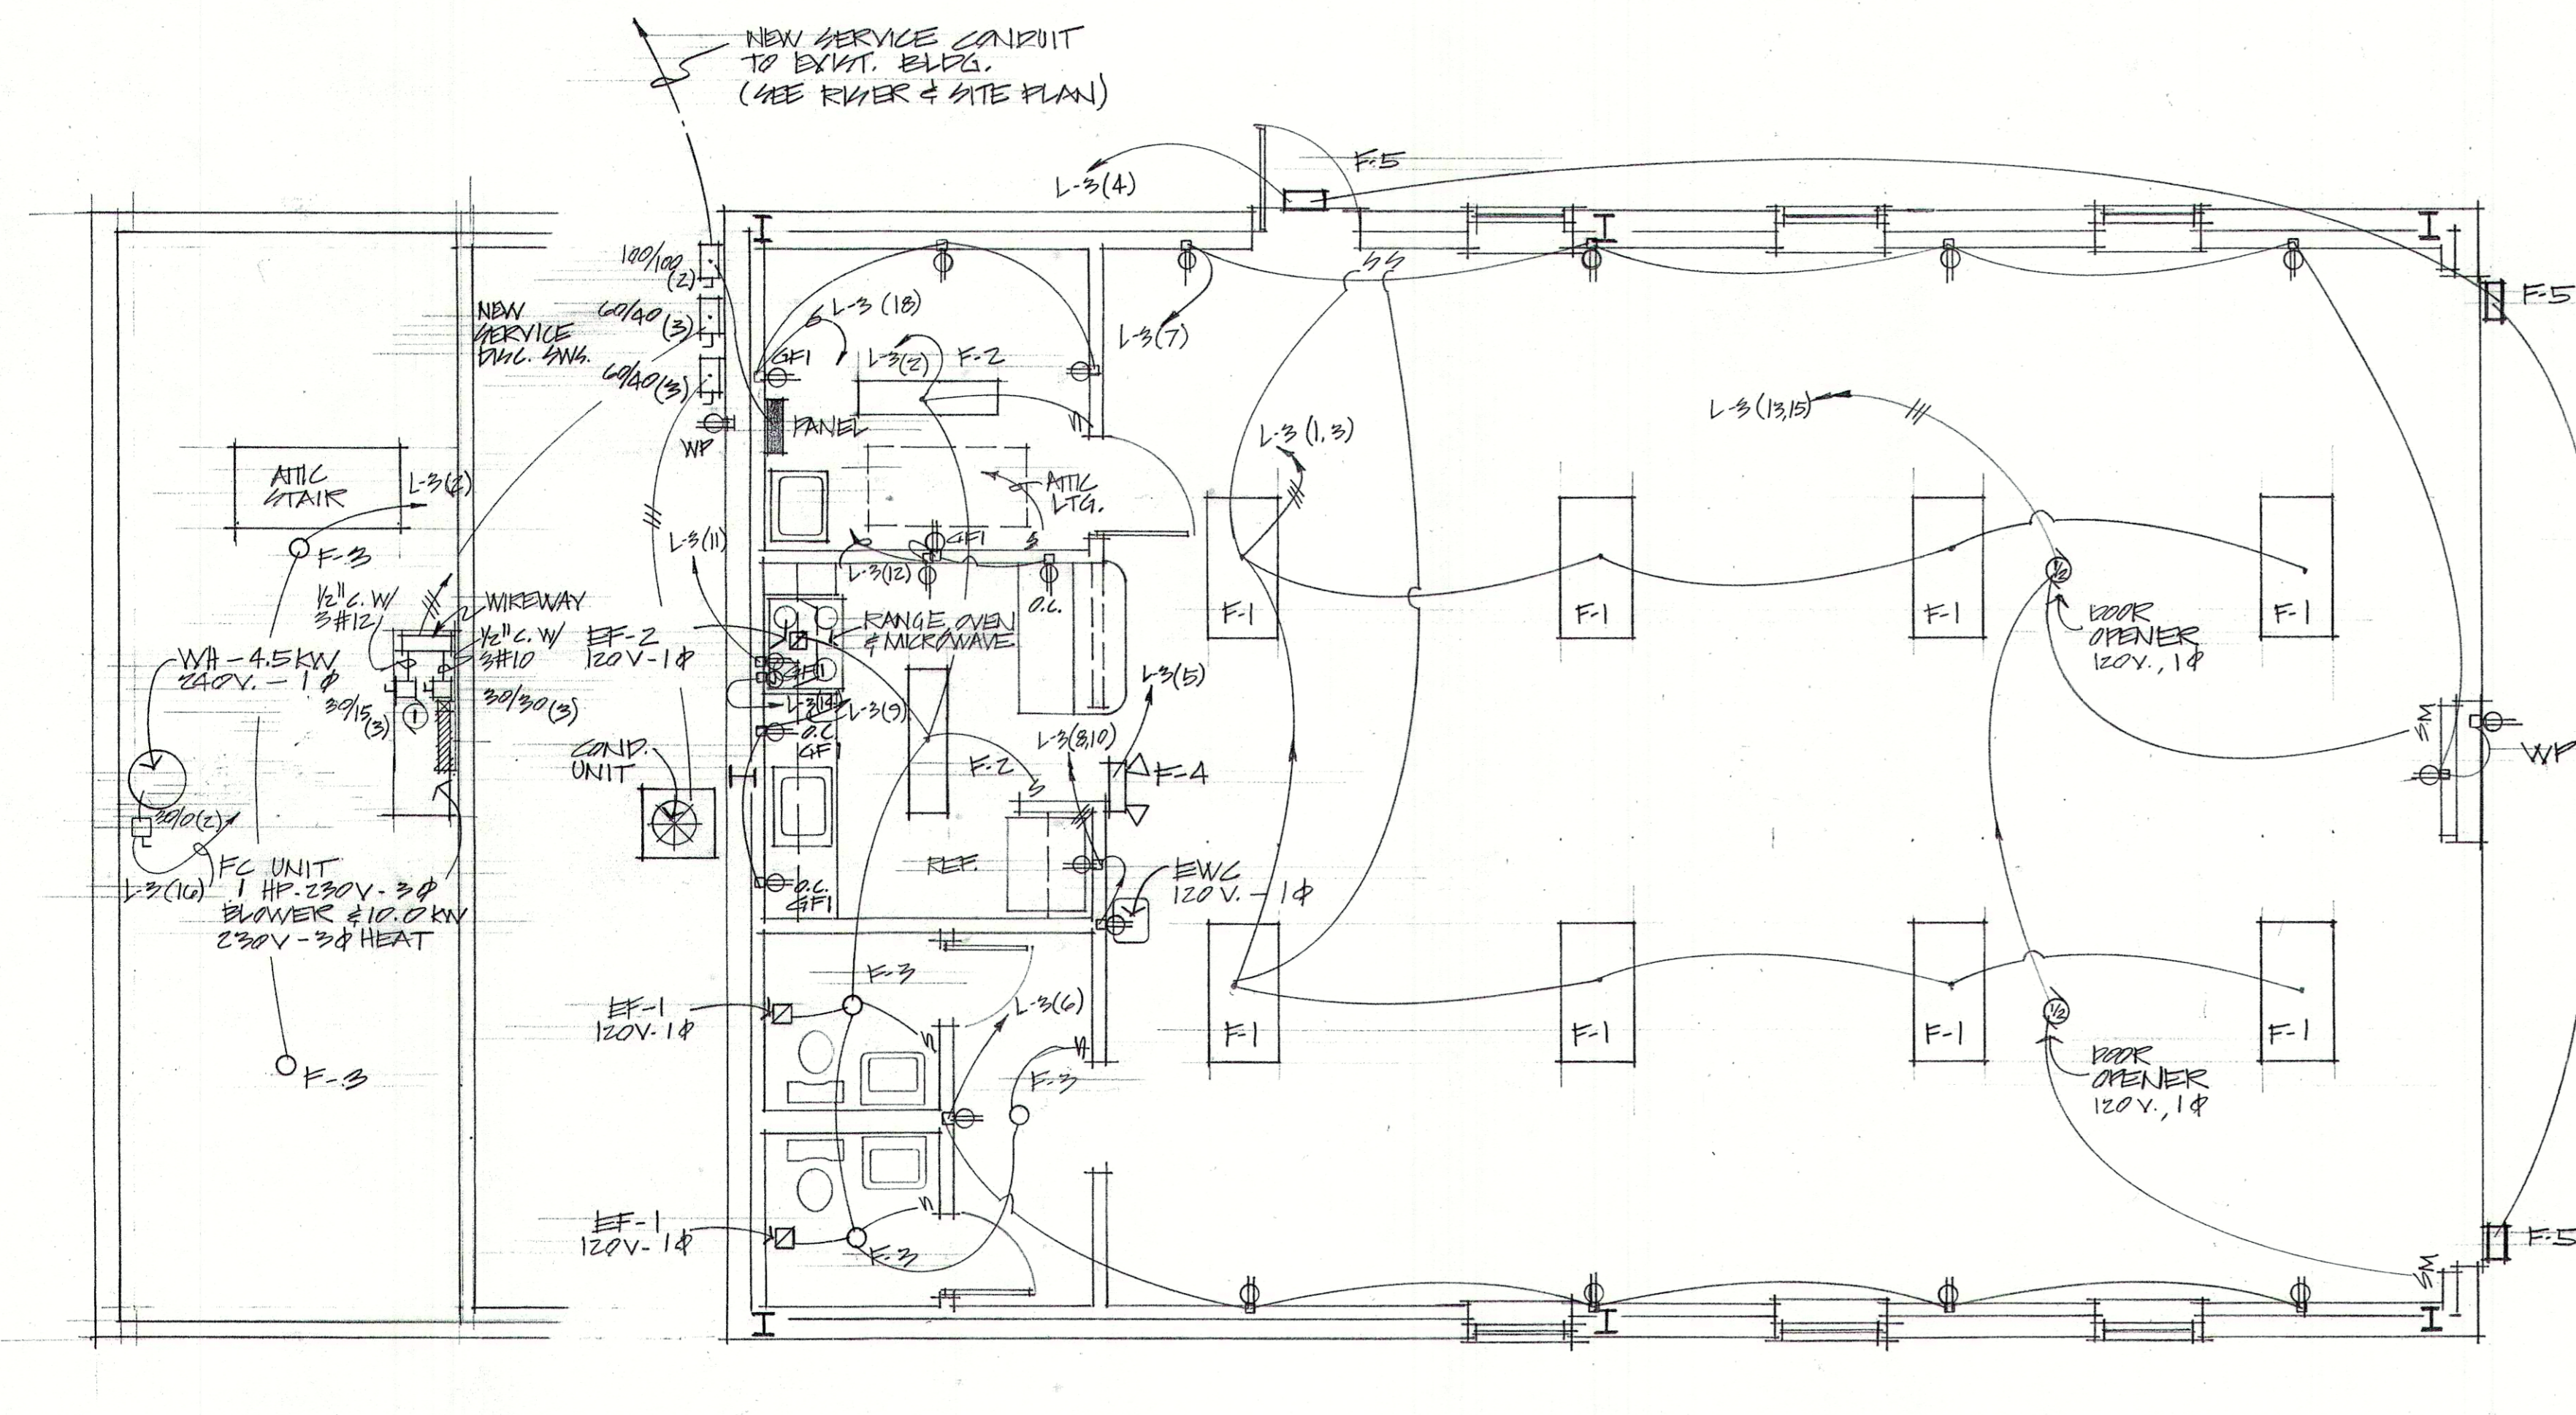

ATTIC PLAN

ELECTRICAL PLAN

SCALE 1/4" = 1'-0"

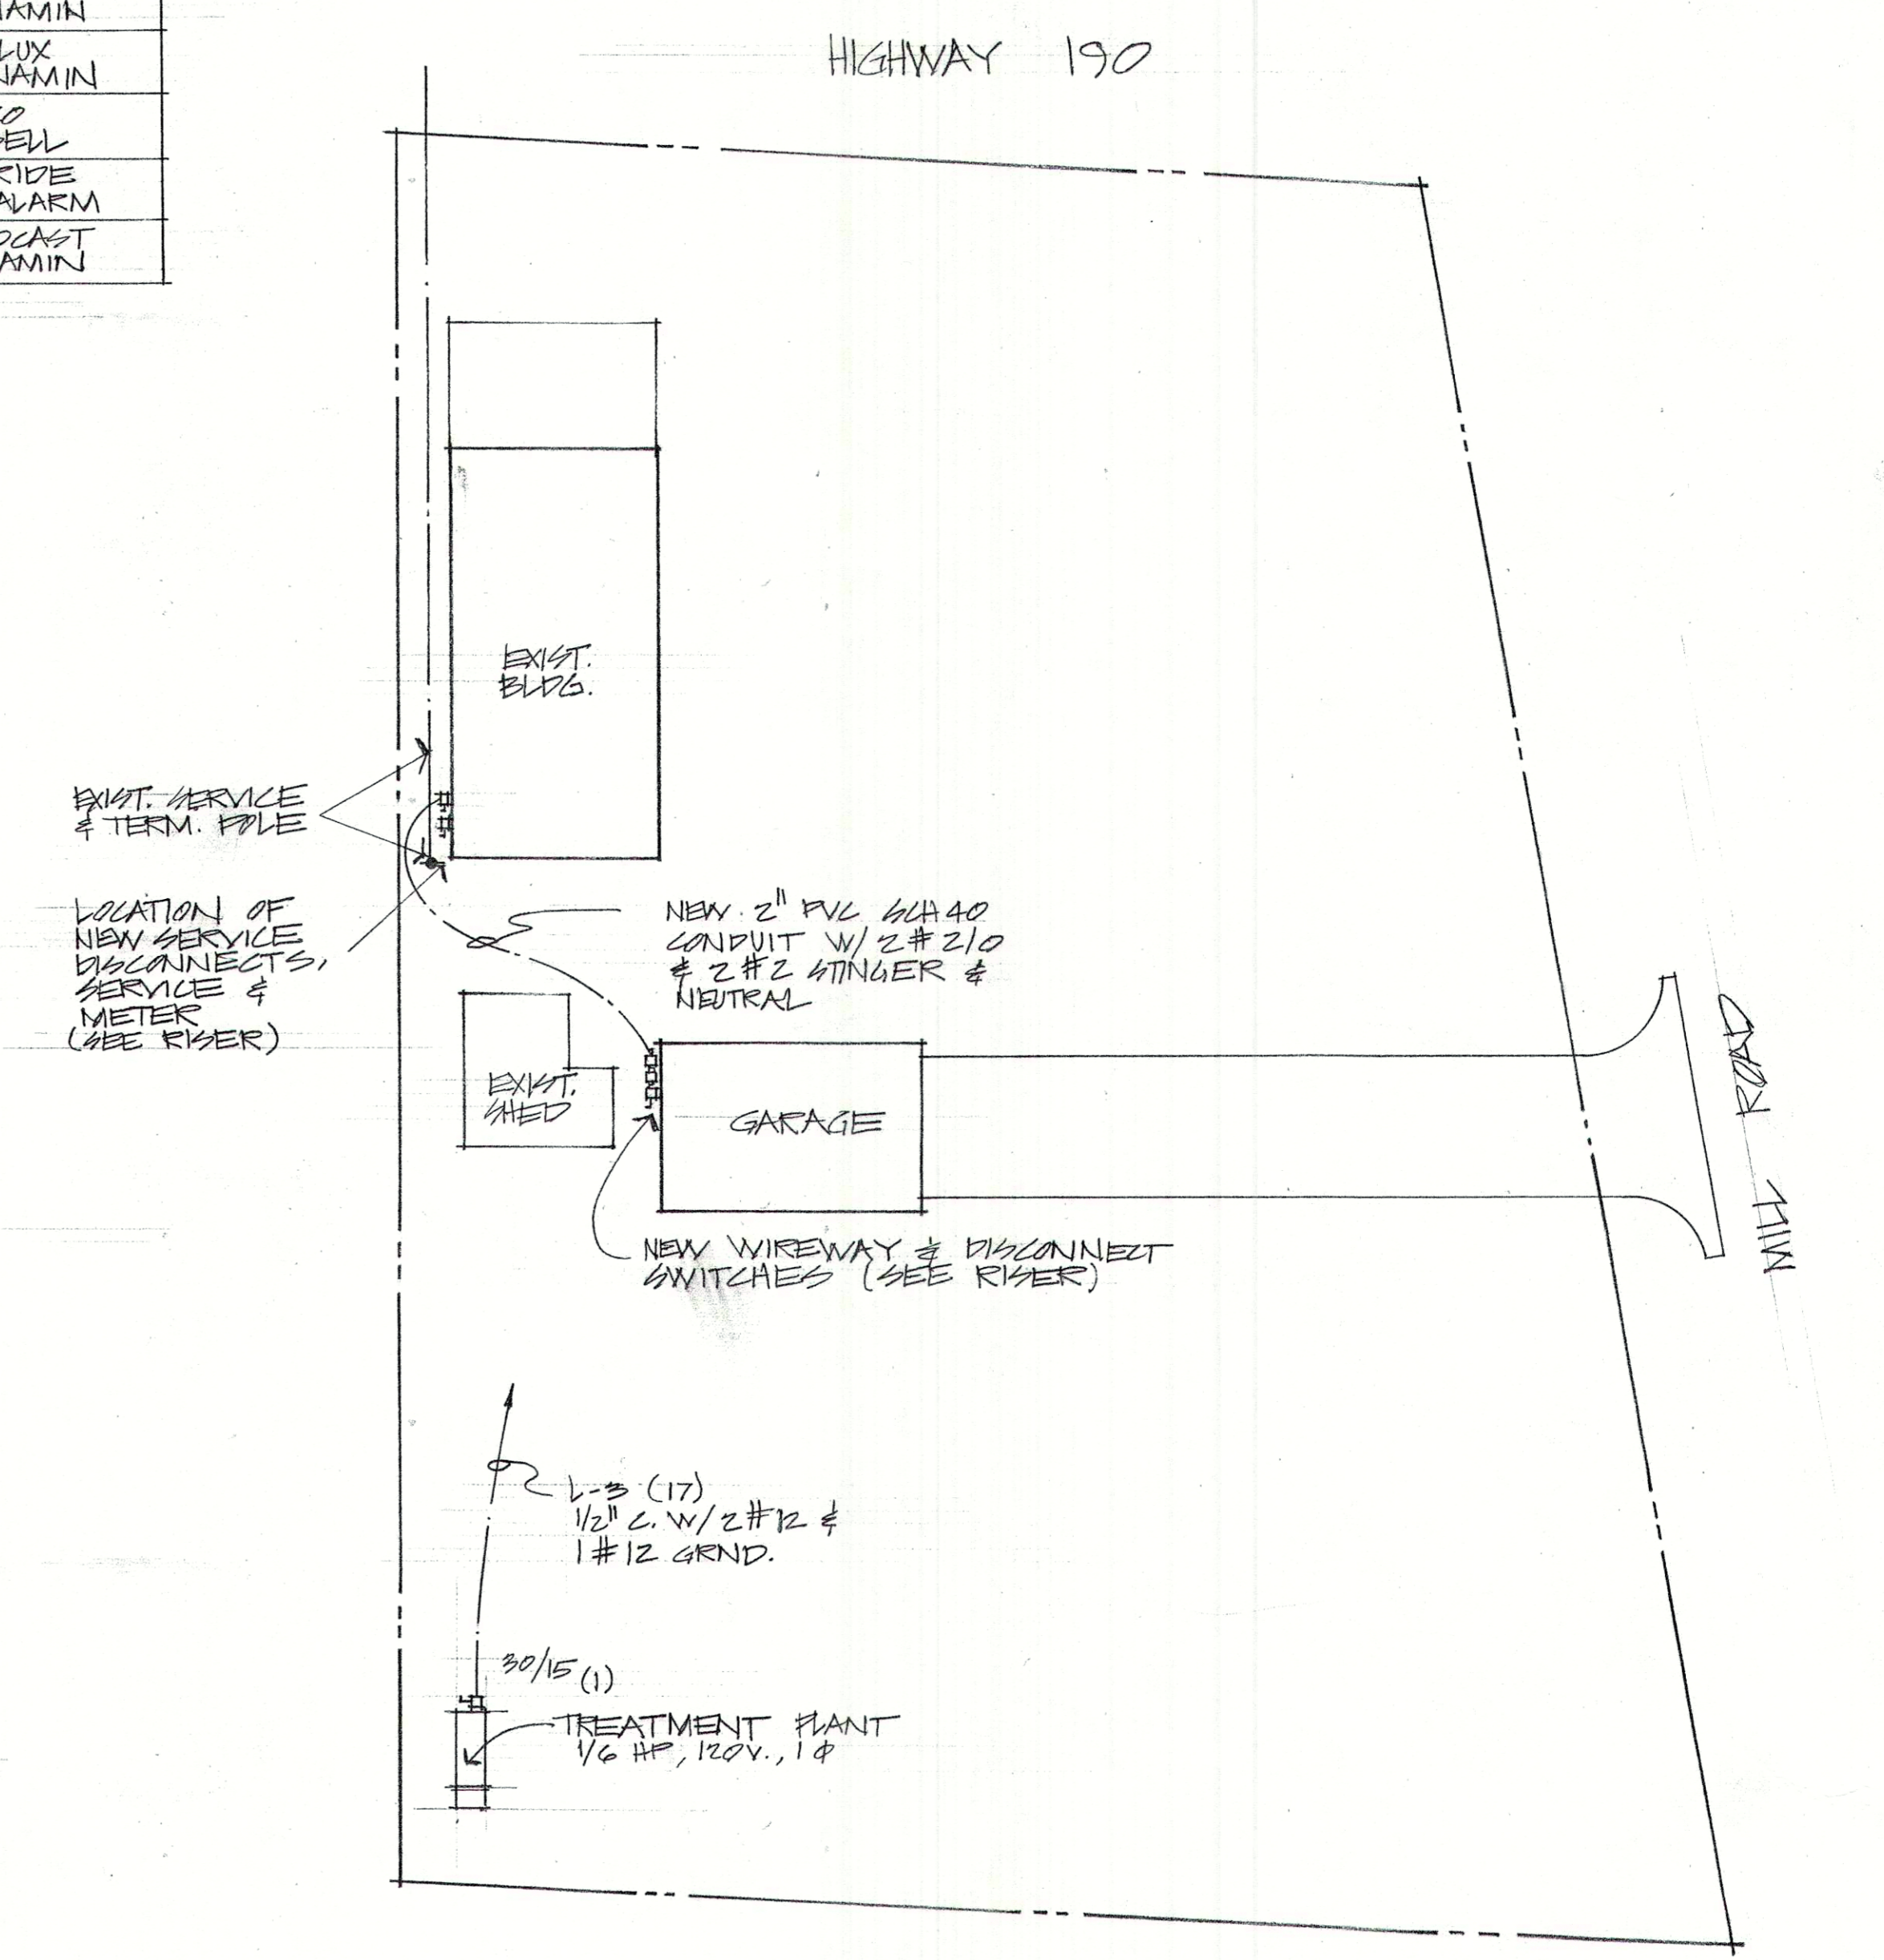

SITE PLAN

SCALE 1" = 30'

RENE A. HARRIS & ASSOCIATES
CONSULTING ENGINEER

OAKLAWN FIRE STATION
GARAGE ADDITION - PHASE III

DATE
3-1-90

SHEET
5
OF 5