


22 SECOND FLOOR POWER PLAN  
 DATE: 01-27-2025  
 DRAWN BY: CKD  
 CHECKED BY: RJK  
 PROJECT: 110 SOUTH SERVICE ROAD, METAIRIE, LOUISIANA

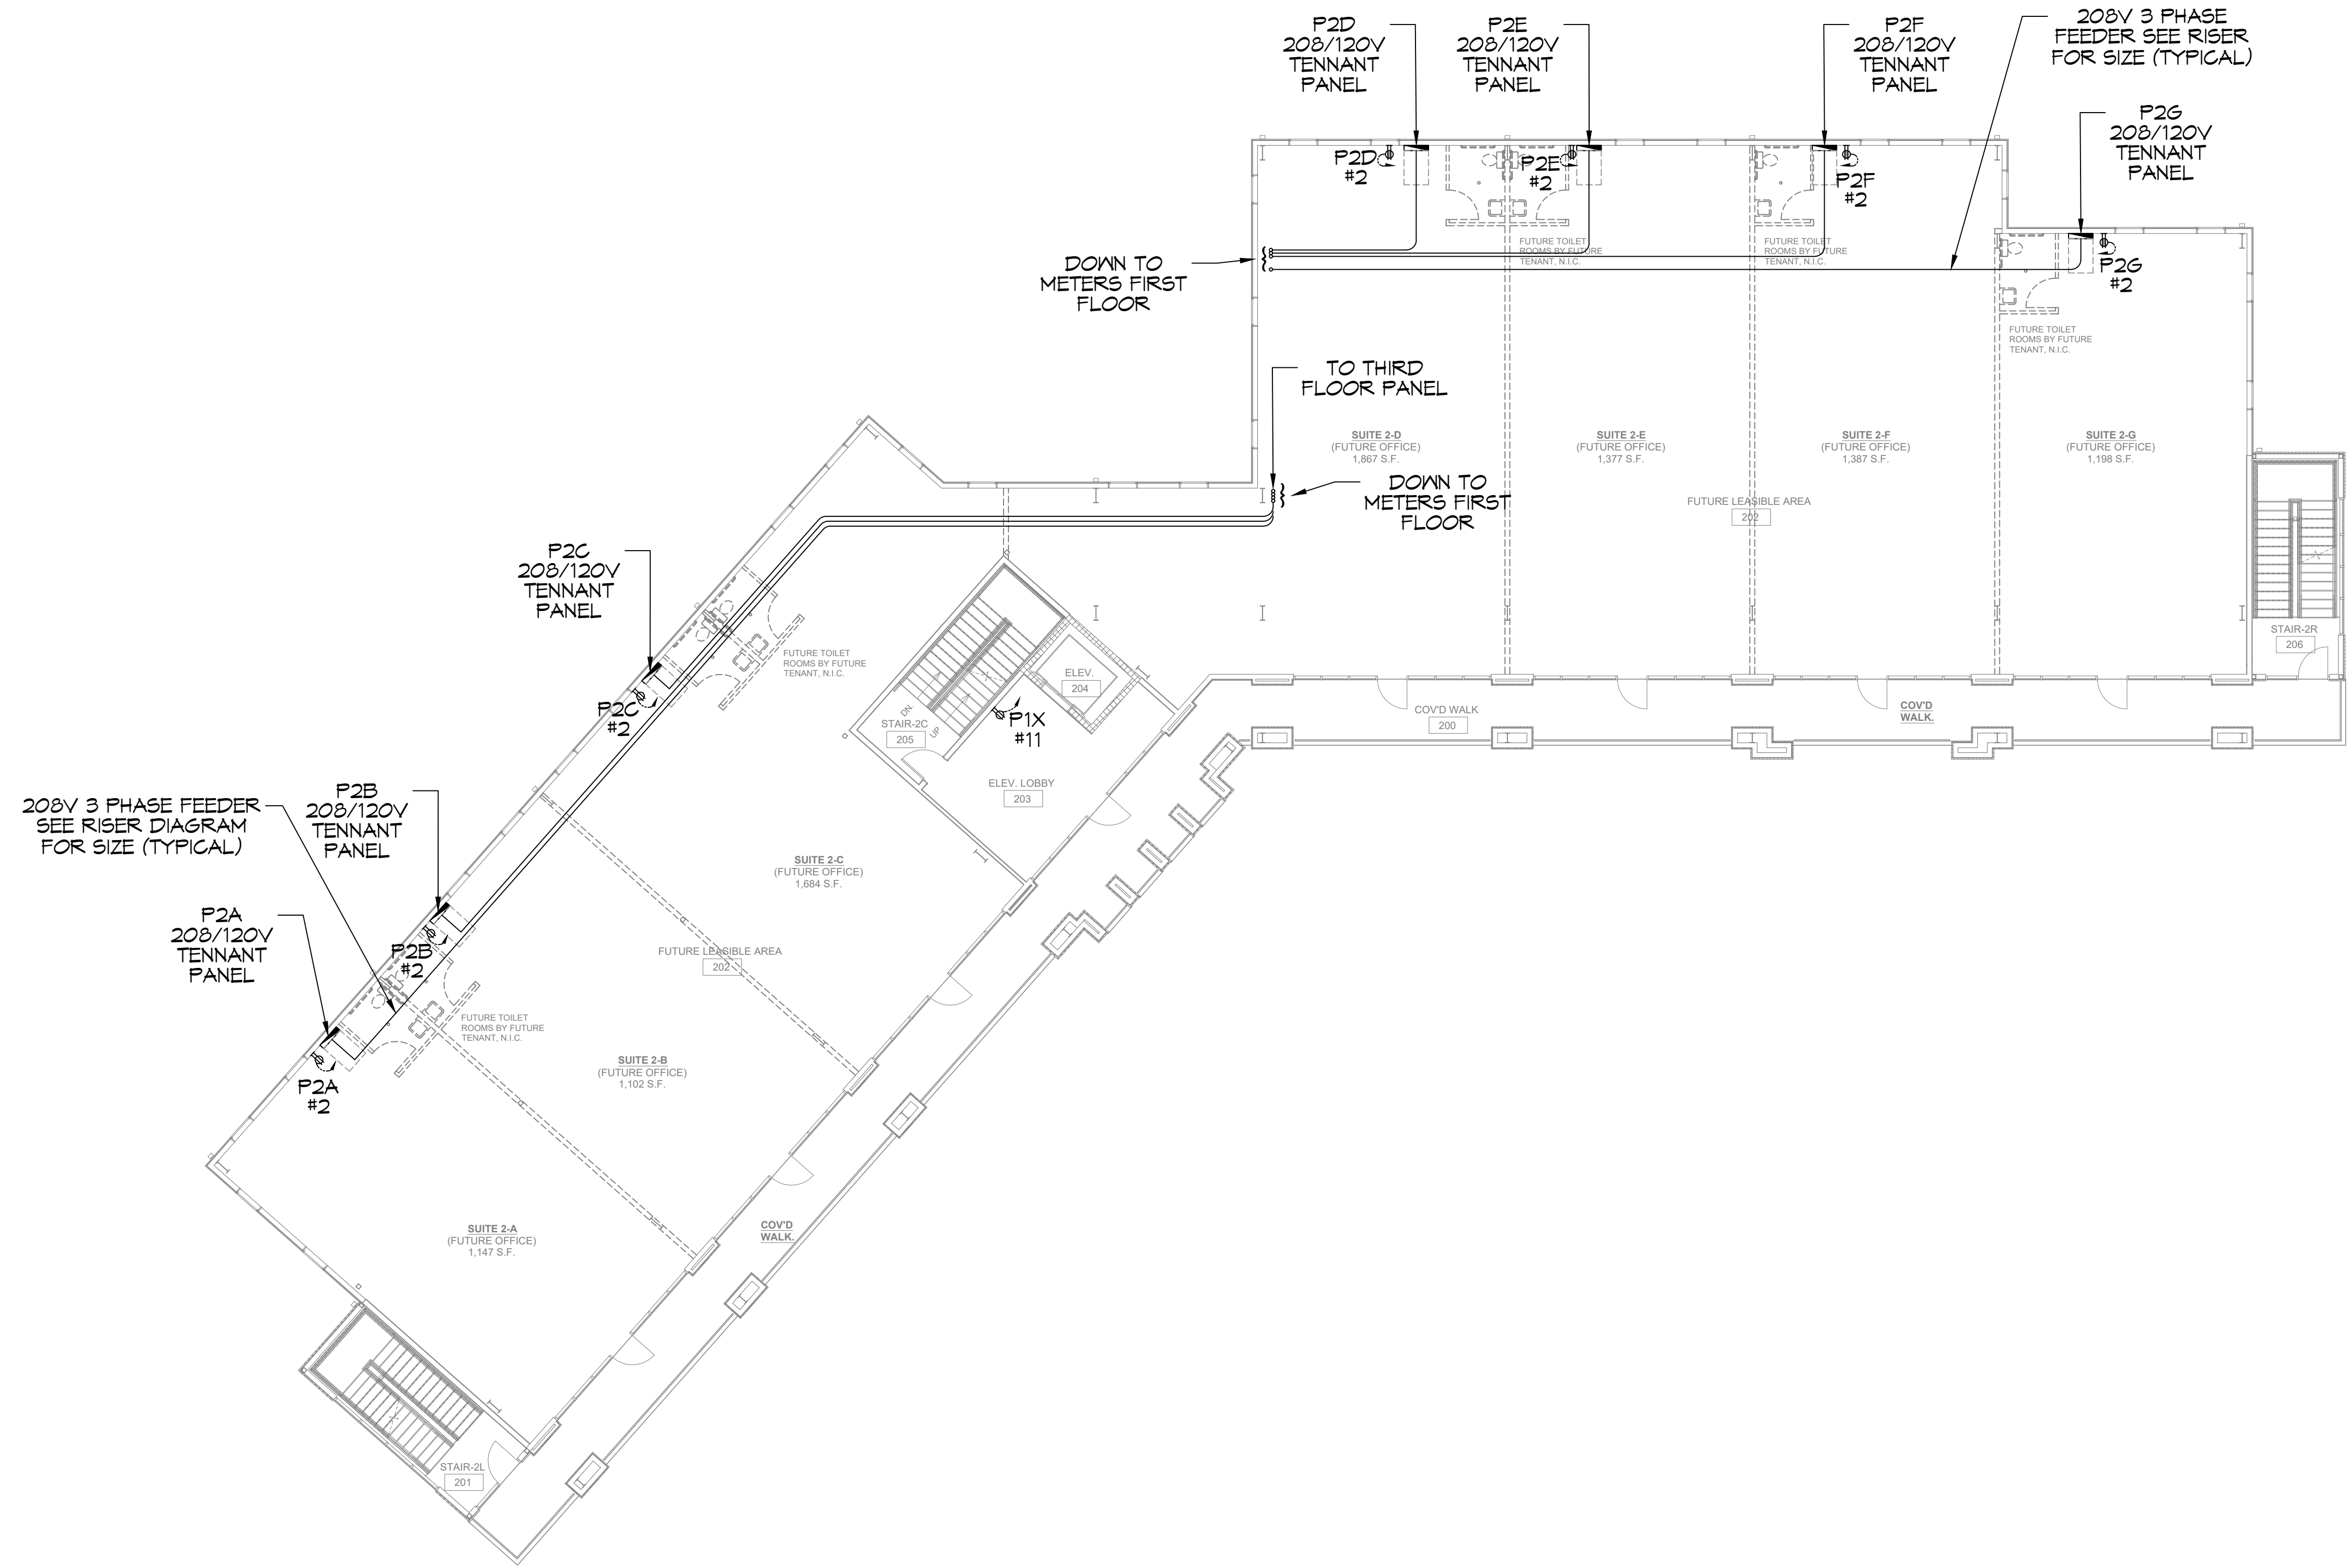

**22 SECOND FLOOR POWER PLAN**  
 SCALE: 3/32"=1'-0"

**DAMMON ENGINEERING, INC.**  
 LOUISIANA & MISSISSIPPI  
 www.dammonengineering.com  
 info@dammoneng.com  
 Chief Engineer: Brian Wilsch, PE  
 Sigsbee, LA 70459  
 Phone: 985.649.8832

REVISIONS	DATE
#	DESCRIPTION

SEAL:

**DEVELOPMENT**  
 110 SOUTH SERVICE ROAD  
 METAIRIE, LOUISIANA  
 JOB No: 01-27-2025  
 DATE: 01-27-2025  
 DRAWN BY: CKD  
 CHECKED BY: RJK

SHEET TITLE:  
 SECOND FLOOR POWER PLAN

DRAWING NUMBER:  
**E106**