
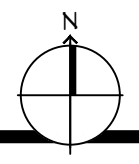


FILE NAME: A:\1 - School Plans\New Job\101 - Pope John Paul Auditorium\101 - Floor Plan.dwg, PLOT DATE: 8/20/2024, PLOT TIME: 10:52:14 AM, PLOT BY: JMS

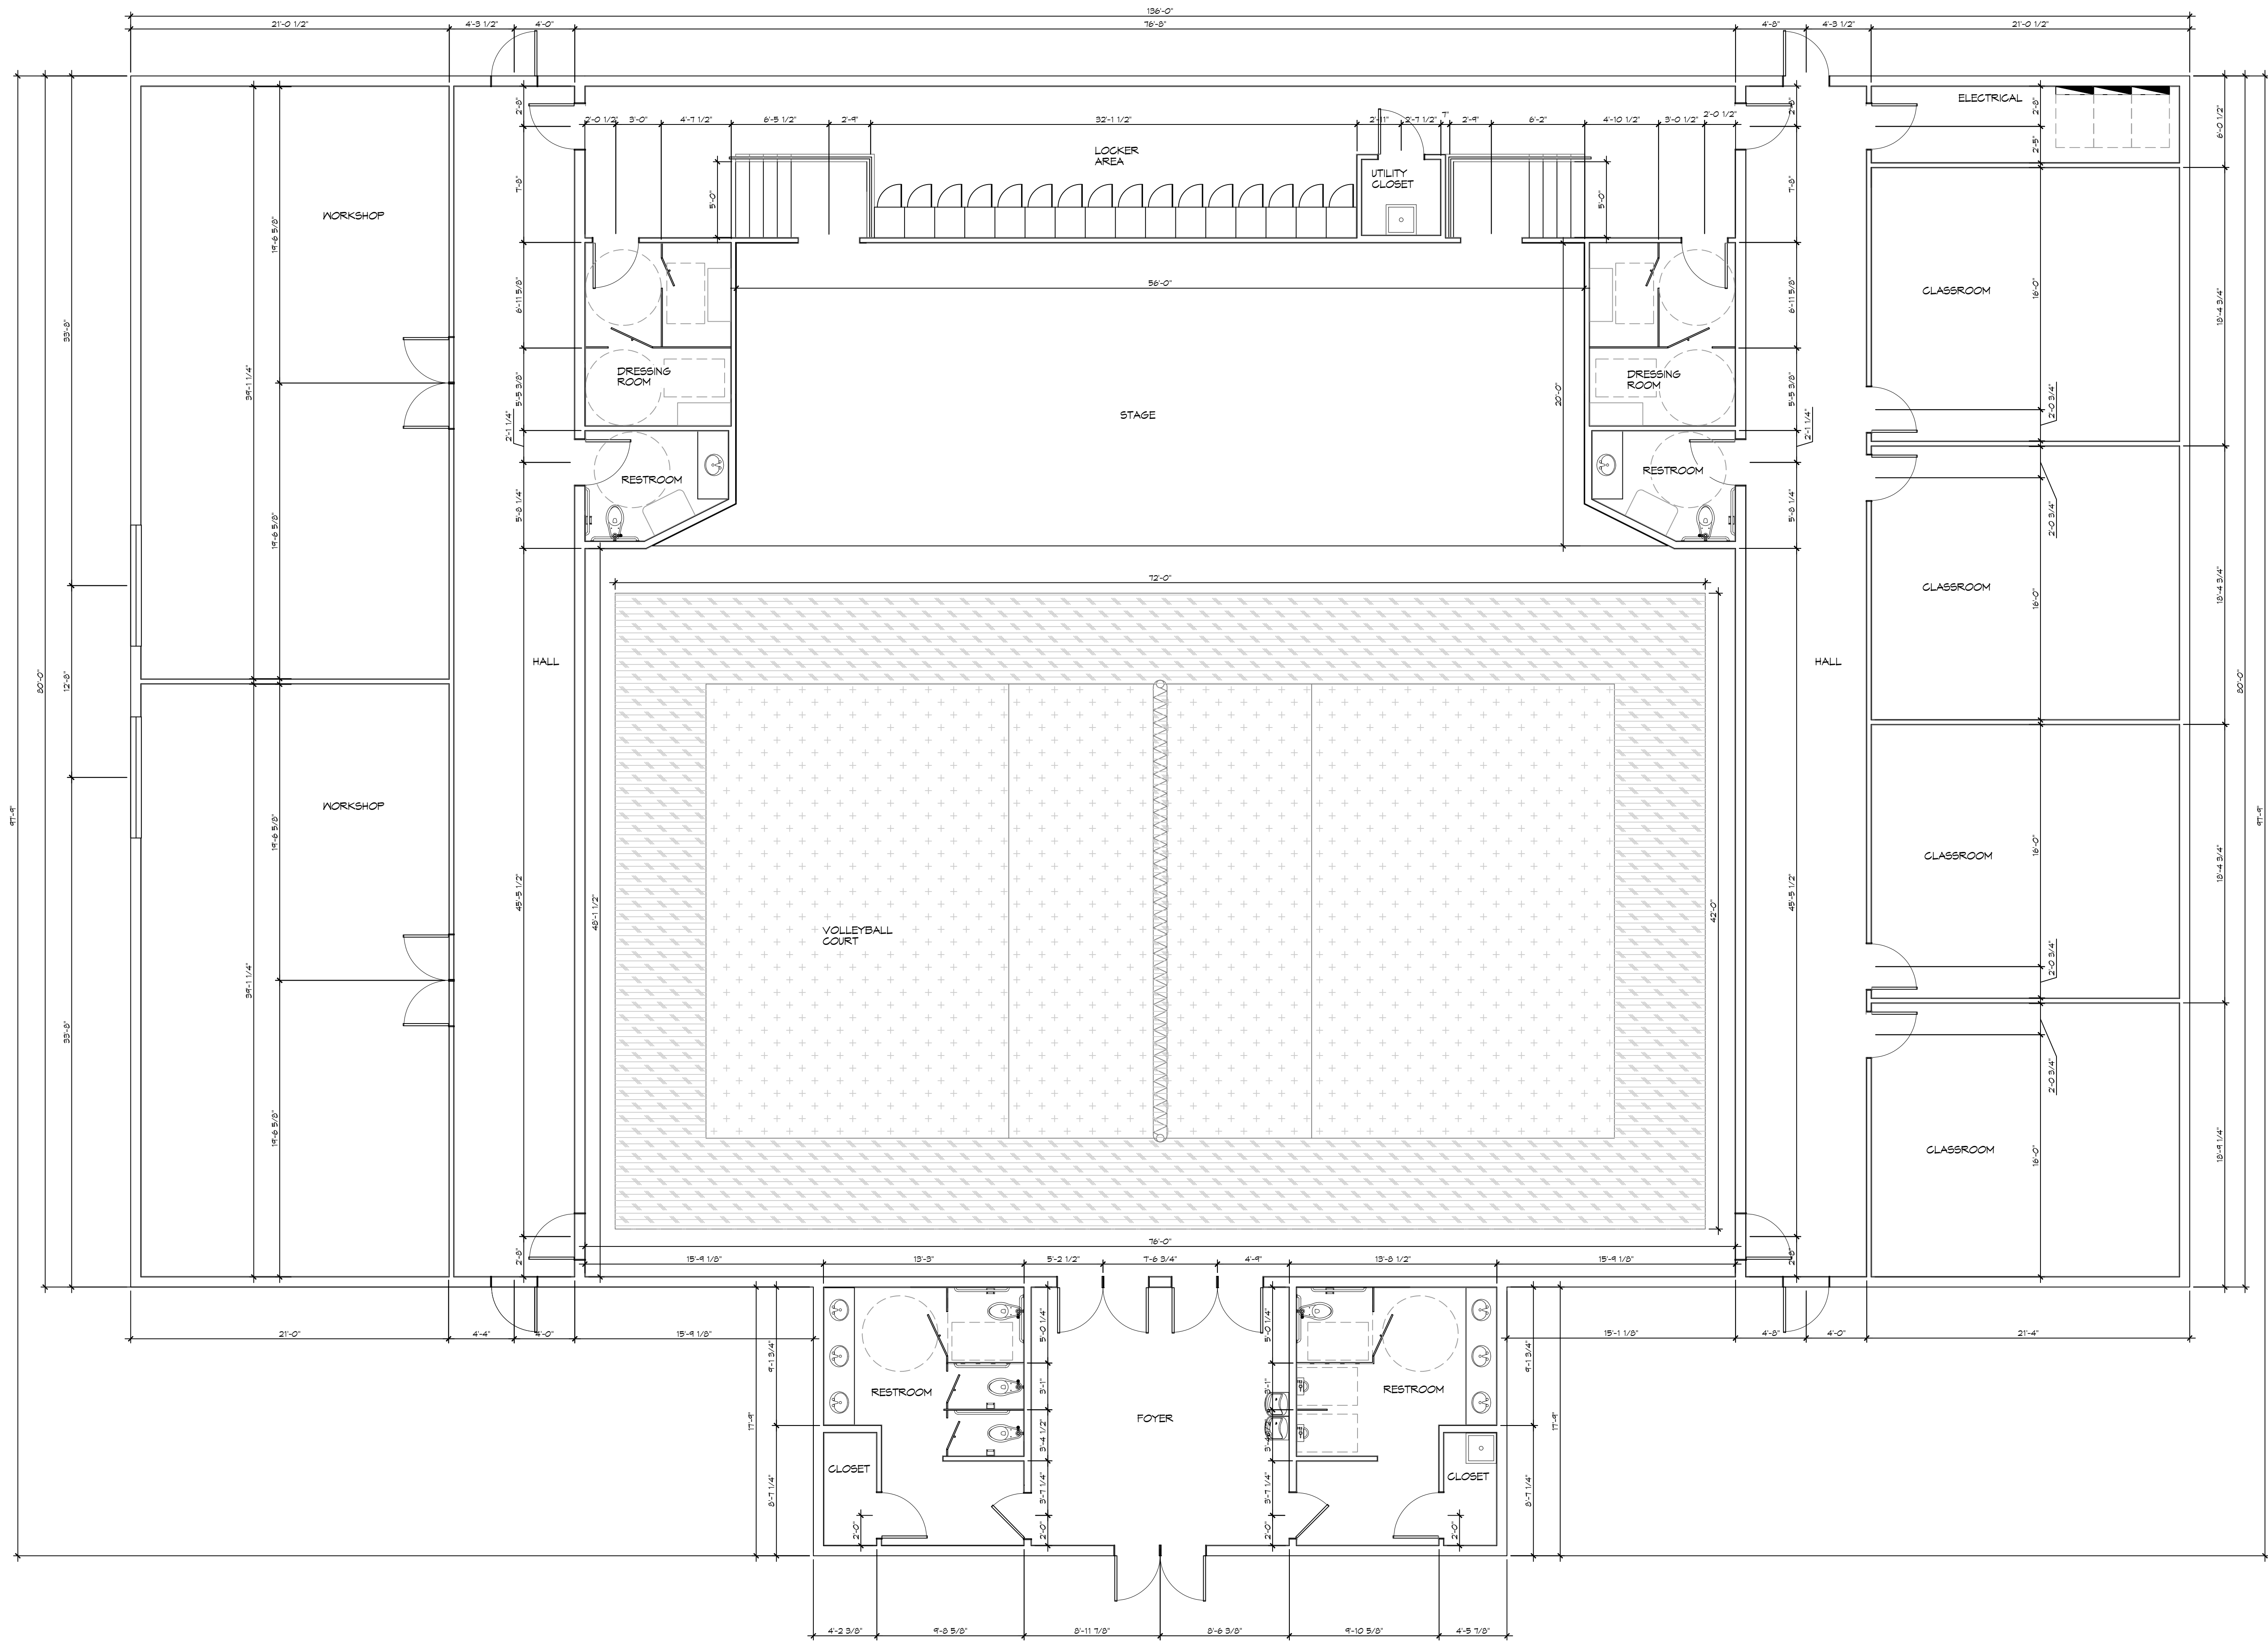

1 FLOOR PLAN
 SCALE: 3/16"=1'-0"

DAMMON
ENGINEERING, INC.
 LOUISIANA & MISSISSIPPI
 Chief Engineer: Brian Mistich, PE
 554 Old Spanish Trail
 Slidell, LA 70458
 www.dammonengineering.com
 info@dammonengineering.com
 PH: 985.649.8832 F: 985.641.5950

#	DESCRIPTION	REVISIONS	DATE

--	--

POPE JOHN PAUL
AUDITORIUM
 5770 LEGGETT ROAD
 SLIDELL, LA 70460
 JOB No: 2245 DATE: 10-22-2024
 DRAWN BY: CKD CHECKED BY: JMS

SHEET TITLE:
 FLOOR PLAN

DRAWING NUMBER:
A101
 SHEET No: 1 of 1

