


**2 Pool House Plan-Framing Plan**

SCALE: 1/4" = 1'-0"

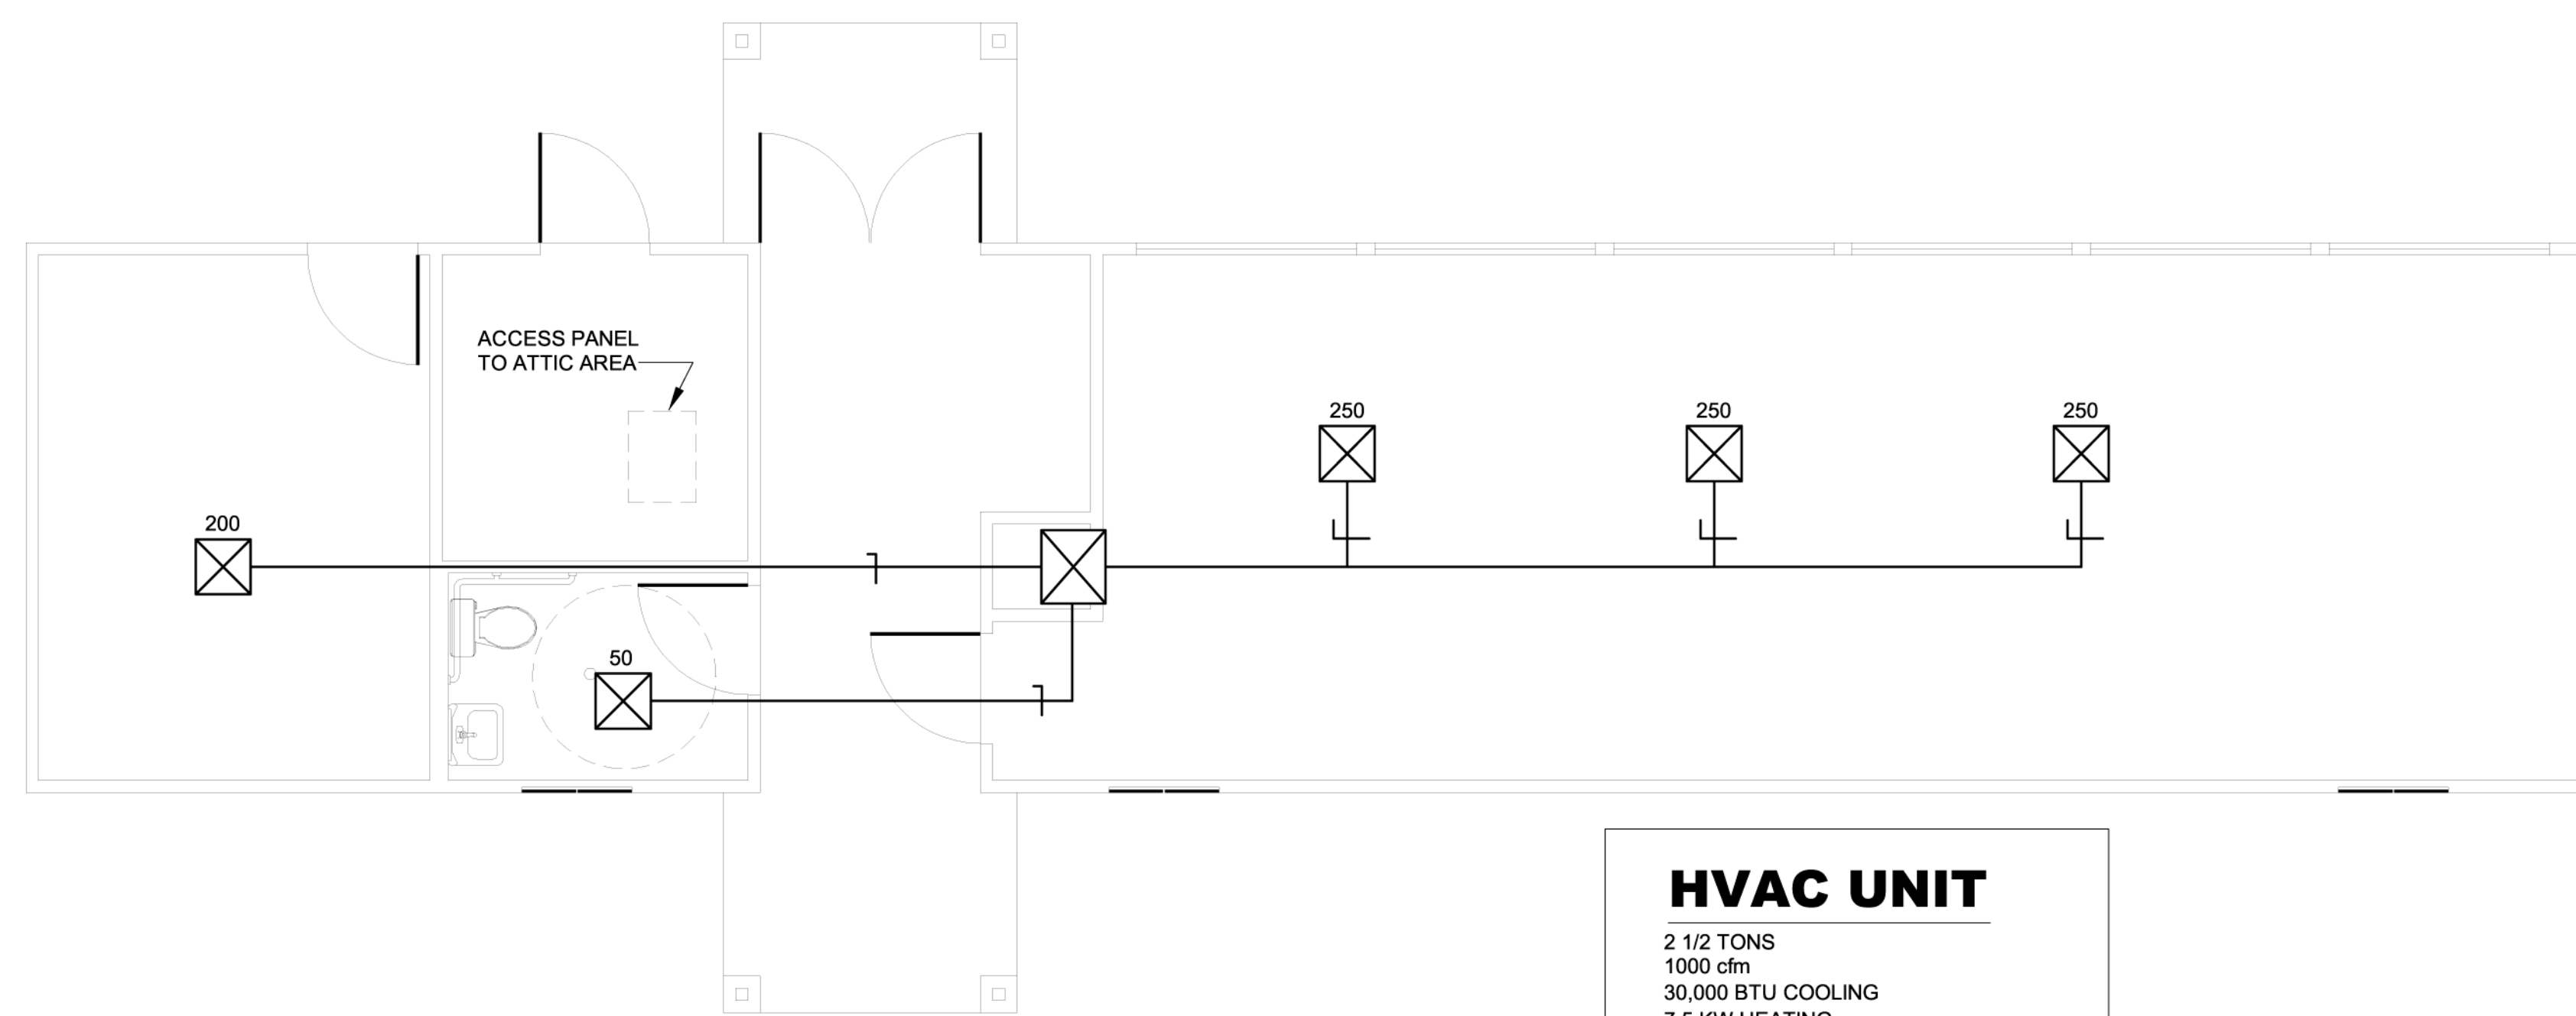

**HVAC UNIT**


2 1/2 TONS  
 1000 cfm  
 30,000 BTU COOLING  
 7.5 KW HEATING  
 (10 SEER MINIMUM)

**1 Pool House Plan-Mechanical Plan**

SCALE: 1/4" = 1'-0"

JAMES D. DODDS  
 ARCHITECT A.I.A.  
 C. DALE HOTARD  
 ARCHITECT A.I.A.  
 409 North Seventh Street  
 BATON ROUGE, LA 70802  
 (225) 215-1777  
 studio@qwikbox.com

The  
**Architectural  
 Studio**  
 A PROFESSIONAL ARCHITECTURAL CORPORATION

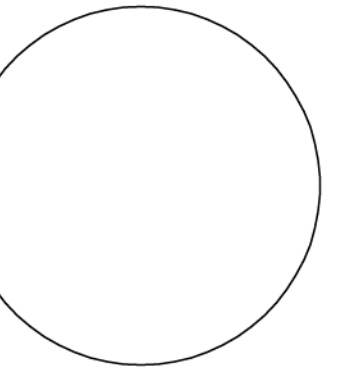

REVISIONS

**HARBORSIDE APARTMENTS**  
 OAK HARBOR DRIVE  
 SLIDELL, LOUISIANA  
 HARBORSIDE, LLC  
 4632 PONTCHARTRAIN DRIVE SLIDELL, LA 70458-5501  
 PROJ. NO.: 03-2162 FILE: 2162-DT10 DRAWN BY: WSTM

SHEET TITLE  
 Pool House

SHEET  
**DT10**  
 59 OF 76  
 DATE: 8.08.03