


PARTIAL FIRST FLOOR REFLECTED CEILING PLAN
SCALE: 3/16"=1'-0"

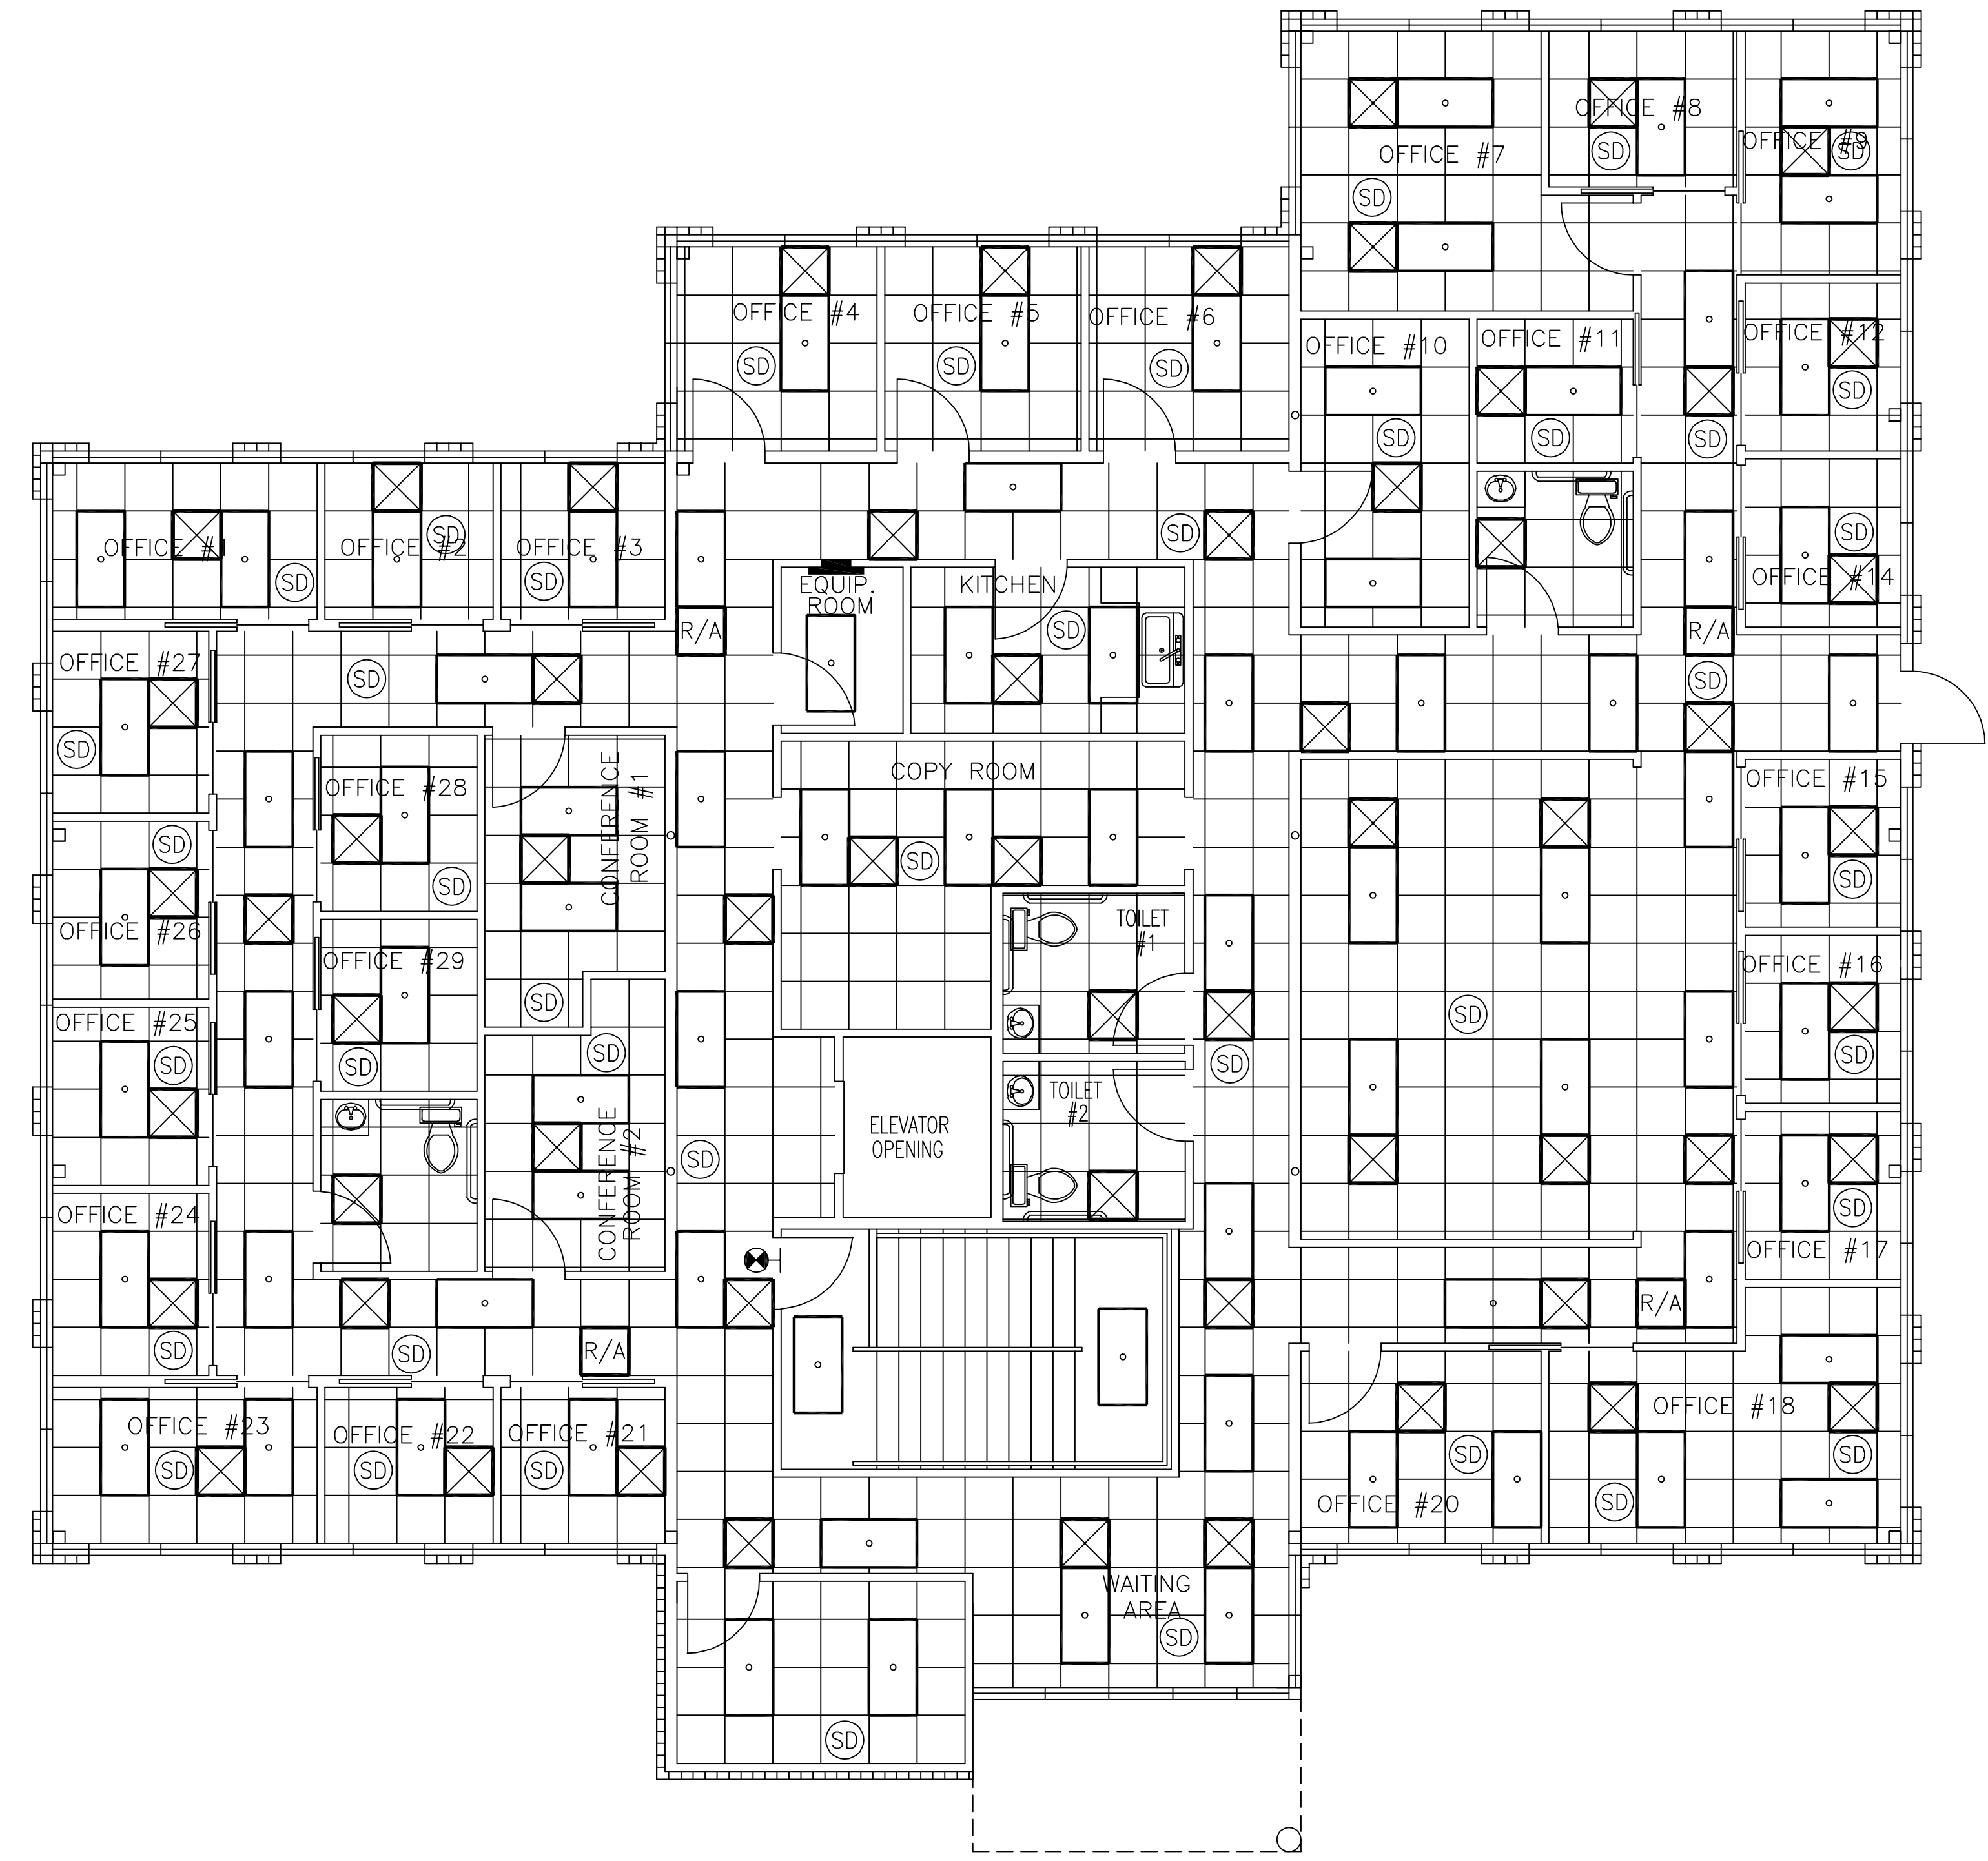

SECOND FLOOR REFLECTED CEILING PLAN
SCALE: 3/16"=1'-0"

- LEGEND**
- ⊗ - WALL SCONCE-75W
 - ⊕ - LIGHT FOR ELEVATOR
 - [F2] - VENT/LIGHT
 - ⦿ - EXIT LIGHT, BATTERY BACK-UP
 - ⊗ - RECESSED LIGHT
 - ⚡ - EMERGENCY LIGHT, BATTERY BACK-UP
 - ◻ - 2x4 FLUORESCENT FIXTURE 4T/F40/C.W.
 - ⊙ - SMOKE DETECTOR
 - - POWER PANEL
 - ⚡ - SWITCH
 - ⊕ - DUPLEX RECEPTACLE
 - WP⊕ - WEATHERPROOF OUTLETS
 - ⊕ - SAFETY SWITCH
 - ⊗ - SUPPLY AIR
 - [R/A] - RETURN AIR

REVISED 2/21/03

FIRST FLOOR ELECTRICAL
ABEK REAL ESTATE
ABEK REAL ESTATE
OAK HARBOR DR.
SLIDELL, LOUISIANA

ABEK REAL ESTATE
DAMMON ENGINEERING, INC.
ARCHITECTS - ENGINEERS
2000 OLD SPANISH TRAIL, SUITE 100, 985-649-5832, SLIDELL, LA. 70458
DAMMONENGINEERING.COM

SCALE: AS NOTED

FILE:

JOB NO. 1489

DATE: 2-21-03

SHEET

A-6

OF