



SECOND FLOOR

CCT. NO.	LOAD DESCRIPTION	BREAKER	LOAD (VA)	AP			LOAD (VA)	BREAKER	LOAD DESCRIPTION	CCT. NO.
				AMP	POLE	POLE				
1	OFFICE 22,21,20,23,24, 25,26,1,2,3 LIGHTS	20	1				1	OFFICE 28, 27, AND CONF. ROOM 1,2 OUTLETS	2	
3	OFFICE 20,21,22 OUTLETS	20	1				1	OFFICE 29,28,27, AND CONF. ROOM 1,2, AND HALLWAY LIGHTS	4	
5	OFFICE 22,23,24 OUTLETS	20	1				1	OFFICE 27,28,29 OUTLETS	6	
7	OFFICE 26,1,2 OUTLETS	20	1				1	KITCHEN OUTLETS	8	
9	TOILETS VENT/LIGHT	20	1				1	EXIT LIGHTS	10	
11	SPARE	20	1				1	OFFICE 18, 19, AND WAITING AREA OUTLETS	12	
13	OPEN AREA OUTLETS	20	1				1	OFFICE 15,16,17 OUTLETS	14	
15	OFFICE 8,9,12 OUTLETS	20	1				1	OFFICE 11,13,14 OUTLETS	16	
17	OFFICE 7,8,9,12,14,4,5,6 LIGHTS	20	1				1	OFFICE 18,19,17,16,15 LIGHTS	18	
19	KITCHEN, STORAGE, COPY, AND OFFICE 10,11,13 LIGHTS	20	1				1	WAITING AREA, RECEPTIONIST, AND HALLWAY LIGHTS	20	
21	OFFICE #28 AND HALL LIGHTS	20	1				1	FLOOD LIGHTS	22	
23	WEATHERPROOF OUTLETS	20	1				1	OFFICE 2,3,4,5 OUTLETS	24	
25	EMERGENCY LIGHTS	20	1				1	SMOKE DETECTORS	26	
27	OFFICE 5, 6, 7 OUTLETS	20	1				1	OFFICE 10, 11, 7 OUTLETS	28	
29	SPARE	20	1				1	COPY ROOM OUTLETS	30	
31	A/C #1 BLOWER	30	3				1	HOT WATER HEATER	32	
33							1	OFFICE #28 OUTLETS	34	
35							1	SPACE	36	
37							1	SPACE	38	
39	MAN	250	3				1	SPACE	40	
41							1	SPACE	42	

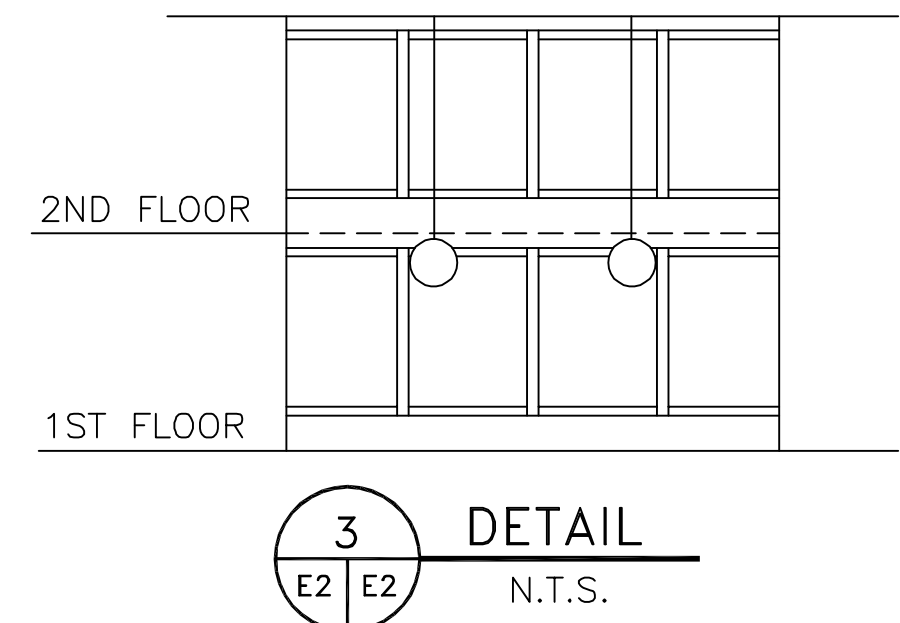

- LEGEND**
- ⊙ - LIGHT-75W
 - ⌈F2⌋ - VENT/LIGHT
 - ⬆ - EXIT LIGHT, BATTERY BACK-UP
 - ⬆ - 2x4 FLUORESCENT FIXTURE 4T/F40/C.W.
 - ⬆ - EMERGENCY LIGHT, BATTERY BACK-UP
 - ⬆ - DOWN LIGHT
 - ⊙SD - SMOKE DETECTOR
 - ⬆ - TELEPHONE/COMPUTER
 - ⬆ - POWER PANEL
 - ⌘ - SWITCH
 - ⊙ - THERMOSTAT WITH LOCK BOX
 - ⊙WH - HOT WATER HEATER WITH SAFETY SWITCH (ABOVE BATHROOMS)
 - ⊙ - DUPLEX RECEPTACLE
 - ⊙WP - WEATHERPROOF OUTLETS
 - ⊙J - JUNCTION BOX
 - ⊙ - GFI
 - ⊙ - SUPPLY AIR
 - ⊙R/A - RETURN AIR

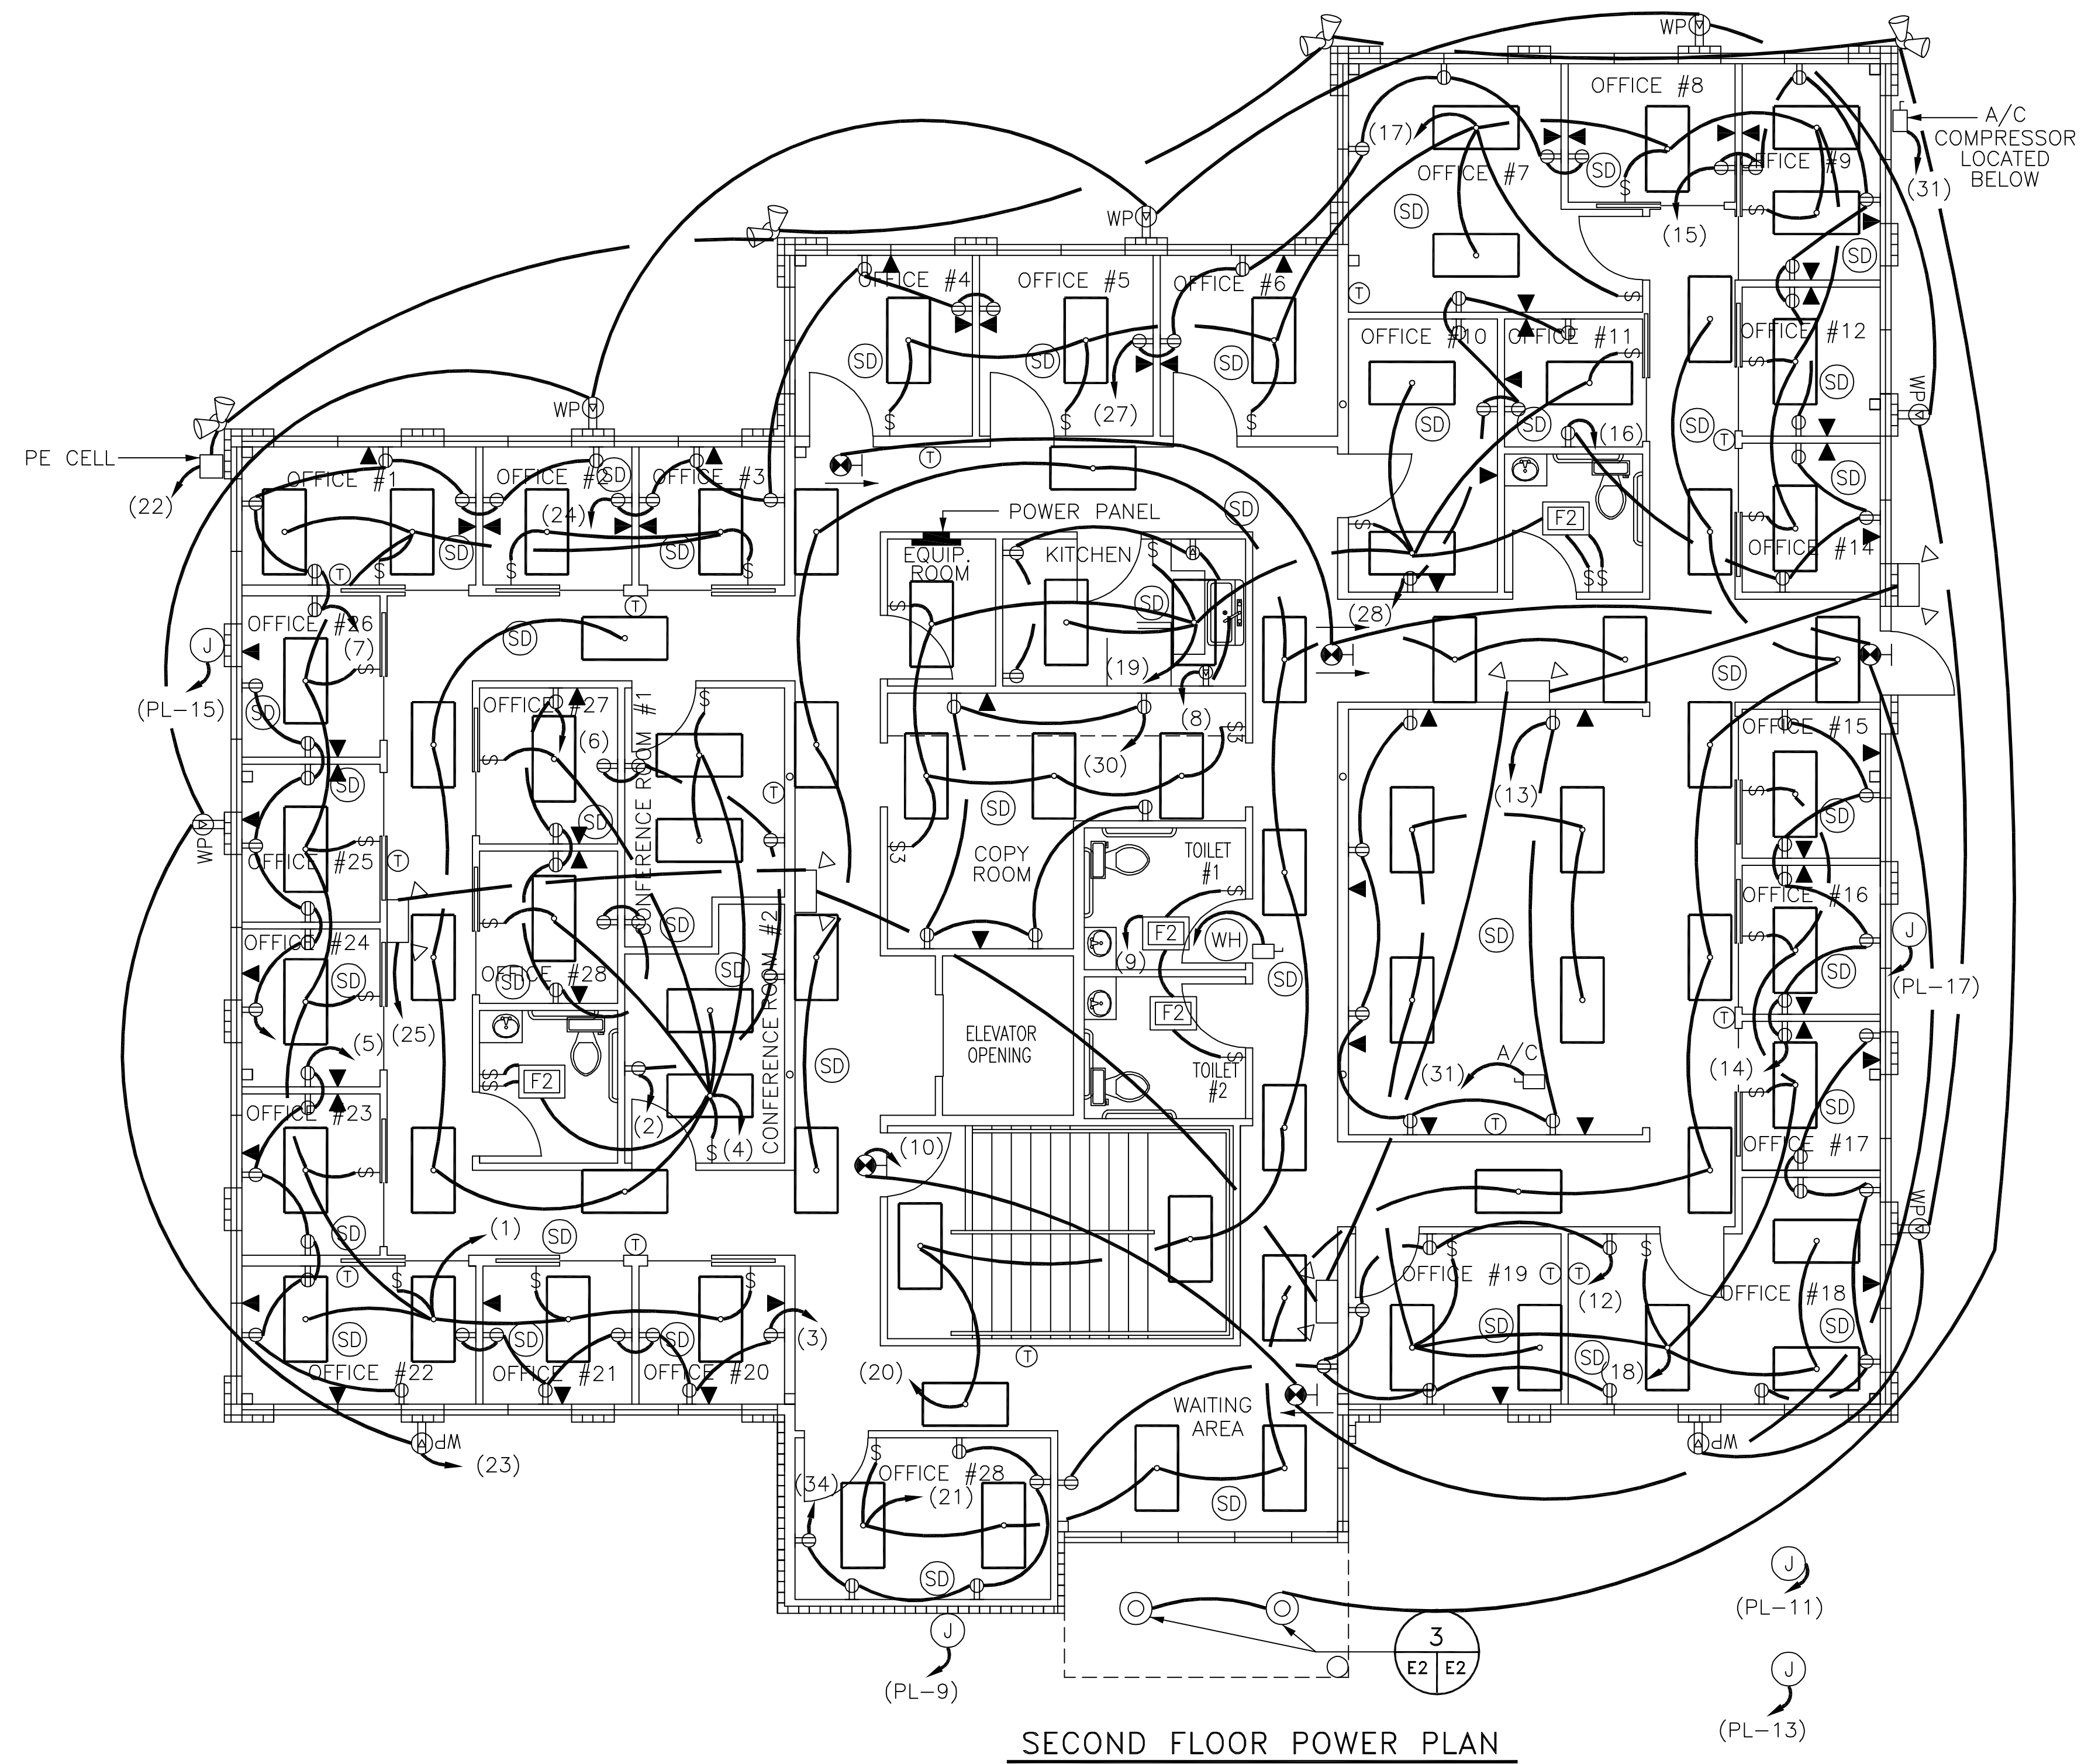

SECOND FLOOR POWER PLAN
SCALE: 3/16"=1'-0"

NEW OFFICE BUILDING
SECOND FLOOR ELECTRICAL
OAK HARBOR DR.
SLIDELL, LOUISIANA

ABEK REAL ESTATE
DAMMON ENGINEERING, INC.
ARCHITECTS - ENGINEERS
2000 OLD SPANISH TRAIN, STE. 100 985-649-5832 SLIDELL, LA. 70458
DAMMONENGINEERING.COM

SCALE: AS NOTED
FILE:
JOB NO. 1489
DATE: 2-21-03
SHEET
E-2
OF

REVISED 2/21/03