



DOOR SCHEDULE							
MK	WIDTH	HEIGHT	THK	DOOR MAT	FRAME	FR	REMARKS
D01	3'-0"	6'-8"	1-3/4"	STEEL	METAL	NR	TWO PANEL PUSH PULL DOOR W/ CLOSER


POWER LEGEND	
	GFCI DUPLEX RECEPTACLE - WALL MOUNTED
	RECESSED LED LIGHT FIXTURE
	THREE WAY LIGHT SWITCH
	EXHAUST FAN
	FLOOR DRAIN

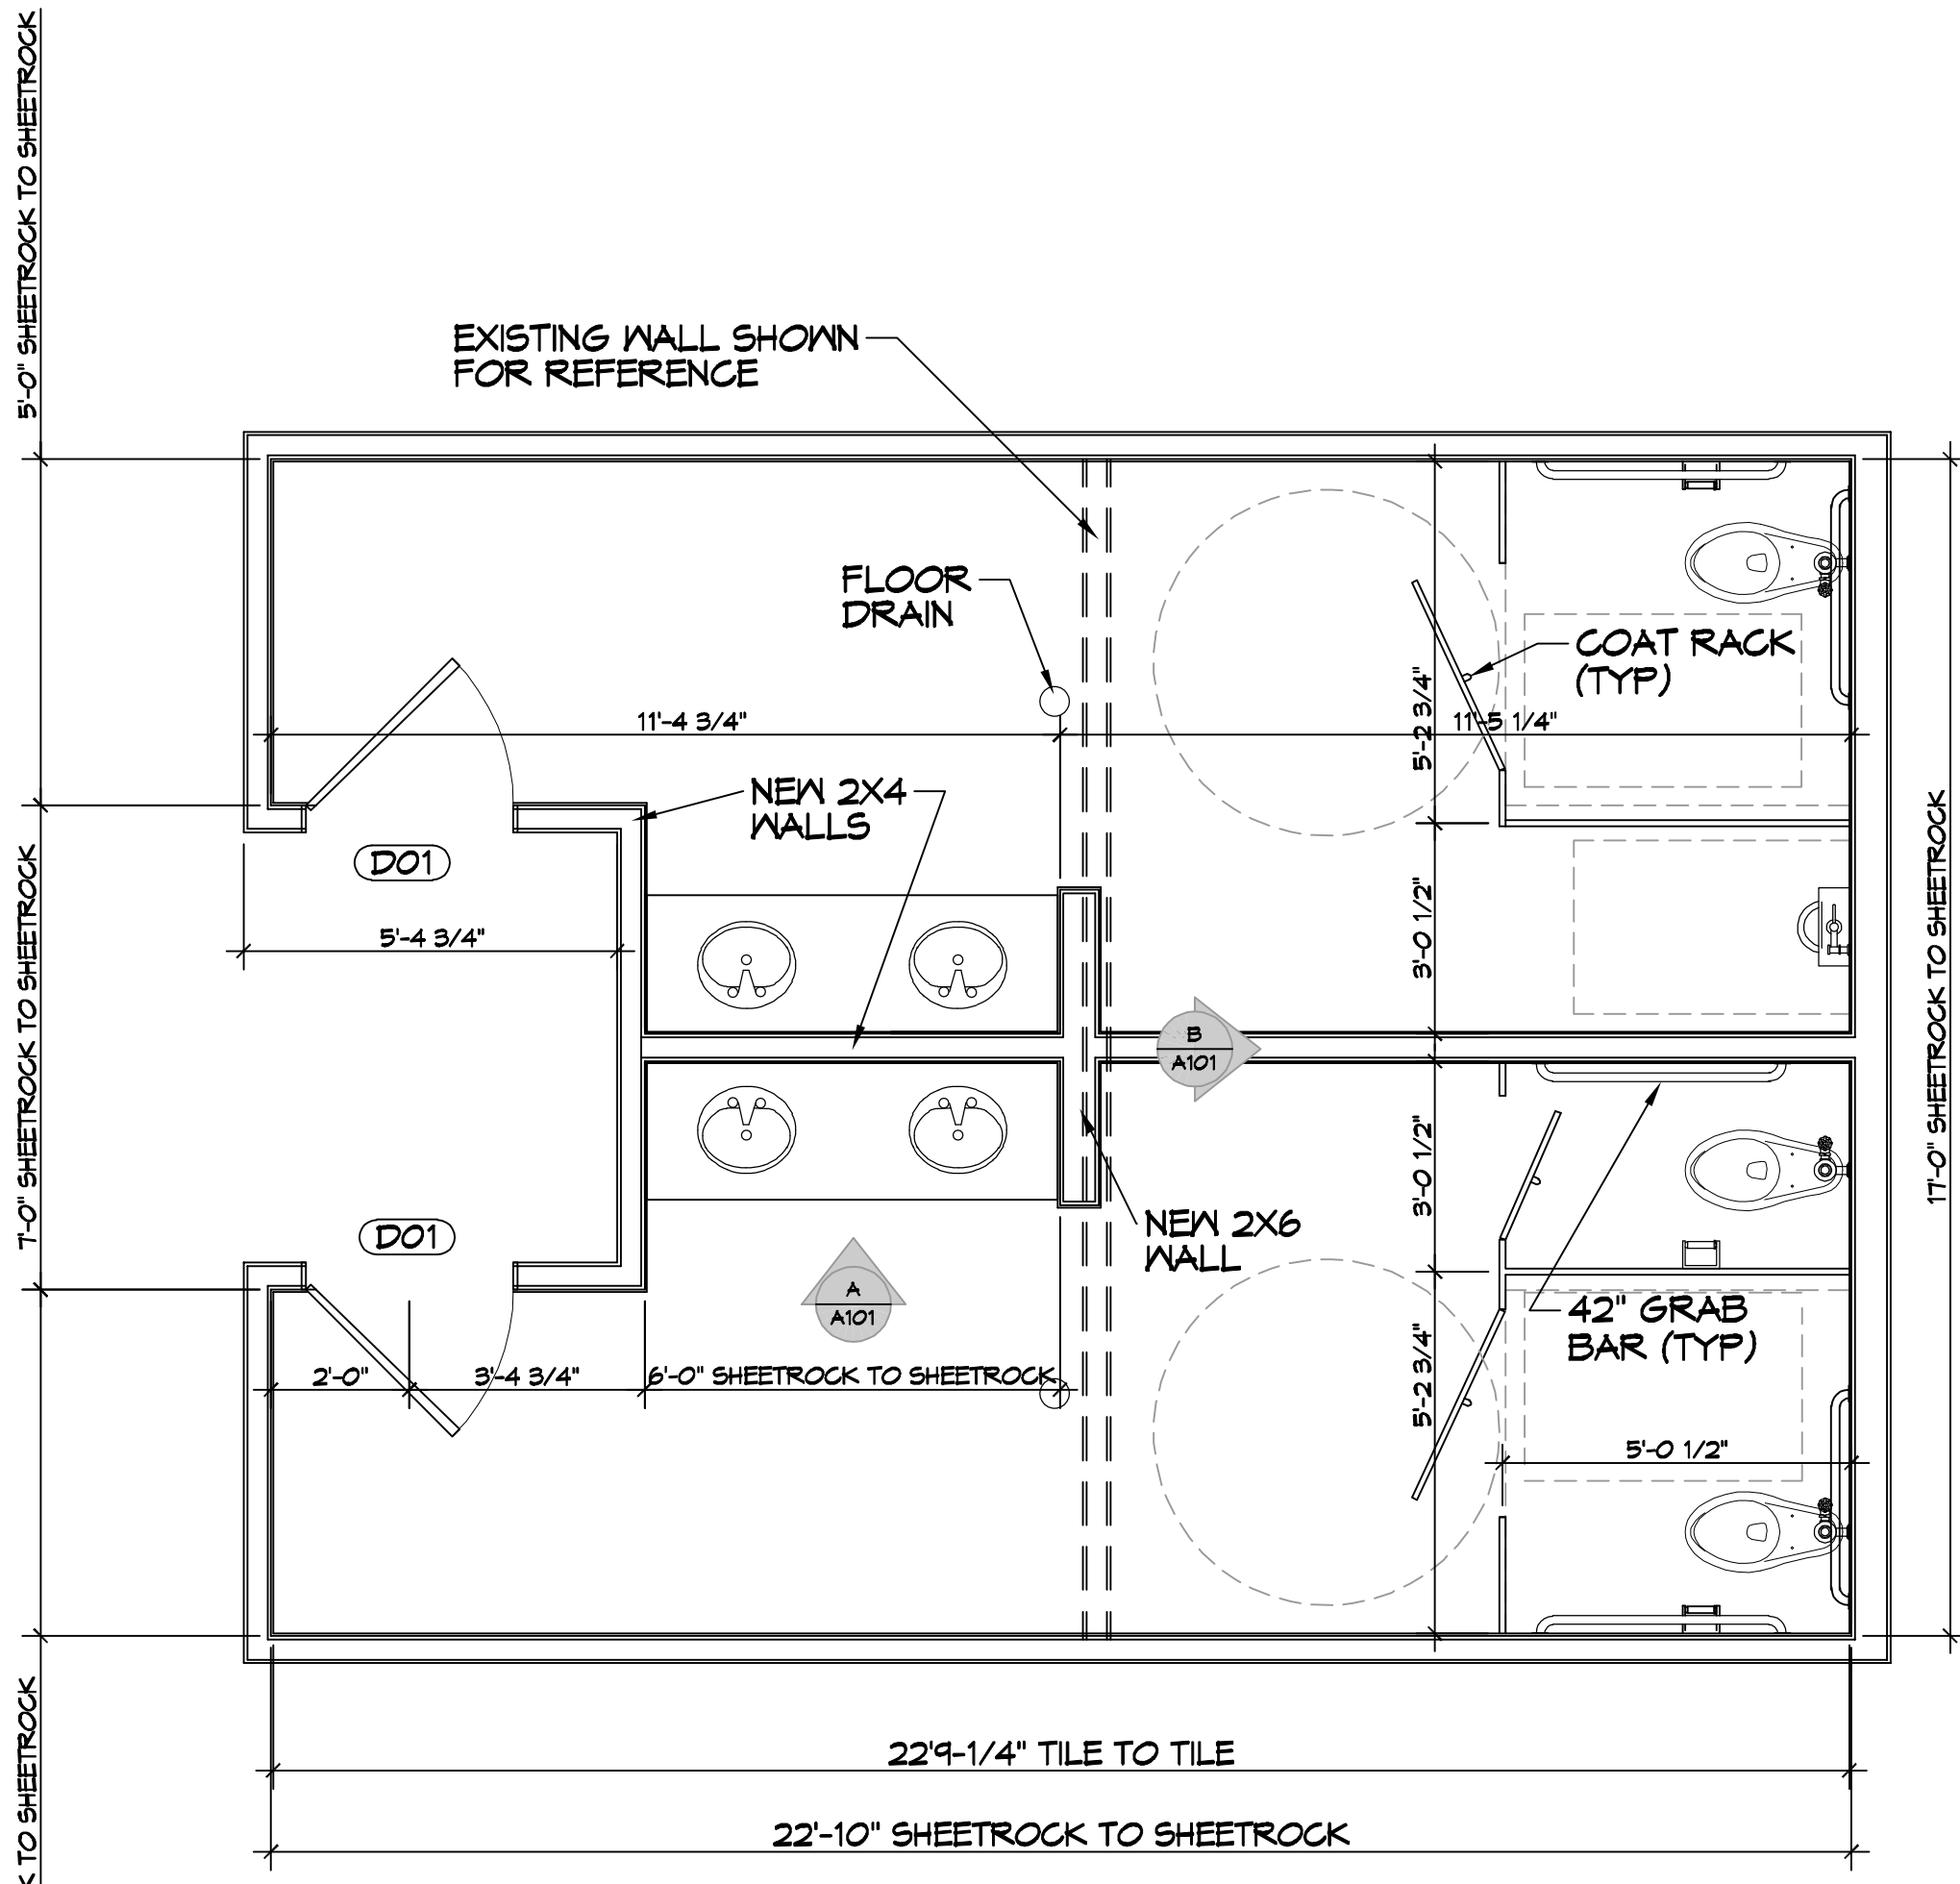


1 FLOOR PLAN
SCALE: 3/8" = 1'-0"

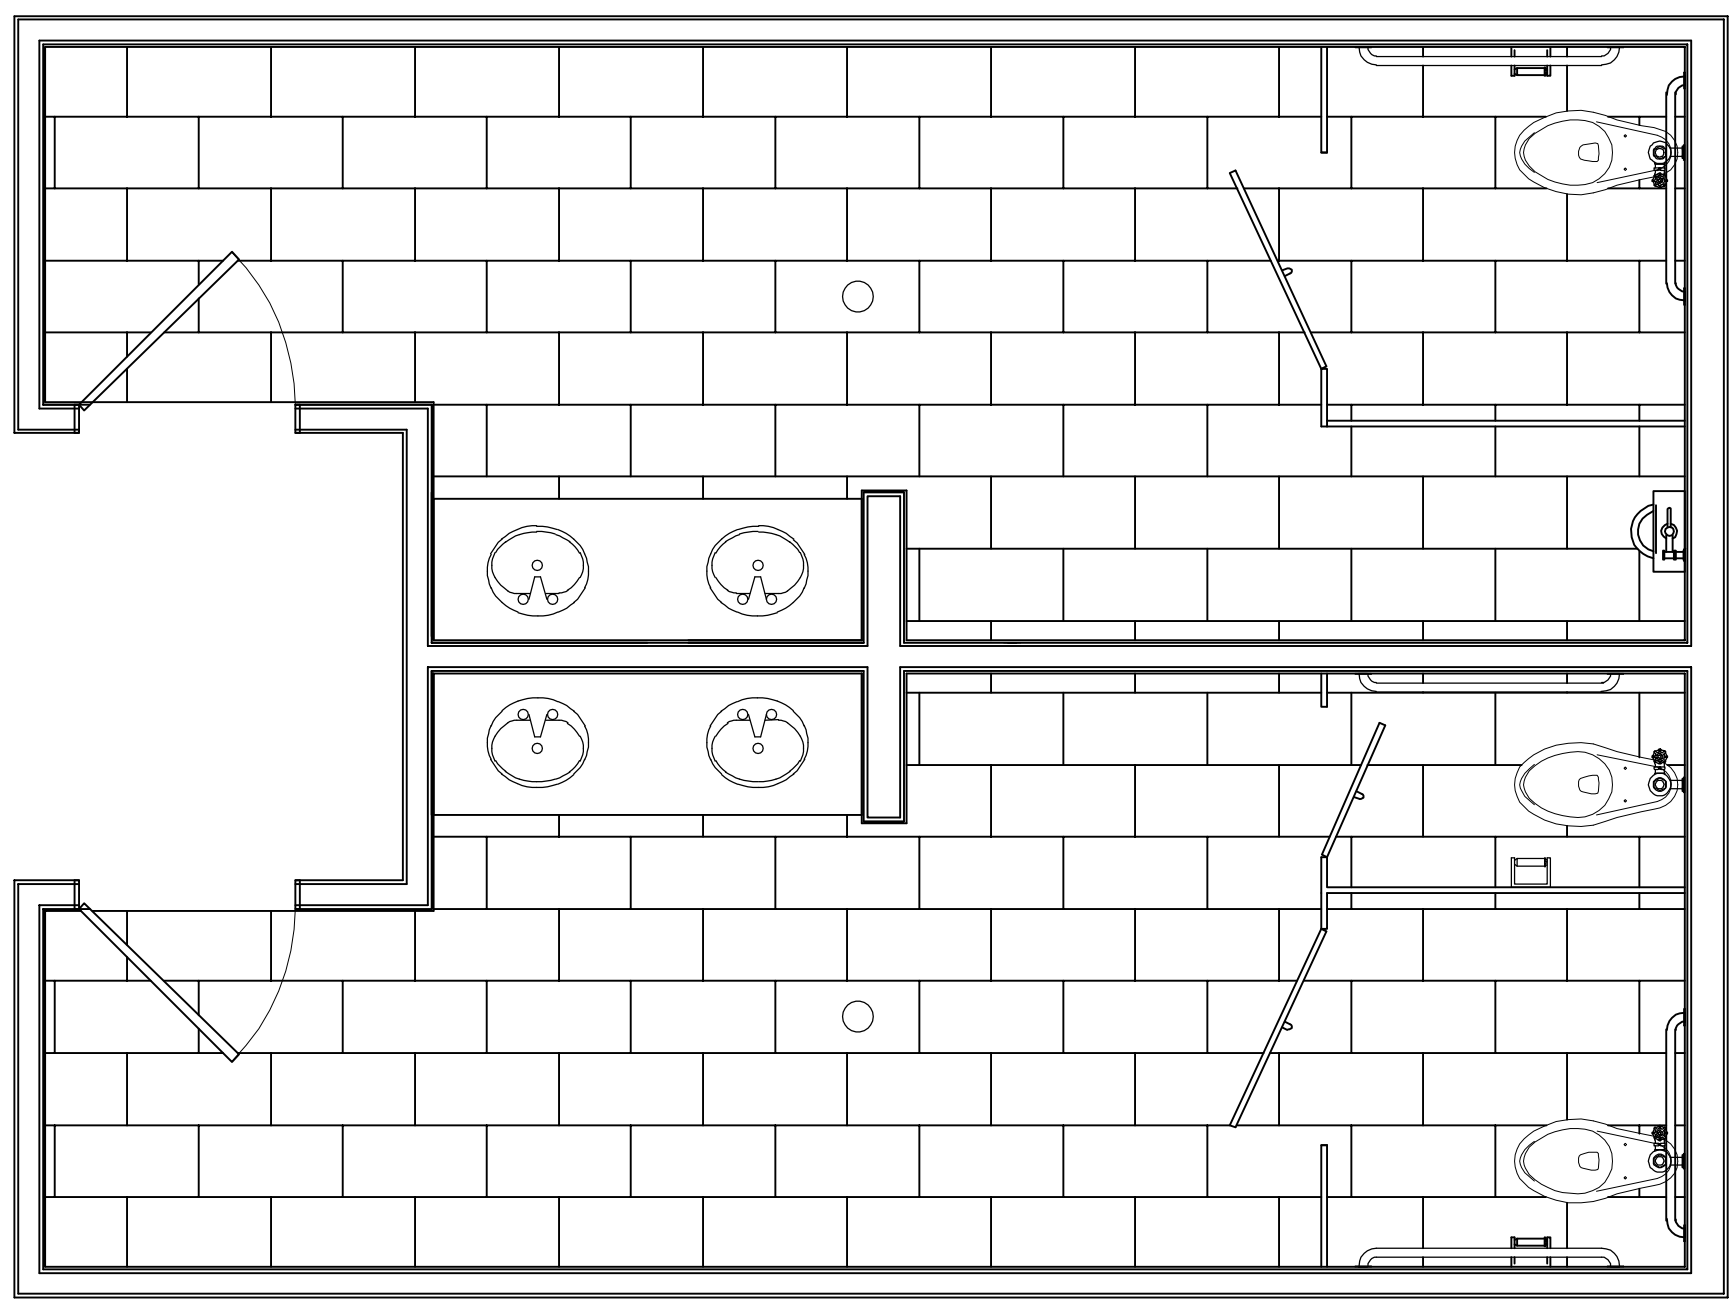


2 FINISH FLOOR PLAN
SCALE: 3/8" = 1'-0"

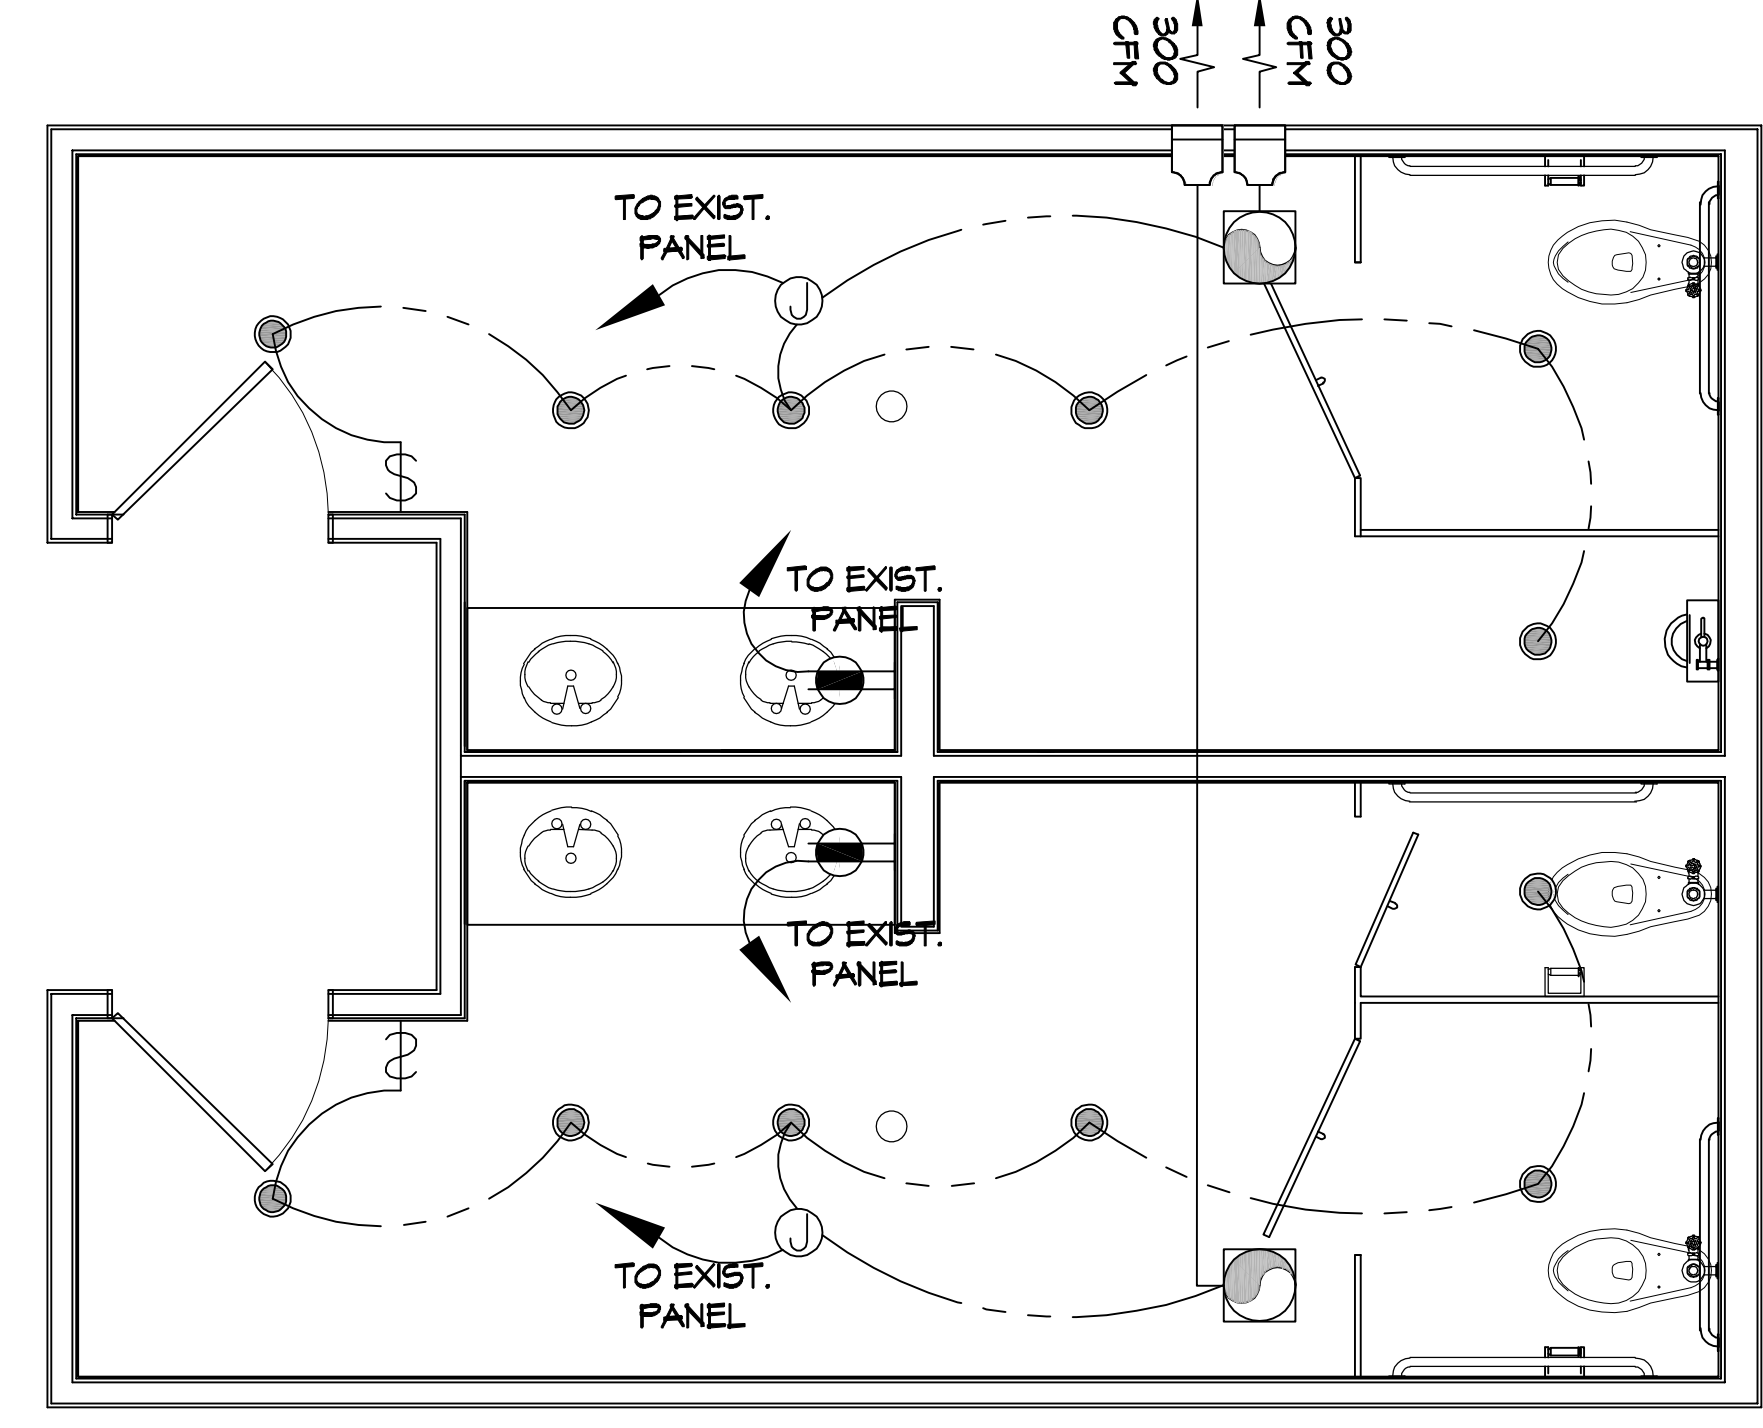


3 ELECTRICAL PLAN
SCALE: 3/8" = 1'-0"

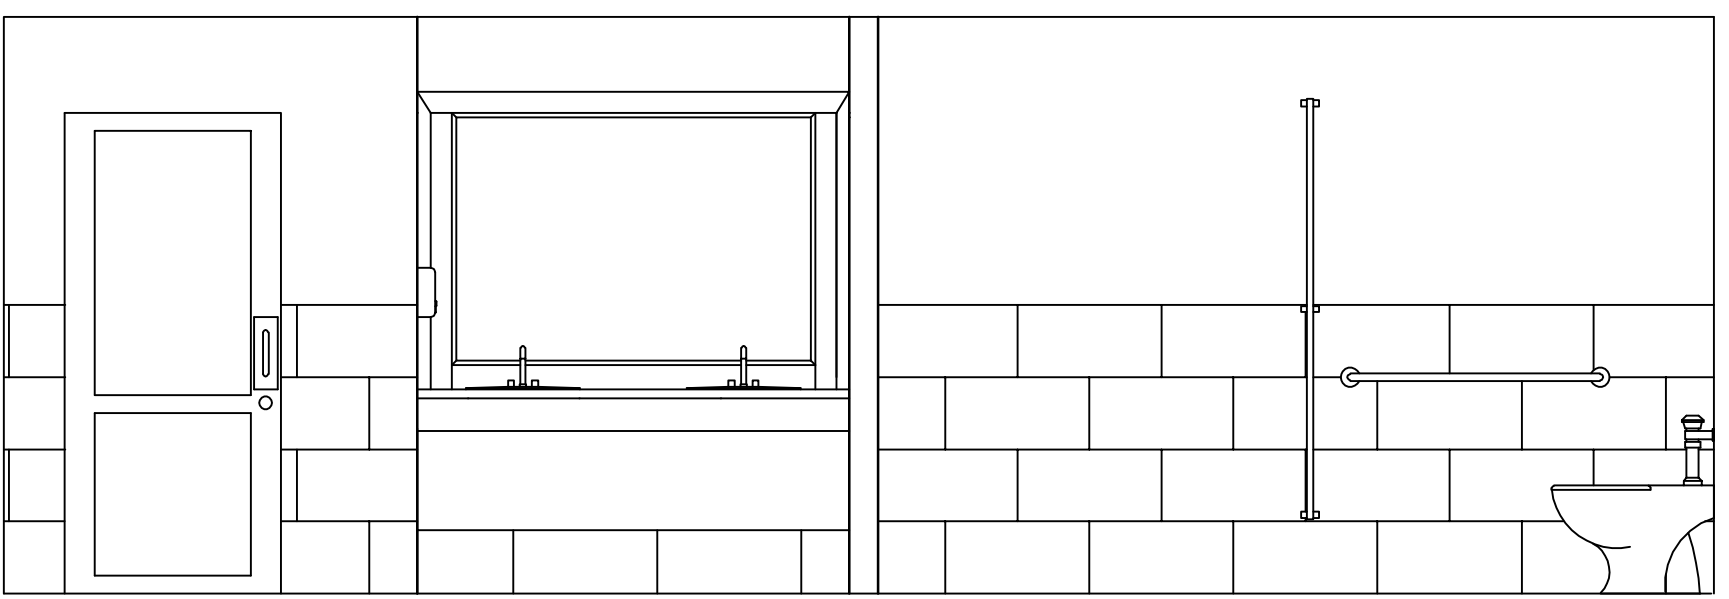

A RESTROOM
SCALE: 3/8" = 1'-0"

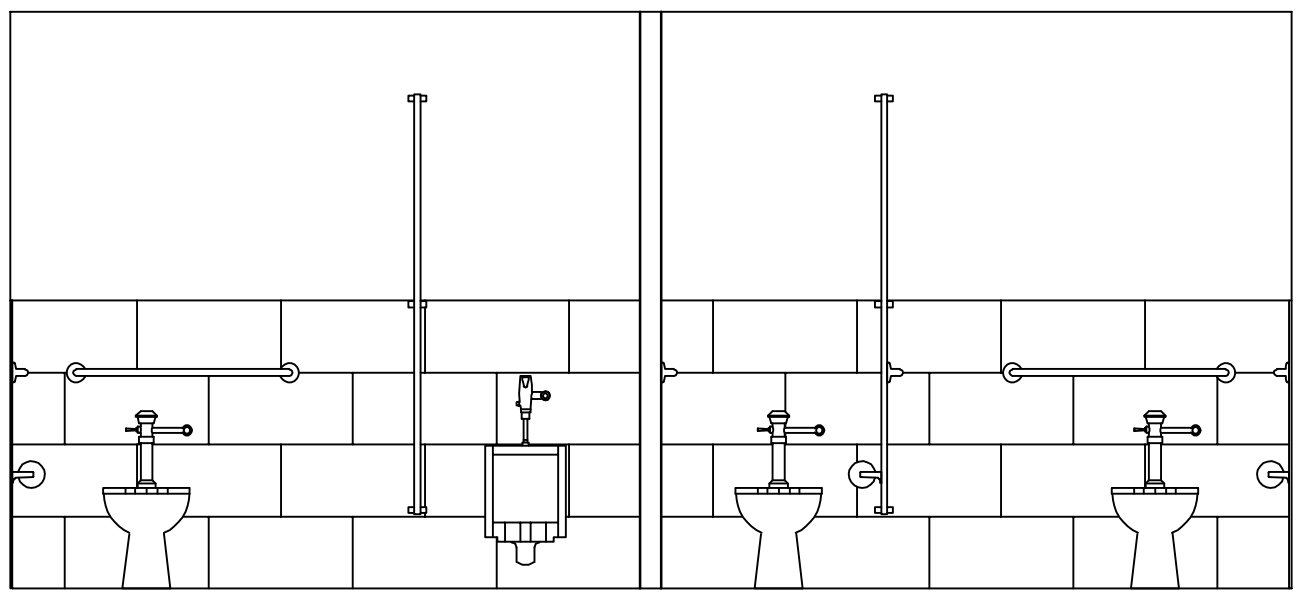

B RESTROOM
SCALE: 3/8" = 1'-0"

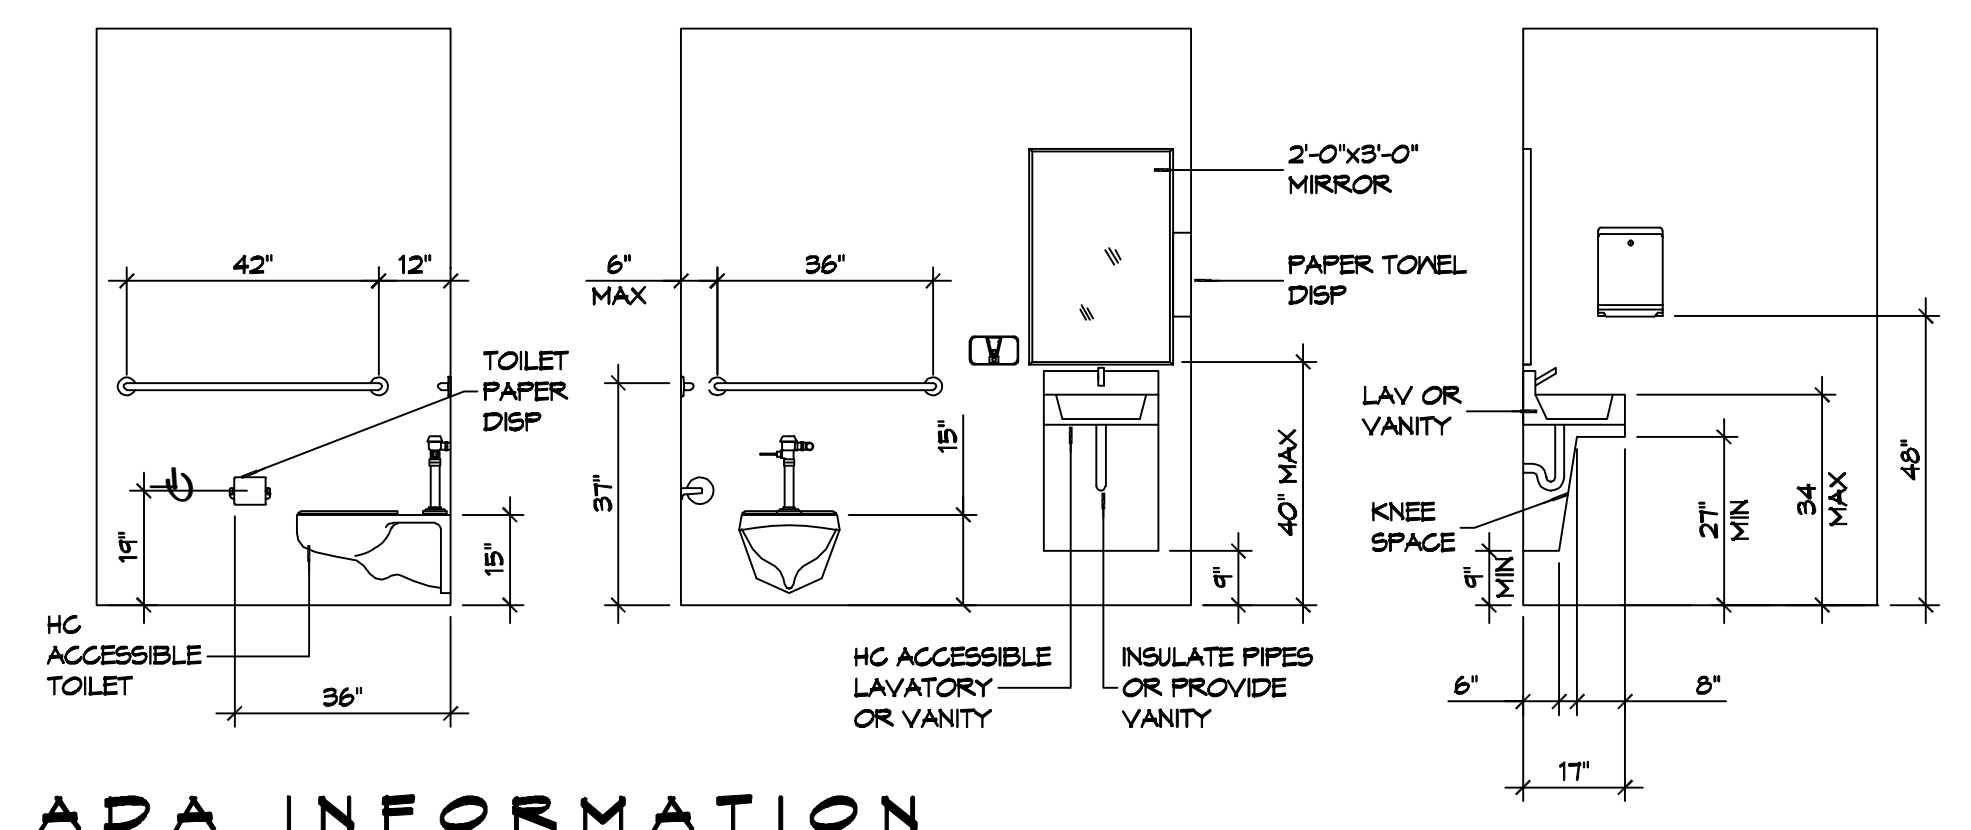

ADA INFORMATION
SCALE: 3/8" = 1'-0"

DAMMON ENGINEERING, INC.
LOUISIANA & MISSISSIPPI
www.dammonengineering.com
info@dammonengineering.com
PH: 985.649.5832

REVISIONS	DATE
# DESCRIPTION	



NEW ADA WOMEN AND MEN'S RESTROOM ELKS LODGE
34212 ELKS ROAD
SLIDELL LOUISIANA 70460
JOB No: 2400 DATE: 10-15-2024
DRAWN BY: CKD CHECKED BY: BAM

SHEET TITLE:
WOMEN & MEN'S RESTROOM FLOOR PLAN, FINISH FLOOR PLAN, ELECTRICAL PLAN ELEVATIONS
DRAWING NUMBER:
A101
SHEET No: 1 of 1