


MECHANICAL PLAN - LEVELS 2 & 3
SCALE: 3/32"=1'-0"

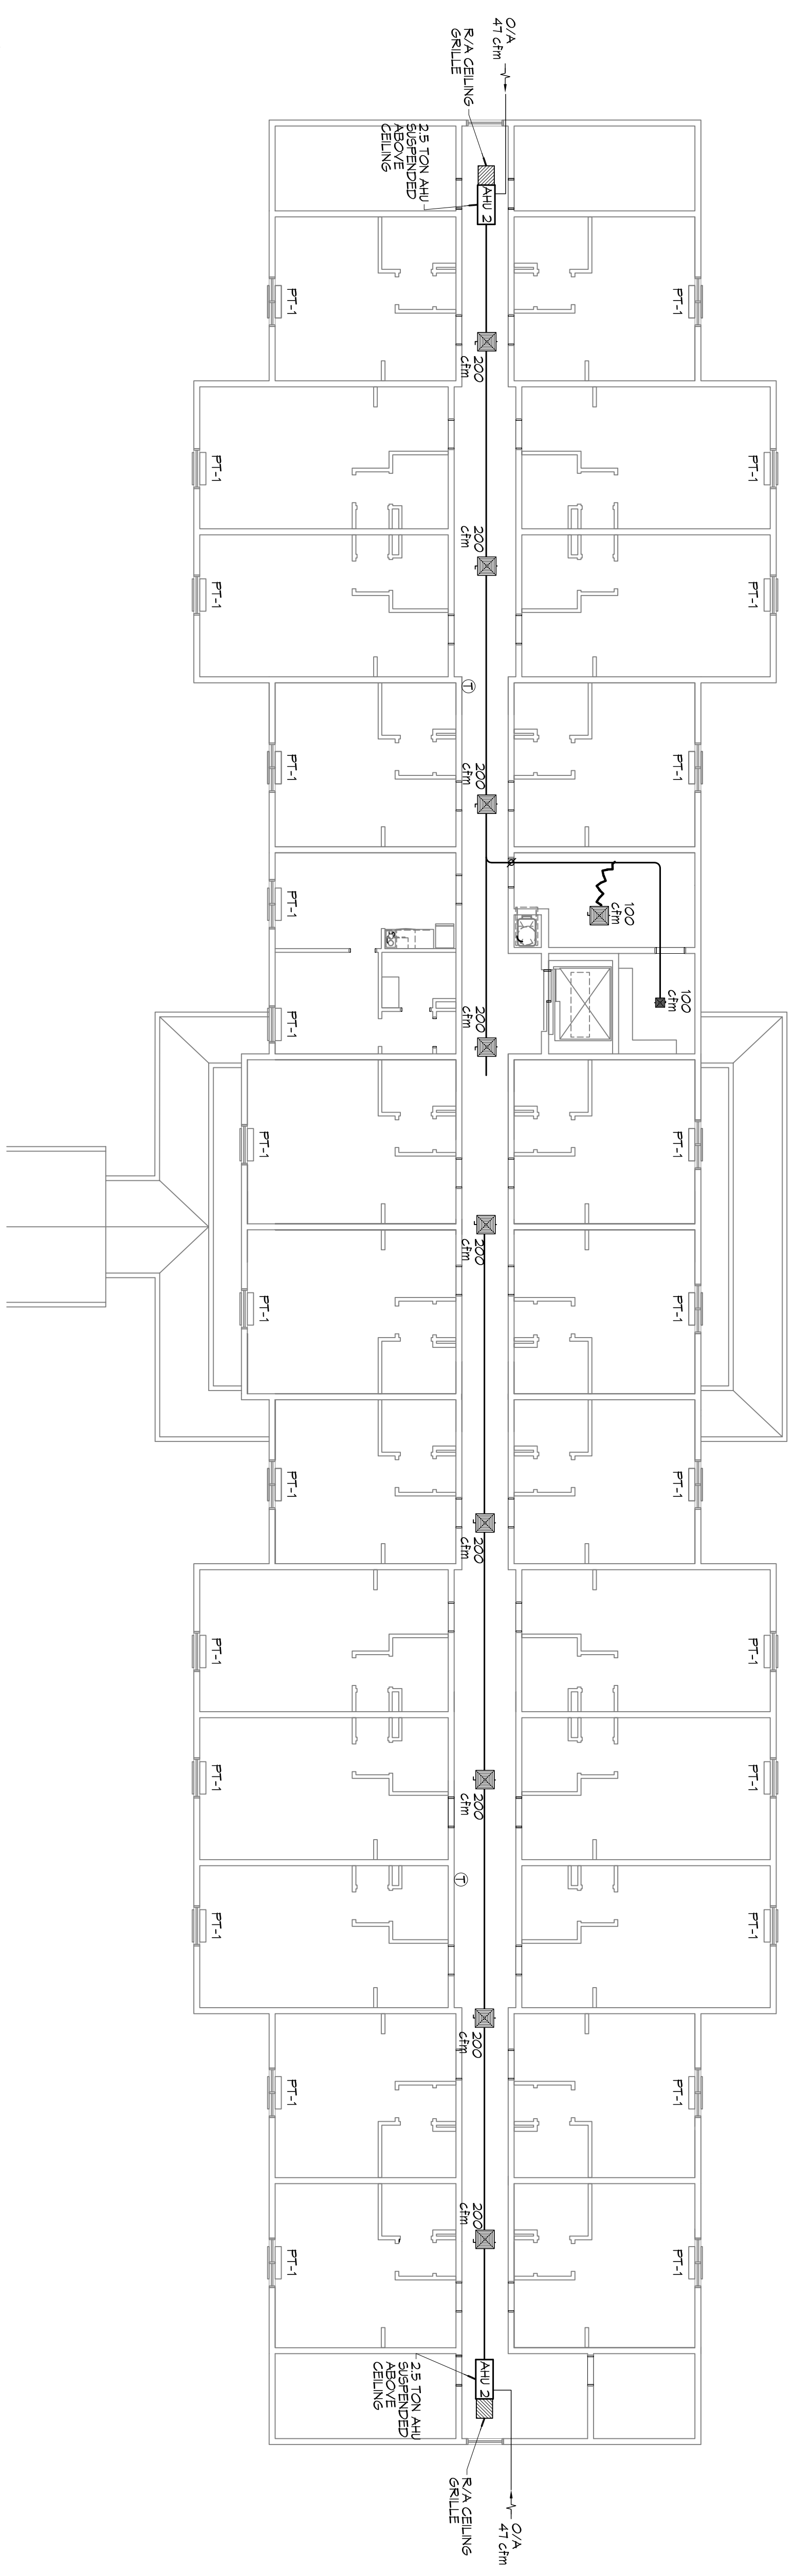

PTAC SCHEDULE									
UNIT	TOTAL BTU	CFM	OA	HEAT (KW)	VOLT	MCA	MAX O.C.F.	MFR	
PT-1 GUESTROOMS	9000	360	36	3.5	208V, 3P	145	20	AMANA	
HALLWAY	36,000 AC	1000	47	10	208V, 3P	10	15	TRANE OR EQUAL	

MAIN STAY SUITES

100 MAIN STREET
LOT #1 LA HWY 27
HACKBERRY, LA 70645

SHEET TITLE:
MECHANICAL PLANS -
LEVELS 2, 3, AND 4


DRAWING NUMBER:

M102

SHEET NO. 44 OF 53

JOB No: 2265 DATE: FEBRUARY, 2016
DRAWN BY: CKD CHECKED BY: BAM

The above drawings and specifications, design and all expressions represented thereby are prepared by or for the engineer, architect, or other professional person named herein and are not to be used in connection with any work or project other than the one for which they were prepared and developed without written consent of Dammon Engineering. Please contact with these drawings or specifications that constitute a contract.

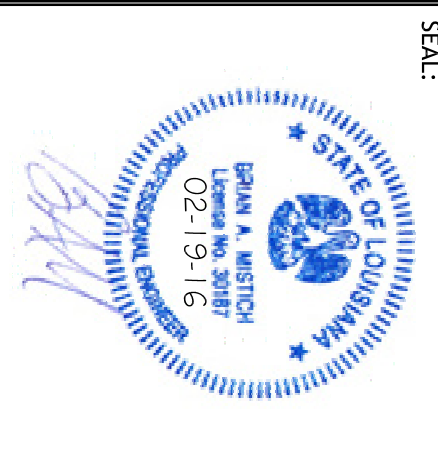

REVISIONS		
#	DESCRIPTION	DATE



Chief Engineer: Brian Mistich, PE
554 Old Spanish Trail
Slidell, LA 70458
www.dammonengineering.com
info@dammonengineering.com
PH: 985.649.5832 F: 985.641.5950