


D:\NAME - A\ - Government\The Village of Slidell\Project\Drawings\1001 - 2nd Floor - 06-17-2025.dwg, 10/17/2025, 10:17 AM

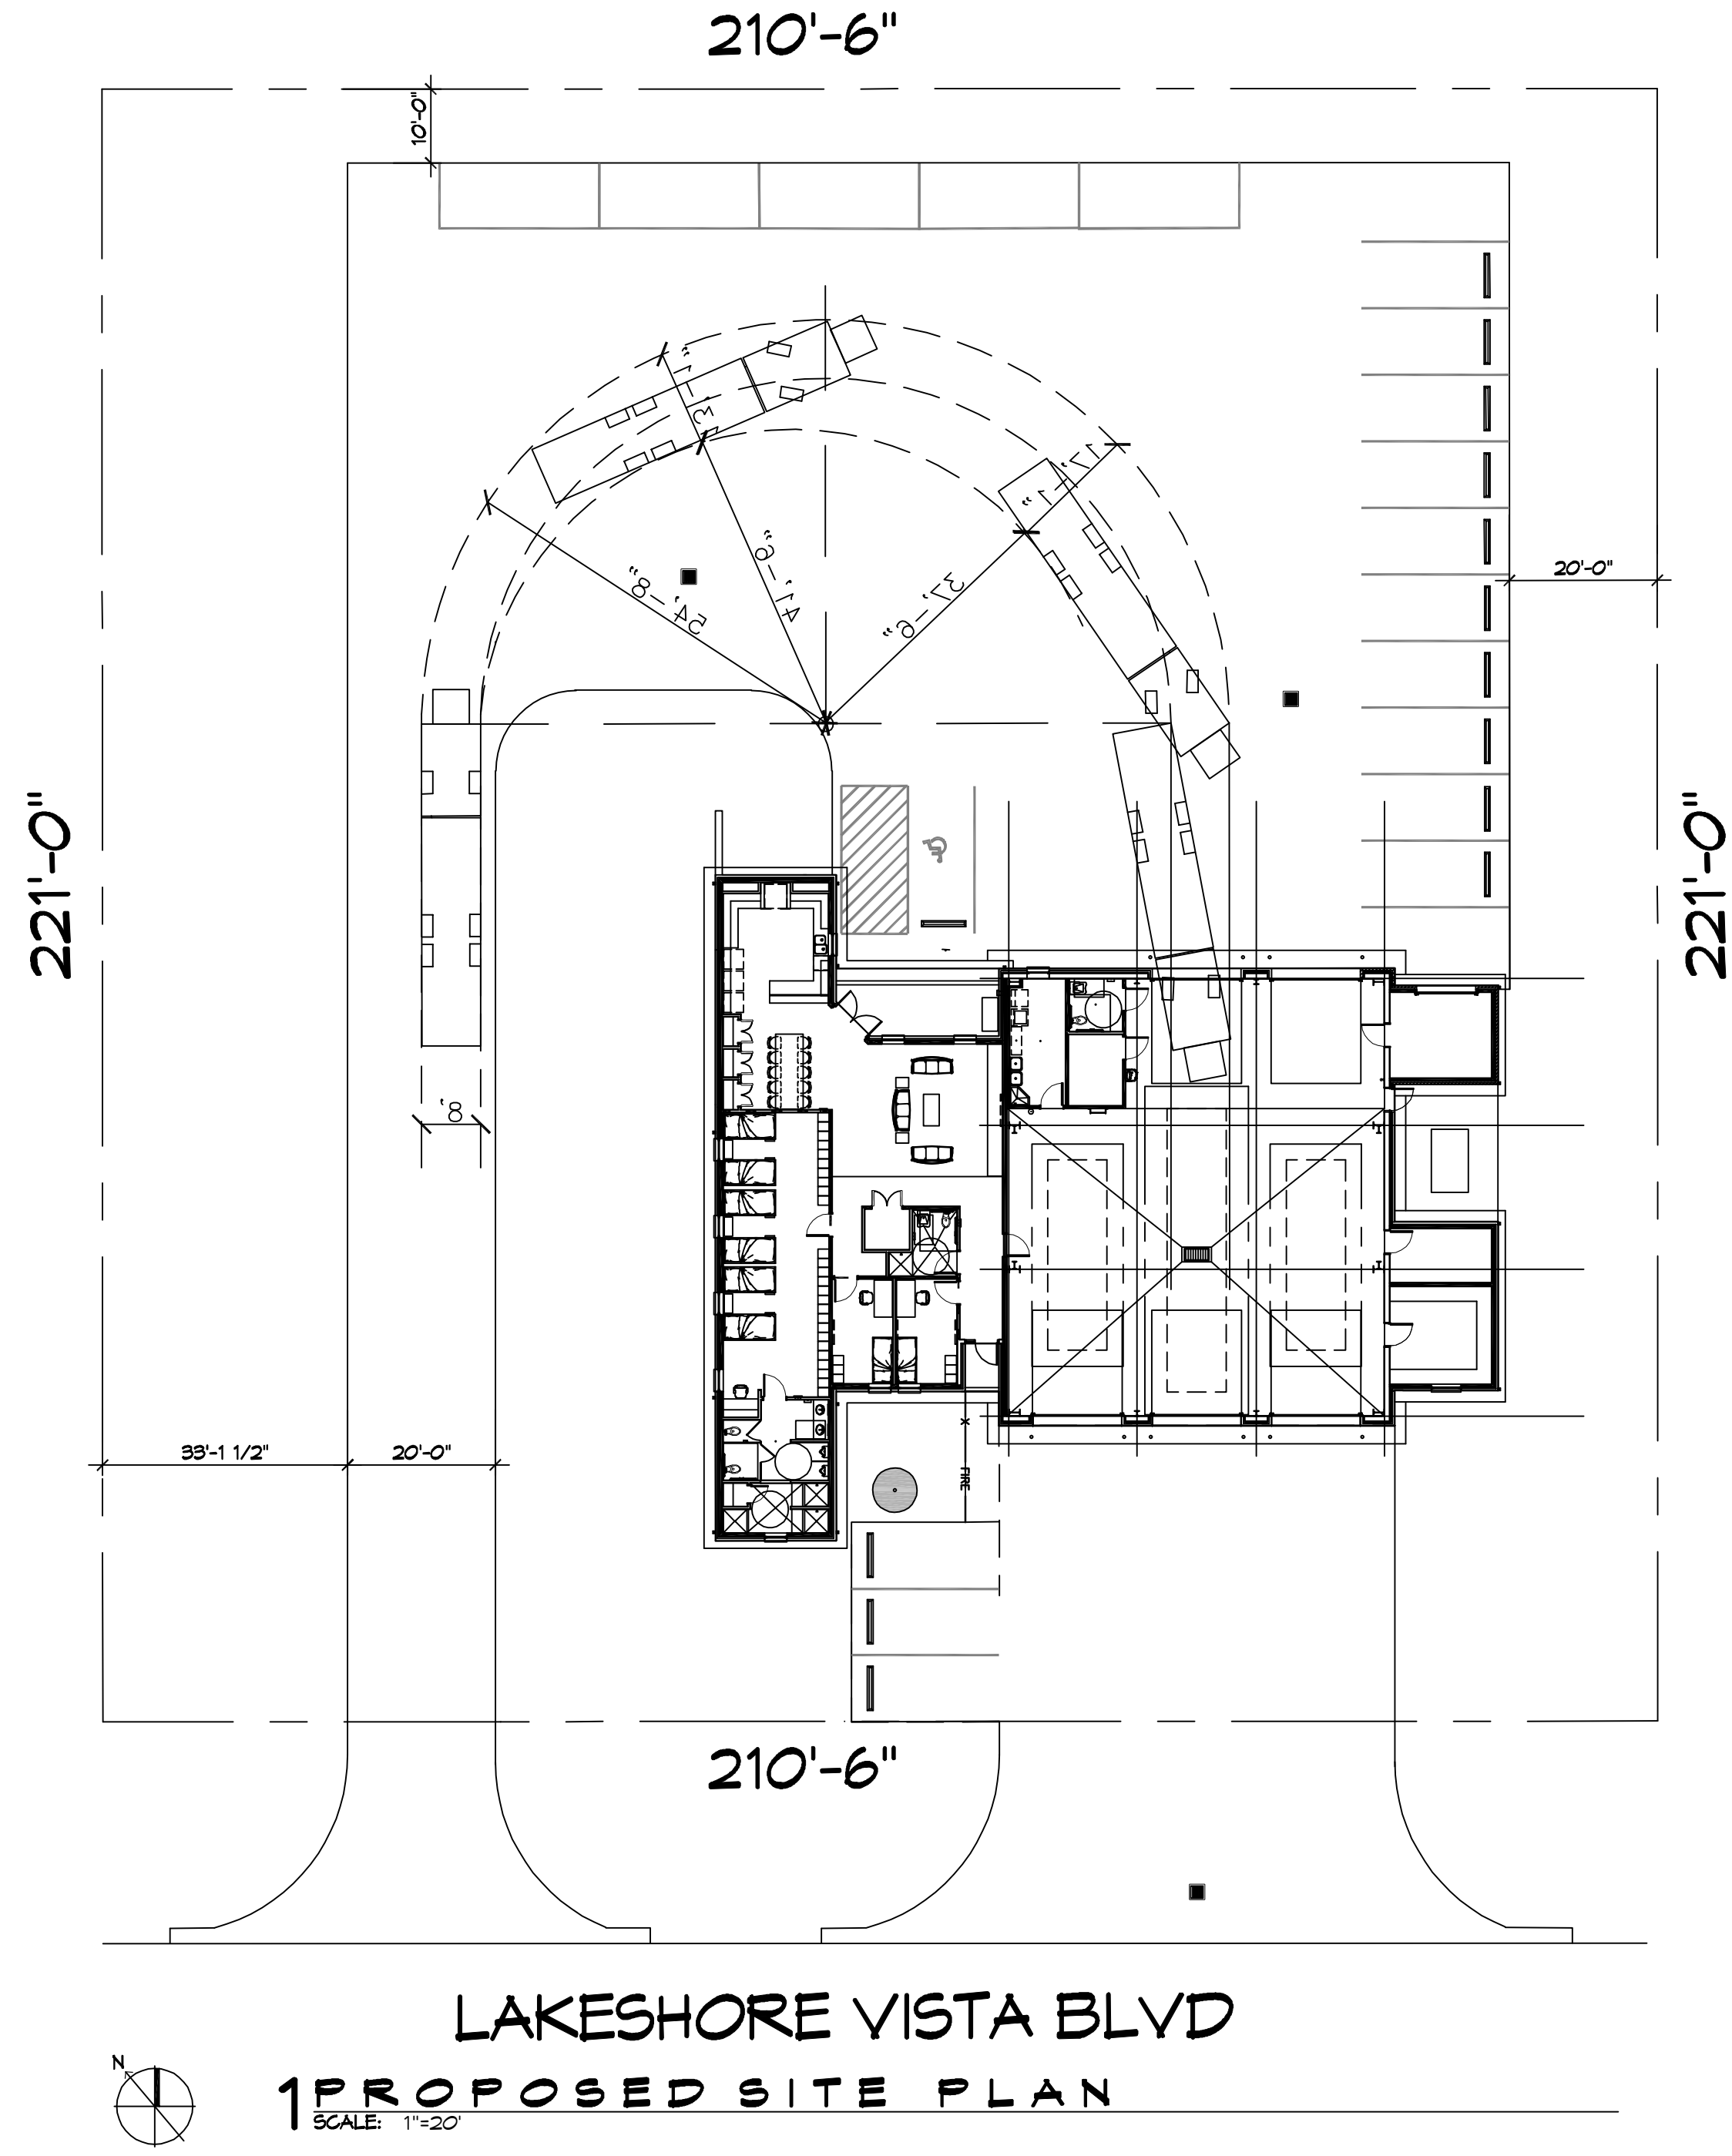

DAMMON

ENGINEERING, INC.

LOUISIANA & MISSISSIPPI

Chief Engineer: Brian Metch, PE  
 554 Old Spanish Trail  
 Slidell, LA 70458  
 www.dammonengineering.com  
 info@dammonengineering.com  
 PH: 985.649.5332

#	DESCRIPTION	DATE

SEAL:

NEW FIRE STATION #10

ST. TAMMANY FIRE PROTECTION

DISTRICT NO. 1

LAKESHORE VISTA BLVD  
 SLIDELL, LA 70458  
 JOB No: 25-001  
 DATE: 06-17-2025  
 DRAWN BY: CKD  
 CHECKED BY: CKD

SHEET TITLE:  
PROPOSED SITE PLAN

DRAWING NUMBER:  
C101